




THESE DOCUMENTS ARE INSTRUMENTS OF SERVICE. REMAIN THE PROPERTY OF THE ARCHITECT AND NO PART THEREOF MAY BE REPRODUCED OR USED IN ANY FORM WITHOUT WRITTEN PERMISSION.

Table with columns for DATE, REVISIONS, and NO.

CONSTRUCTION DOCUMENTS

FLOOR PLAN WING B - HVAC

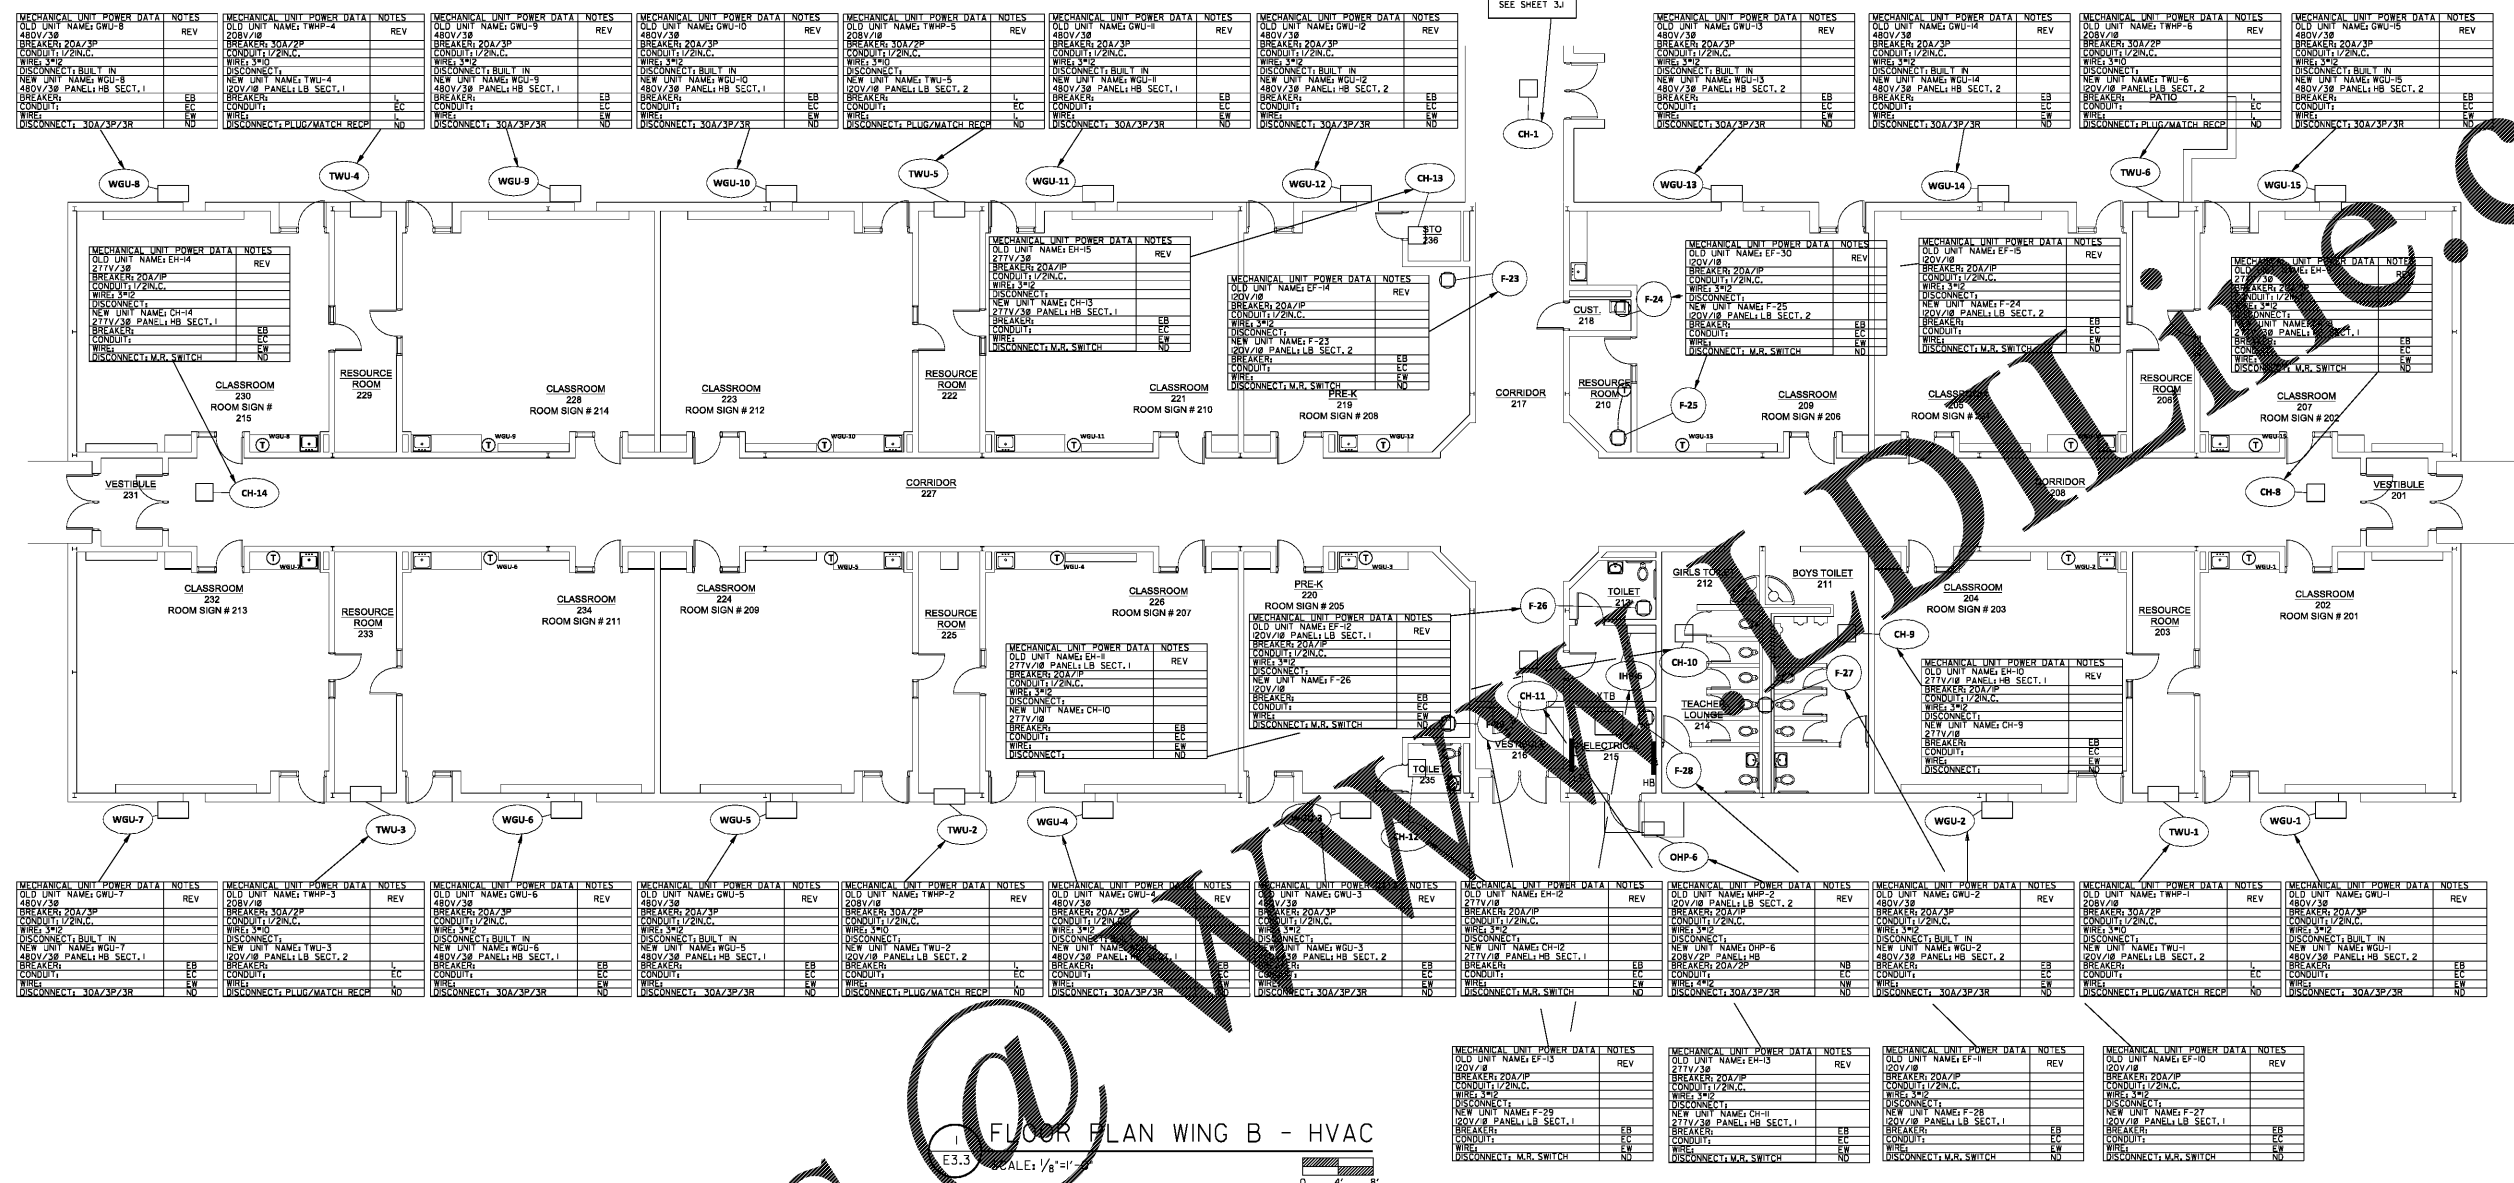


FLOOR PLAN WING B - HVAC  
E3.3 SCALE: 1/8"=1'-0"

MECHANICAL UNIT POWER DATA NOTES (THIS SHEET ONLY) table with columns for OLD UNIT NAME, REV, and NOTES.

MECHANICAL UNIT POWER DATA NOTES table with columns for OLD UNIT NAME, REV, and NOTES.

MECHANICAL POWER UNIT DATA NOTES: (THIS SHEET ONLY)

- NEW UNIT
ES- EXISTING UNIT TO REMAIN AS-IS
ER- EXISTING UNIT TO BE REMOVED AND NOT REPLACED
RE- EXISTING UNIT TO BE REMOVED AND REPLACED
EB- EXISTING BREAKER TO BE REUSED
EC- EXISTING CONDUIT TO BE REUSED
EW- EXISTING WIRE TO BE REUSED
ET- EXISTING THERMOSTAT TO BE REUSED
RT- EXISTING THERMOSTAT TO BE REPLACED
RB- EXISTING BREAKER TO BE REPLACED
RC- EXISTING CONDUIT TO BE REPLACED
RW- EXISTING WIRE TO BE REPLACED
RD- EXISTING DISCONNECT TO BE REPLACED
RT- EXISTING THERMOSTAT TO BE REPLACED
NB- TOTALLY NEW BREAKER
NC- TOTALLY NEW CONDUIT
NW- TOTALLY NEW WIRE
ND- TOTALLY NEW DISCONNECT
NT- TOTALLY NEW THERMOSTAT
SD- PROVIDE DUCT SMOKE DETECTION SUPPLY DUCT

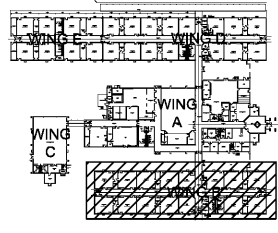

KEYPLAN

Order Plans