



THESE DOCUMENTS, AS INSTRUMENTS OF SERVICE, REMAIN THE PROPERTY OF ARCHITECT AND NO PART OR REPRODUCED IN ANY FORM WITHOUT WRITTEN PERMISSION

Table with columns: NO., REVISIONS, DATE.


CONSTRUCTION DOCUMENTS

FLOOR PLAN WING D - HVAC

SHEET **E3.4**
29 OF 32

FILE: 18.08
DATE: 12/14/18

Grid of Mechanical Unit Power Data Notes tables for units WGU-31 through WGU-38 and TWU-10 through TWU-12.

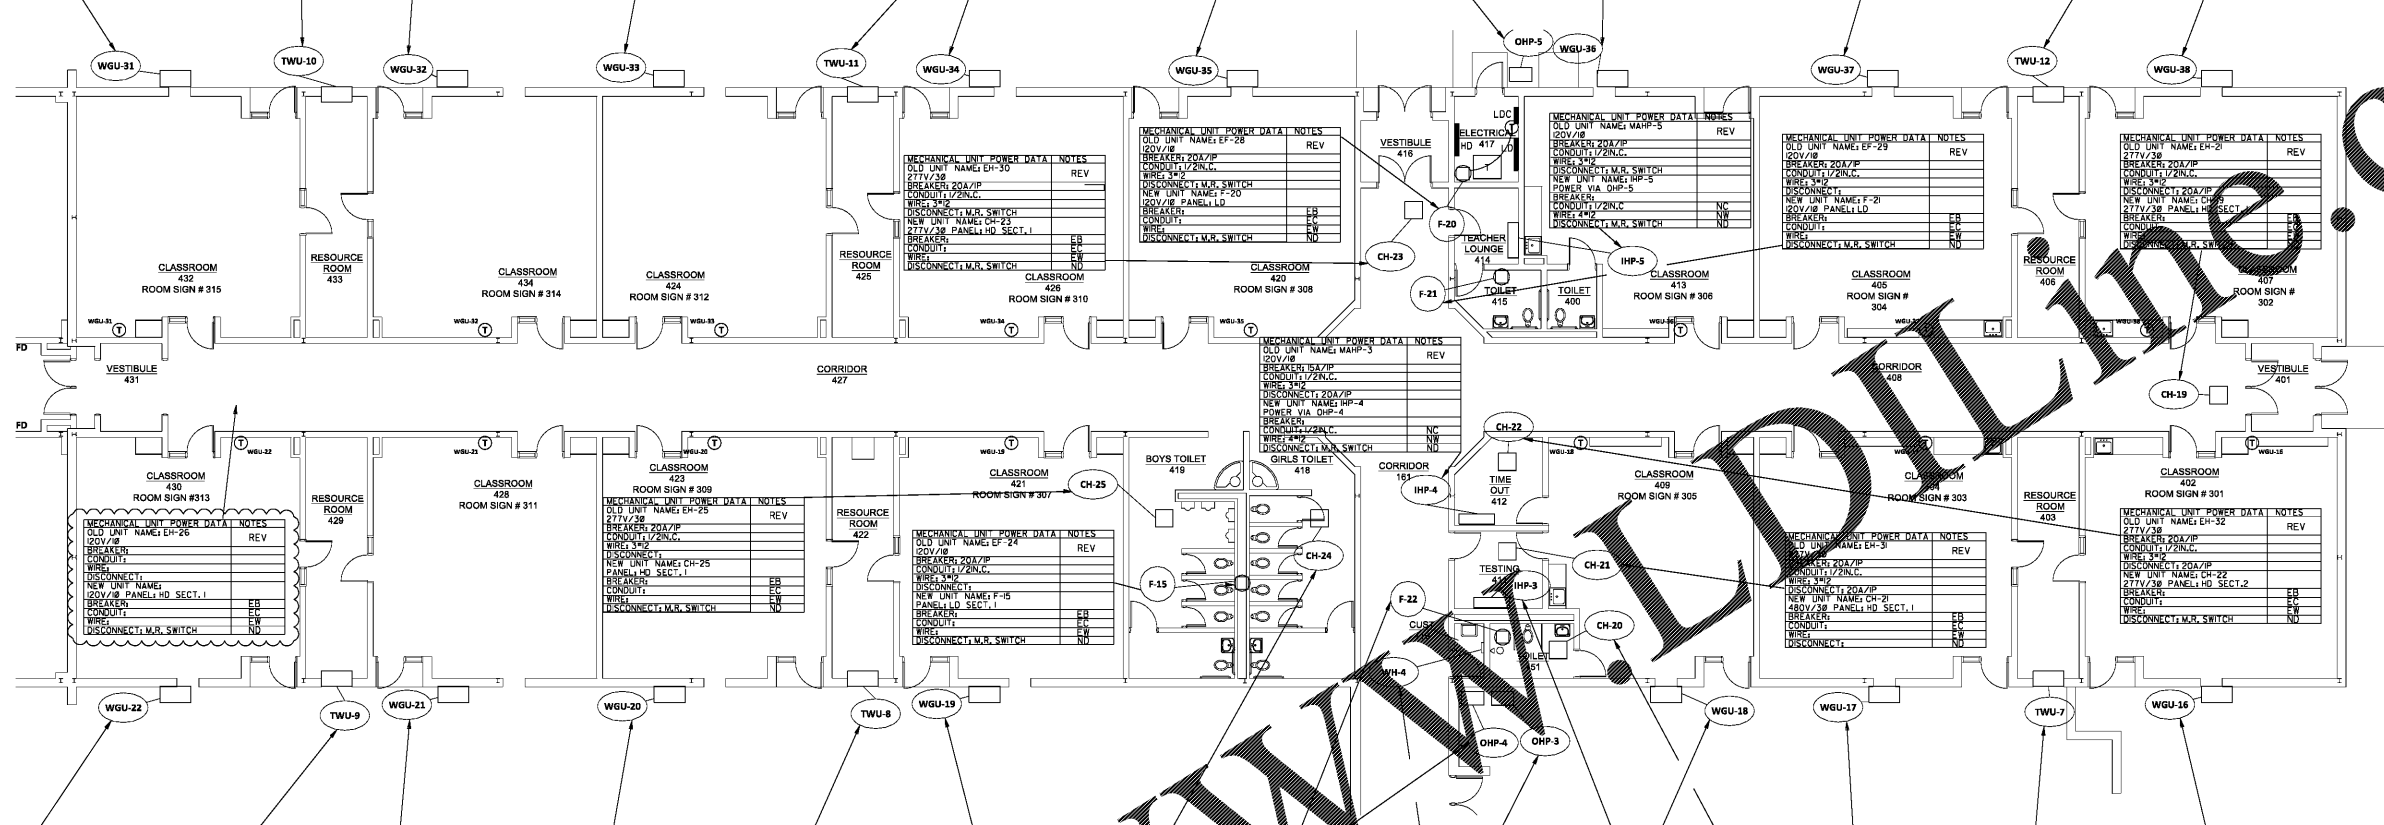

Grid of Mechanical Unit Power Data Notes tables for units WGU-22 through WGU-30 and TWU-9 through TWU-12.

WWW.Deloach.com

FLOOR PLAN WING D - HVAC


E3.4 SCALE: 1/8"=1'-0"



MECHANICAL POWER UNIT DATA NOTES: (THIS SHEET ONLY)

- Y- NEW UNIT
ES- EXISTING UNIT TO REMAIN AS-IS
ER- EXISTING UNIT TO BE REMOVED AND NOT REPLACED
EX- EXISTING UNIT TO BE REMOVED AND REPLACED
EB- EXISTING BREAKER TO BE REUSED
EC- EXISTING CONDUIT TO BE REUSED
EW- EXISTING WIRE TO BE REUSED
ED- EXISTING DISCONNECT TO BE REUSED
ET- EXISTING THERMOSTAT TO BE USED
RB- EXISTING BREAKER TO BE REPLACED
RC- EXISTING CONDUIT TO BE REPLACED
RW- EXISTING WIRE TO BE REPLACED
RD- EXISTING DISCONNECT TO BE REPLACED
RT- EXISTING THERMOSTAT TO BE REPLACED
NB- TOTALLY NEW BREAKER
NC- TOTALLY NEW CONDUIT
NW- TOTALLY NEW WIRE
ND- TOTALLY NEW DISCONNECT
NT- TOTALLY NEW THERMOSTAT
SD- PROVIDE DUCT SMOKE DETECTION SUPPLY DUCT

NOTES:
1. UTILIZE ONE POLE OF EXISTING BREAKER, AND UTILIZE EXISTING CONDUCTORS AS REQUIRED PER 2017 NEC.

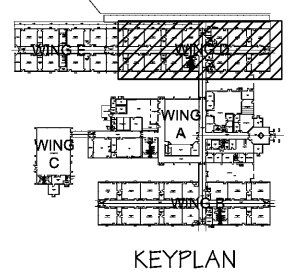

Order Plans

1/18/2018 11:41 AM