


2 HVAC DEMOLITION PLAN - WING "E"
SCALE: 1/8" = 1'-0"


- DEMOLITION NOTES (THIS SHEET ONLY):**
- ▽ DEMOLISH EXISTING EXHAUST GRILLE.
 - ▽ DEMOLISH EXISTING FAN AND ASSOCIATED ACCESSORIES. DUCT RISER TO REMAIN.
 - ▽ EXISTING DELTA CONTROL DEVICE TO REMAIN.
 - ▽ DEMOLISH EXISTING ELECTRIC HEATER AND ASSOCIATED ACCESSORIES.
 - ▽ DEMOLISH EXISTING WALL-MOUNT GAS UNIT AND ASSOCIATED AIR DEVICES, WIRING, CONTROLS AND ACCESSORIES. REMOVE EXISTING ABOVE-GROUND GAS PIPING.
 - ▽ DEMOLISH EXISTING THRU-WALL UNIT AND ASSOCIATED LOUVER AND ACCESSORIES.
 - ▽ DEMOLISH EXISTING MINI SPLIT SYSTEM AND ASSOCIATED ACCESSORIES.

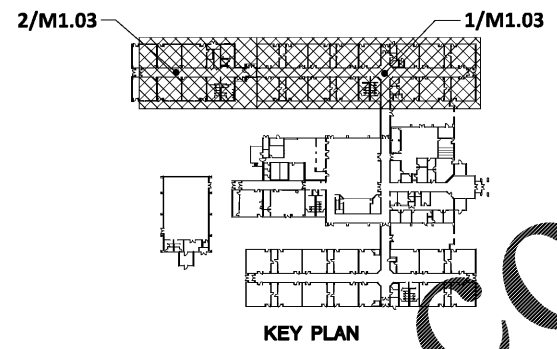

DELOACH
721 WALNUT STREET
POST OFFICE BOX 6926
MADON GEORGIA 31208
phone 478-742-4999
fax 478-742-5207
dtd.gp@deloacharchitects.com

ARCHITECTS
PC

HVAC & LIGHTING REPLACEMENT AT
KINGSTON ELEMENTARY SCHOOL
240 HARDIN BRIDGE ROAD, KINGSTON, GA 30145
FOR THE BARTOW COUNTY SCHOOL SYSTEM - DR. PHILIP D. PAGE, SUPERINTENDENT
CARTERSVILLE, GEORGIA

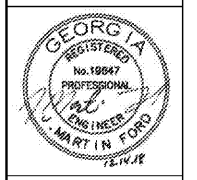

FRUETT, RORD & ASSOCIATES, INC.
CONSULTING ENGINEERS
124 BROAD STREET, SUITE 3A
AUGUSTA, GEORGIA 30601
706-725-2899 • FAX 706-725-2727


THESE DOCUMENTS, AS SHOWN, ARE THE PROPERTY OF THE ARCHITECT AND NO PART THEREOF MAY BE USED OR REPRODUCED IN ANY FORM WITHOUT WRITTEN PERMISSION

NO.	REVISIONS	DATE


CONSTRUCTION DOCUMENTS

HVAC PLAN
SCALE: 1/8" = 1'-0"
SHEET
M1.03
12 OF 30

FILE: 18_04
DATE: 12/14/18

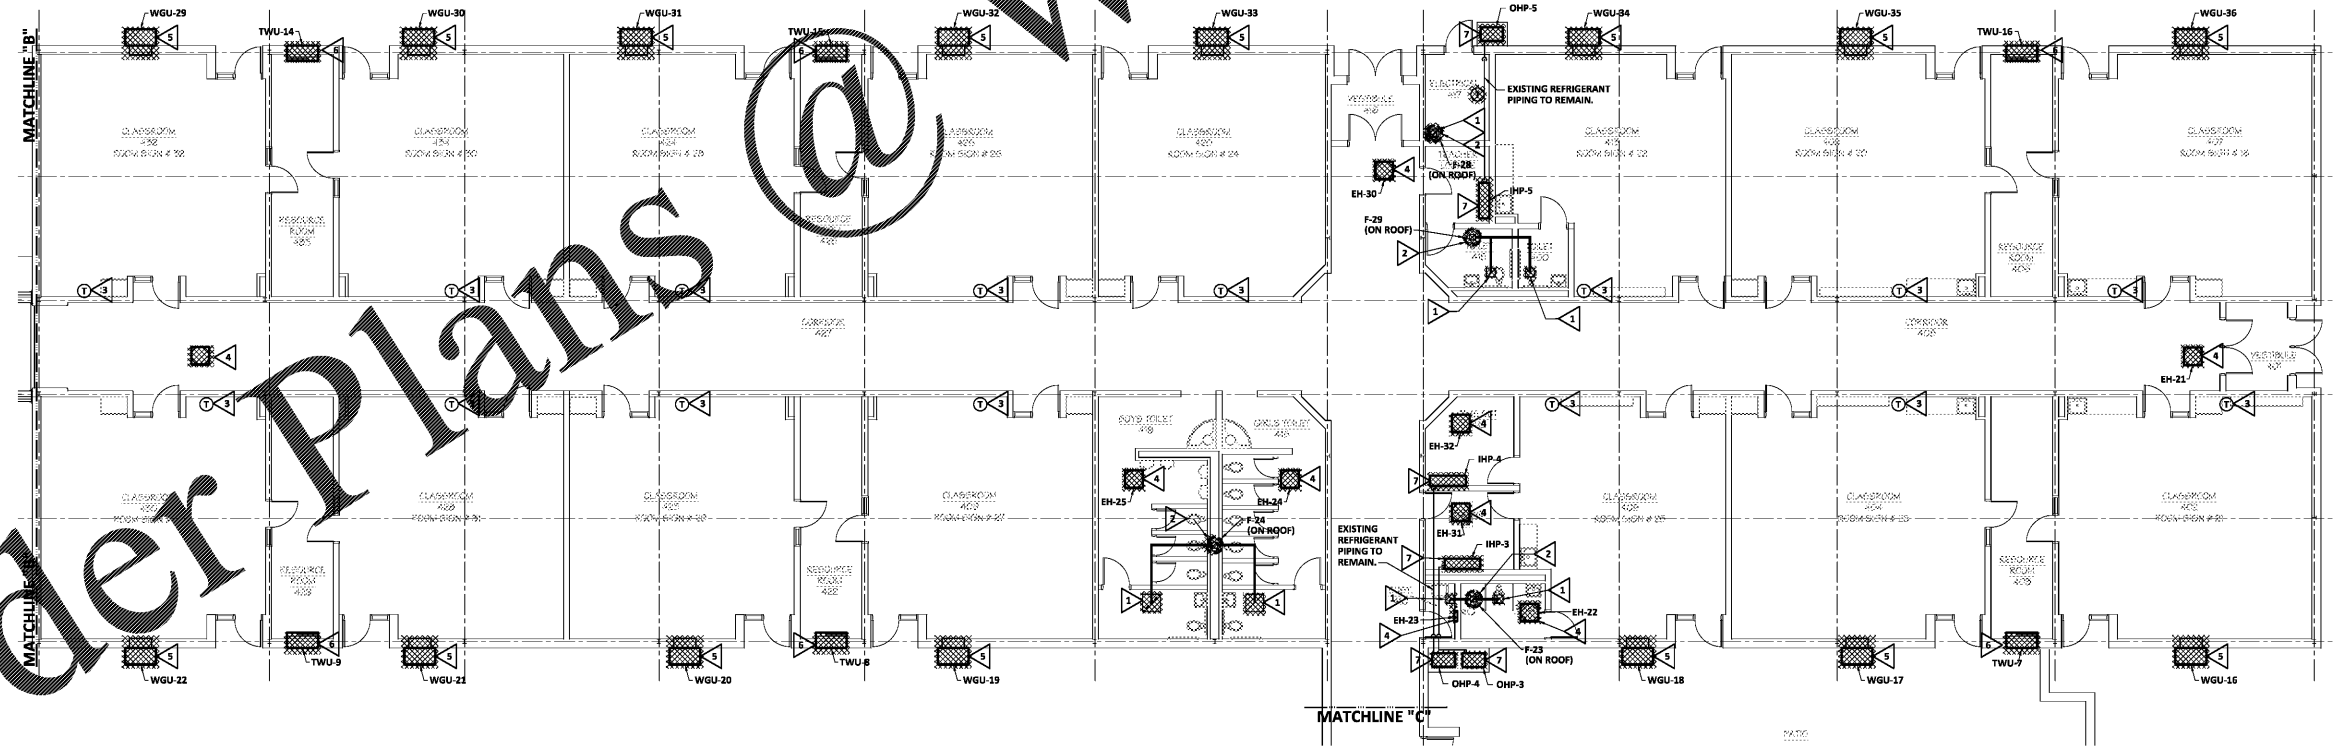

 1 HVAC DEMOLITION PLAN - WING "D"
SCALE: 1/8" = 1'-0"



REFERENCE SCALE
PLOT DATE: 12/14/18
FILENAME: 18108M1
PLOT SCALE: 1 = 96
JLS

Order Plans @ WWW.LDILine.com