




THESE DOCUMENTS, AS INSTRUMENTS OF SERVICE, REMAIN THE PROPERTY OF ARCHITECT AND NO PART THEREOF MAY BE USED OR REPRODUCED IN ANY FORM WITHOUT WRITTEN PERMISSION

NO.	REVISIONS	DATE

CONSTRUCTION DOCUMENT:


FLOOR PLAN WING B - HVAC

SHEET
E3.3
26 OF 30
FILE: 18.10
DATE: 12/14/18

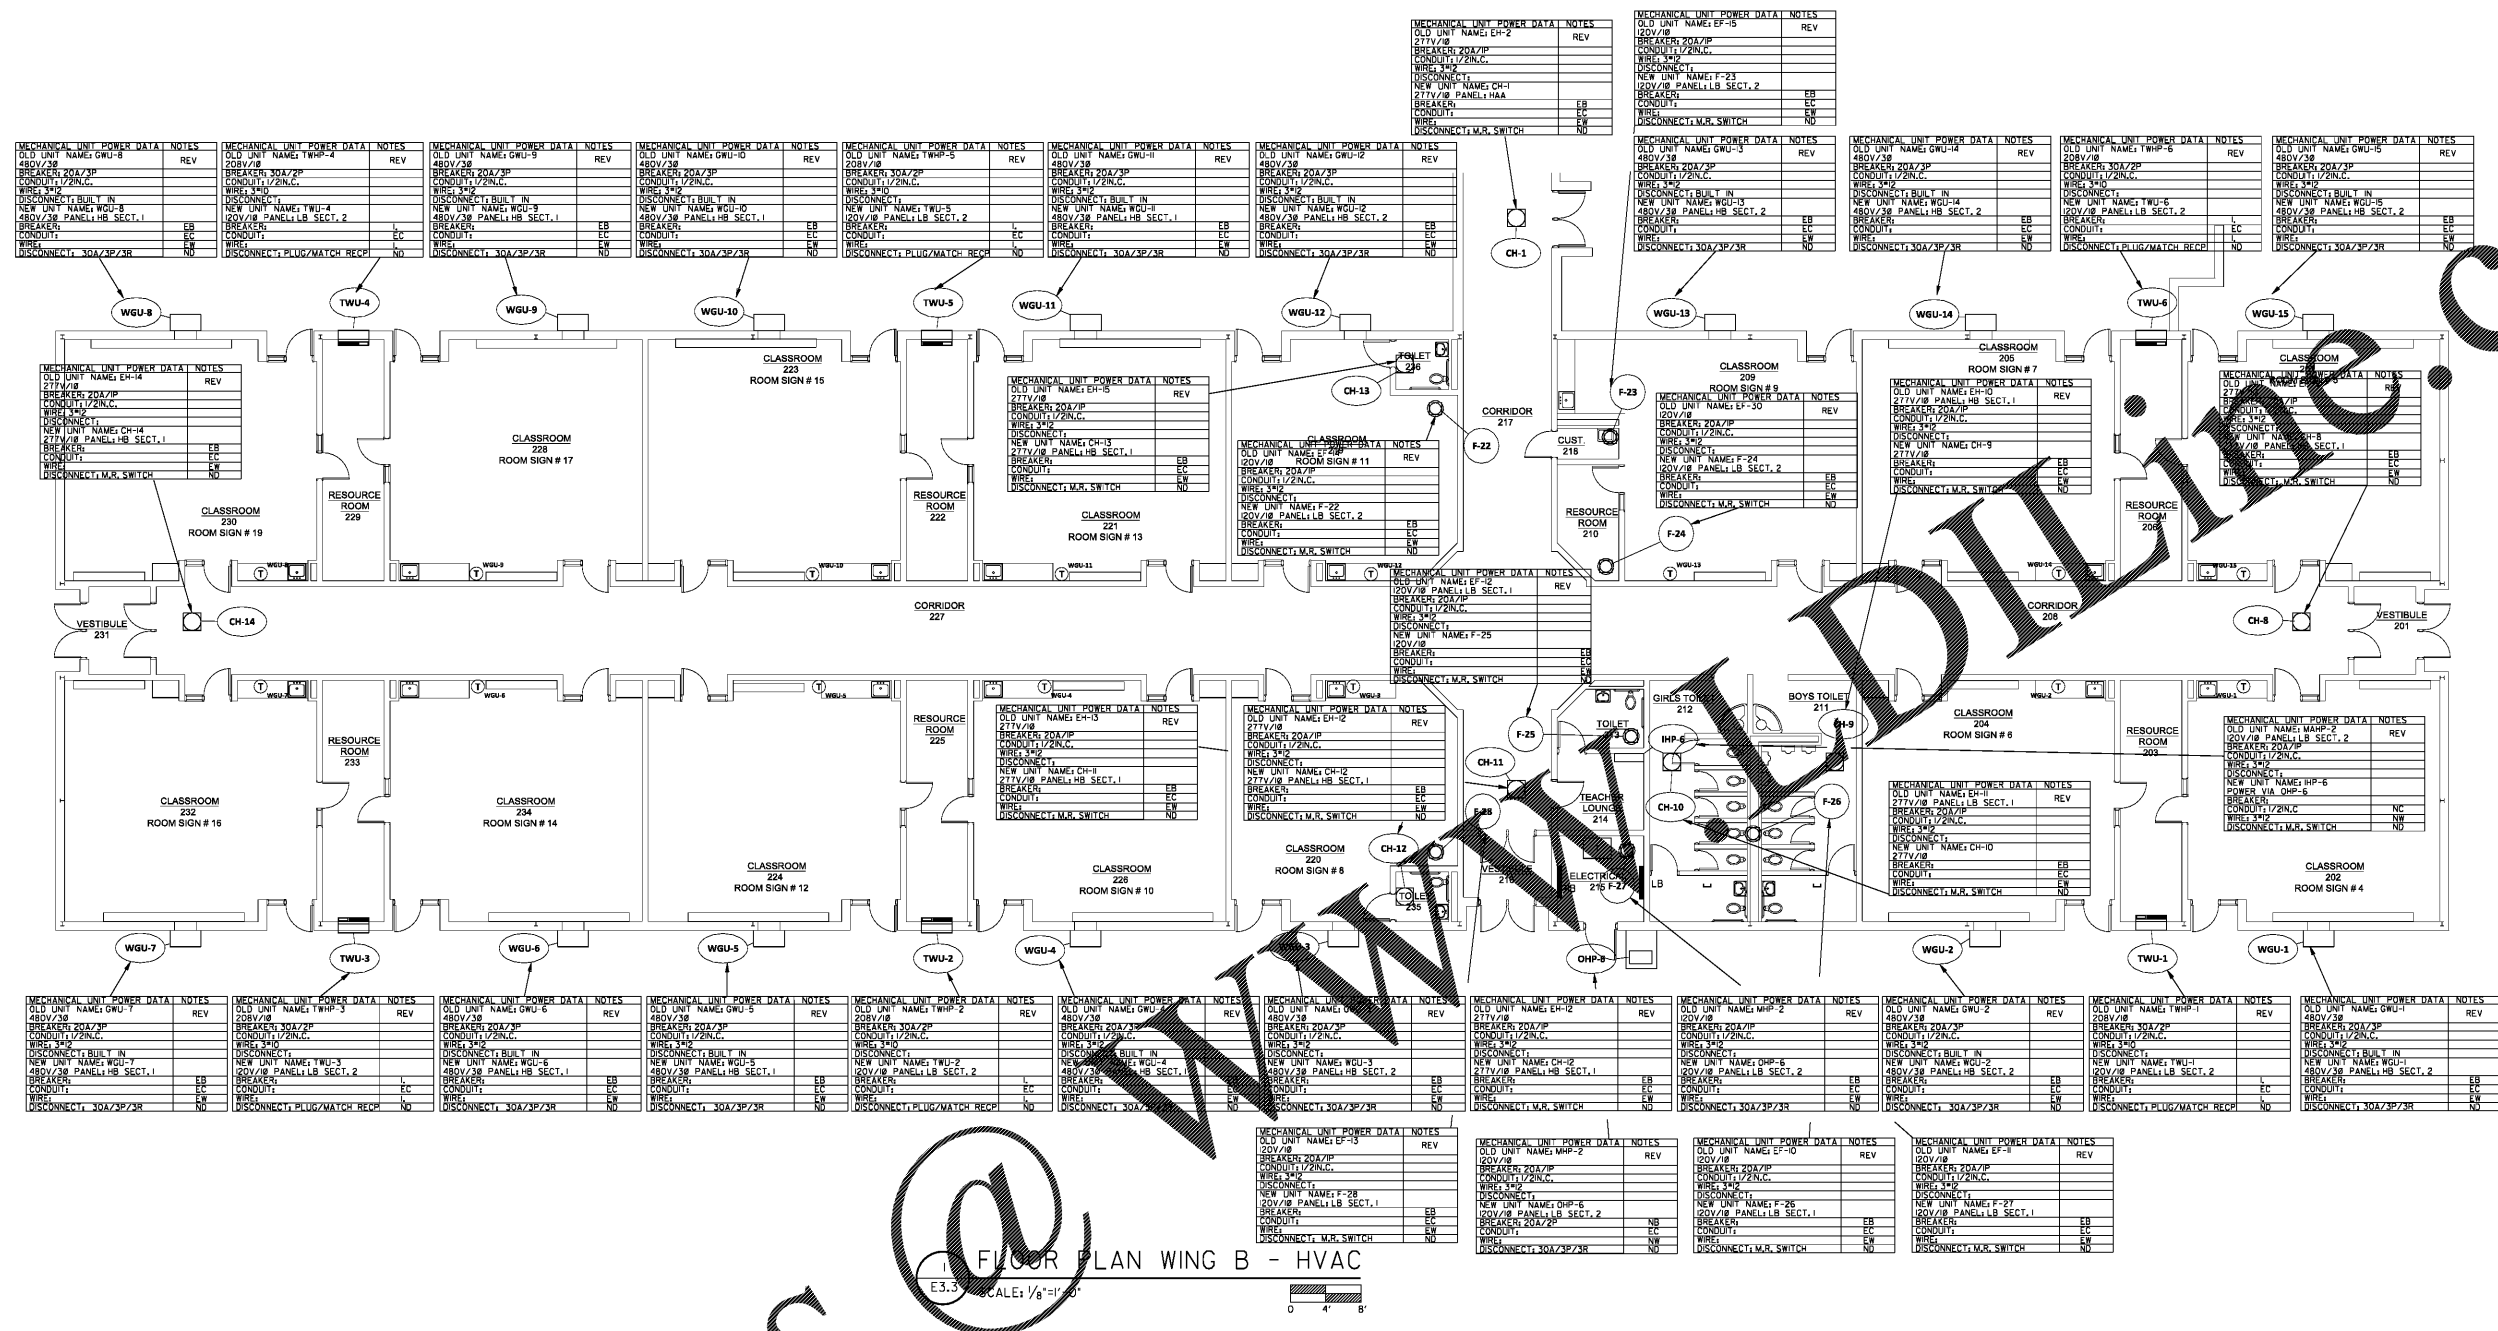

FLOOR PLAN WING B - HVAC
E3.3 SCALE: 1/8"=1'-0"

MECHANICAL POWER UNIT DATA NOTES: (THIS SHEET ONLY)
N- NEW UNIT
ES- EXISTING UNIT TO REMAIN AS-IS
ER- EXISTING UNIT TO BE REMOVED AND NOT REPLACED
REV- EXISTING UNIT TO BE REMOVED AND REPLACED
EB- EXISTING BREAKER TO BE REUSED
EC- EXISTING CONDUIT TO BE REUSED
EW- EXISTING WIRE TO BE REUSED
ET- EXISTING THERMOSTAT TO BE REUSED
ET- EXISTING THERMOSTAT TO BE USED
RE- EXISTING BREAKER TO BE REPLACED
RC- EXISTING CONDUIT TO BE REPLACED
RW- EXISTING WIRE TO BE REPLACED
RT- EXISTING THERMOSTAT TO BE REPLACED
NW- TOTALLY NEW WIRE
NE- TOTALLY NEW DISCONNECT
NT- TOTALLY NEW THERMOSTAT
SD- PROVIDE DUCT SMOKE DETECTION SUPPLY DUCT
NOTES:
1- UTILIZE ONE POLE OF EXISTING BREAKER, AND UTILIZE EXISTING CONDUCTORS AS REQUIRED PER 2017 NEC.

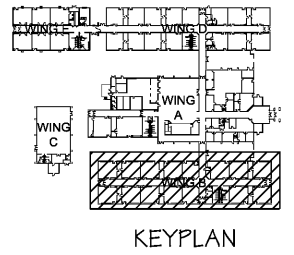

Order Plans