





FRUETT, FORD & ASSOCIATES, INC.
 CONSULTING ENGINEERS
 100 BROAD STREET, SUITE 3A
 AUGUSTA, GEORGIA 30601
 706.733.1111

THESE DOCUMENTS, AS INSTRUMENTS OF SERVICE, REMAIN THE PROPERTY OF THE ARCHITECT AND NO PART THEREOF MAY BE USED OR REPRODUCED IN ANY FORM WITHOUT WRITTEN PERMISSION.


NO.	REVISIONS	DATE

CONSTRUCTION DOCUMENTS

HVAC PLAN
 SCALE: 1/8" = 1'-0"
 SHEET
M1.01
 XXX OF 32
 FILE: 18.04
 DATE: 12/14/18

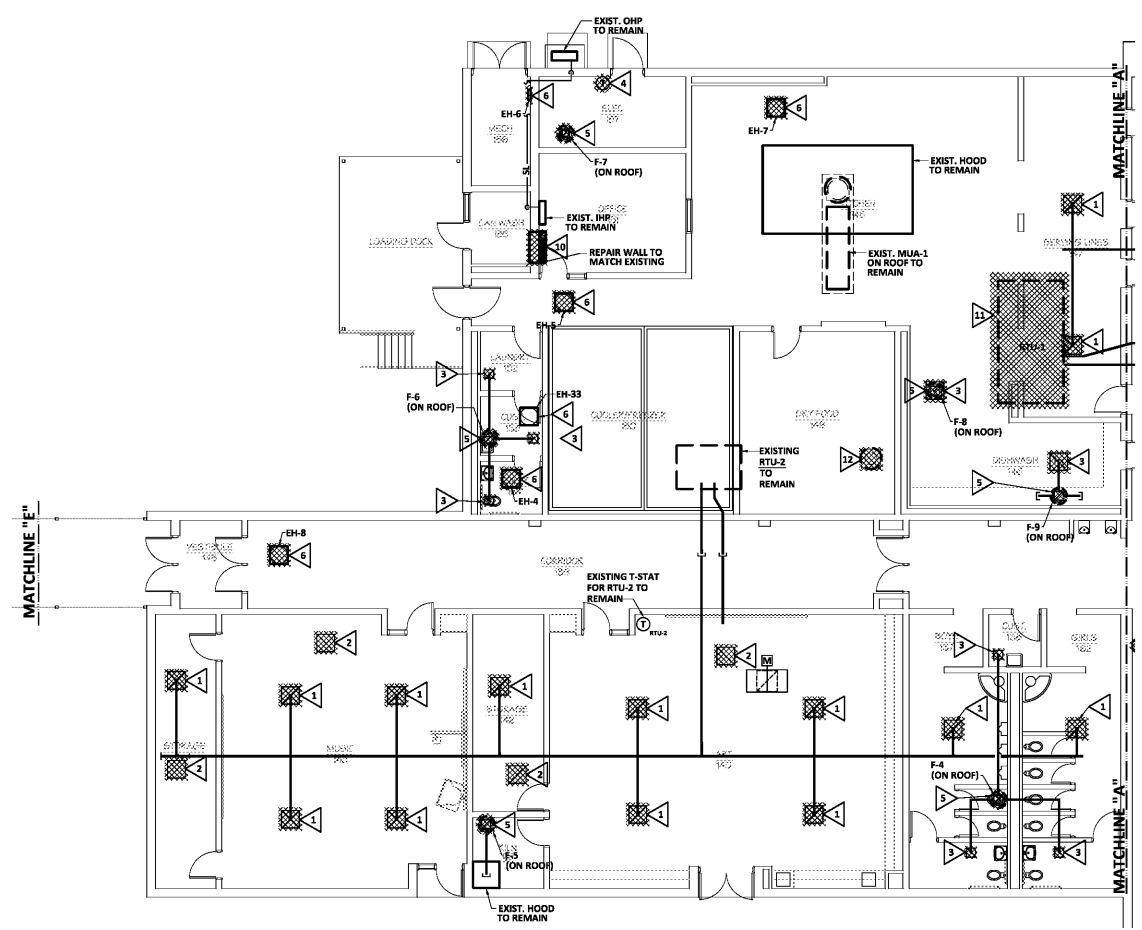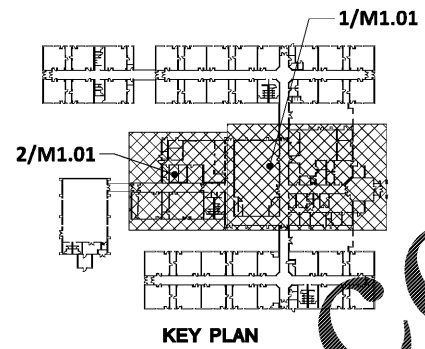


HVAC DEMOLITION PLAN - WING "A"
 SCALE: 1/8" = 1'-0"

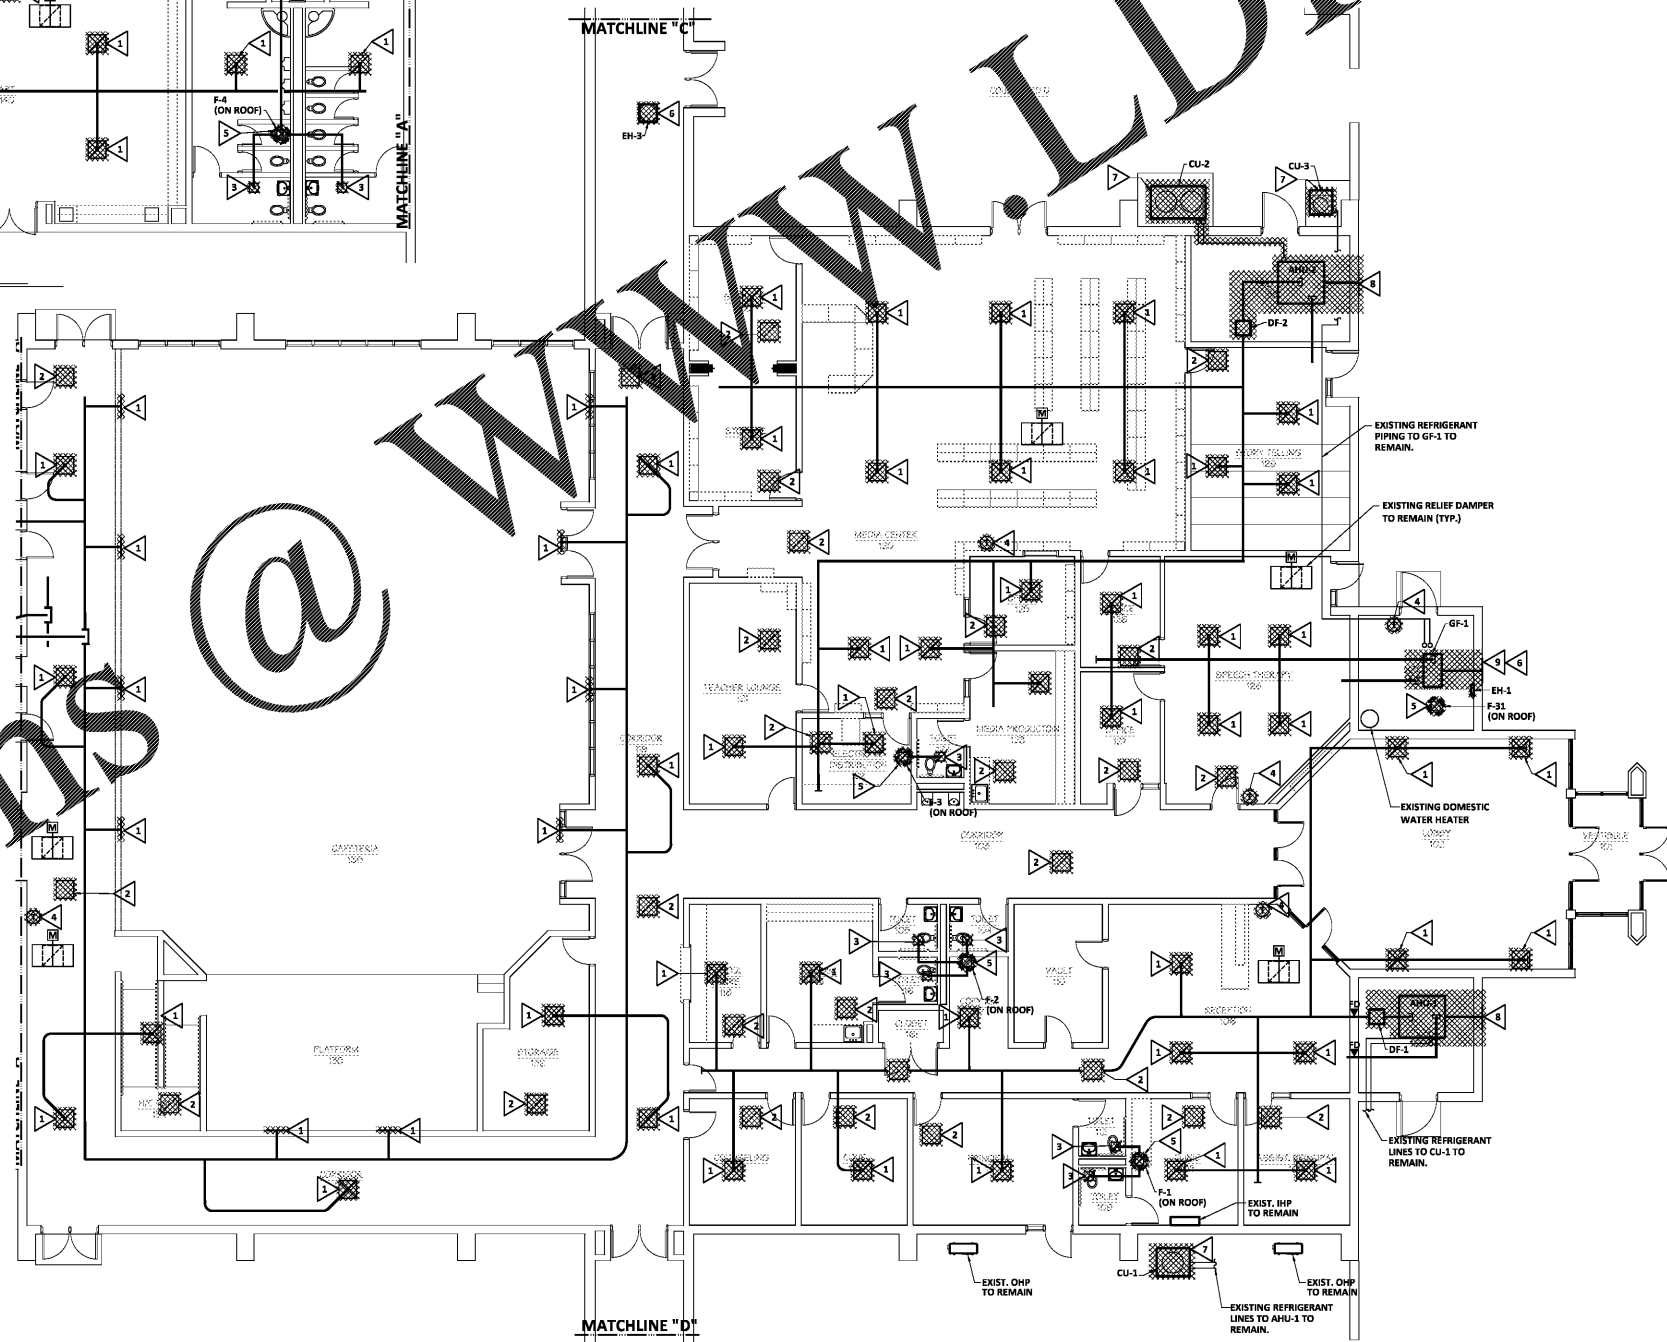

HVAC DEMOLITION PLAN - WING "A"
 SCALE: 1/8" = 1'-0"

DEMOLITION NOTES (THIS SHEET ONLY):

 - DEMOLISH EXISTING SUPPLY DIFFUSER.
- DEMOLISH EXISTING RETURN GRILLE.
- DEMOLISH EXISTING EXHAUST GRILLE.
- DEMOLISH EXISTING THERMOSTAT.
- DEMOLISH EXISTING FAN AND ASSOCIATED ACCESSORIES. DUCT RISER TO REMAIN.
- DEMOLISH EXISTING ELECTRIC HEATER AND ASSOCIATED ACCESSORIES.
- DEMOLISH EXISTING CONDENSING UNIT AND ASSOCIATED WIRING, CONTROLS AND ACCESSORIES.
- DEMOLISH EXISTING AIR HANDLING UNIT, ASSOCIATED DUCT FURNACE, WIRING, PIPING, CONTROLS AND ACCESSORIES. DEMOLISH EXISTING DUCTWORK AND LOUVER TO THE EXTENTS SHOWN.
- DEMOLISH EXISTING GAS FURNACE AND ASSOCIATED WIRING, PIPING, CONTROLS AND ACCESSORIES. DEMOLISH ASSOCIATED DUCTWORK AND LOUVER TO THE EXTENTS SHOWN.
- DEMOLISH EXISTING WALL UNIT AND ASSOCIATED LOUVER AND ACCESSORIES.
- DEMOLISH EXISTING ROOF UNIT.
- DEMOLISH EXISTING HEAVY VENTILATOR AND REPAIR RE...



PLOT DATE: 12/14/18
 FILENAME: 18107M1
 PLOT SCALE: 1 = 96
 1/8

Copyright © 2018
 FRUETT, FORD & ASSOCIATES, INC.
 AUGUSTA, GA 30601 (706) 733-1111

Order Plans @ www.LDLine.com