




FRUETT, FORD & ASSOCIATES, INC.
CONSULTING ENGINEERS
100 BRAND STREET, SUITE 3A
ALBUQUERQUE, GEORGIA 30008
478-288-1111

THESE DOCUMENTS, AS INSTRUMENTS OF SERVICE, REMAIN THE PROPERTY OF THE ARCHITECT AND NO PART THEREOF MAY BE USED OR REPRODUCED IN ANY FORM WITHOUT WRITTEN PERMISSION


NO.	REVISIONS	DATE

CONSTRUCTION DOCUMENTS

HVAC PLAN
SCALE: 1/8" = 1'-0"
SHEET
M2.02
XXX OF 32
FILE: 18.04
DATE: 12/14/18

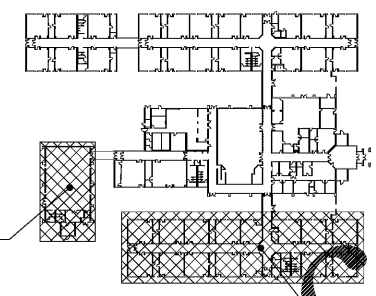


2/M1.02
KEY PLAN
1/M1.02

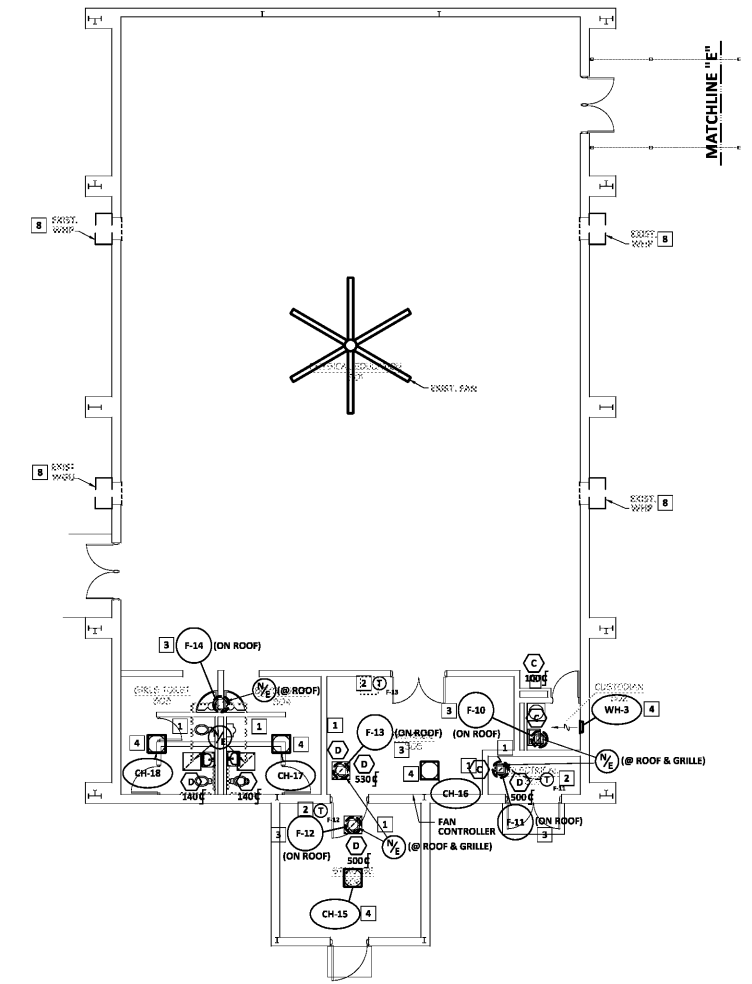


2 HVAC NEW WORK PLAN - WING "C"
SCALE: 1/8" = 1'-0"

KEY NOTES (THIS SHEET ONLY):

- 1 PROVIDE NEW EXHAUST GRILLE IN EXISTING LOCATION.
- 2 PROVIDE NEW THERMOSTAT IN EXISTING LOCATION.
- 3 PROVIDE NEW ROOFTOP FAN AND ASSOCIATED ACCESSORIES IN EXISTING LOCATION. PROVIDE TRANSITION AS REQUIRED TO CONNECT TO EXISTING RISER.
- 4 PROVIDE NEW ELECTRIC HEATER IN EXISTING LOCATION.
- 5 PROVIDE NEW DUCTLESS SPLIT SYSTEM AND ASSOCIATED WIRING, CONTROLS AND ACCESSORIES. CONNECT TO EXISTING REFRIGERANT PIPING.
- 6 PROVIDE NEW WALL-MOUNT GAS UNIT AND ASSOCIATED AIR DEVICES, CONTROLS, WIRING AND ACCESSORIES. CONNECT NEW GAS PIPING TO EXISTING GAS PIPING. FIELD VERIFY EXACT SIZE AND LOCATION. DISCHARGE CONDENSATE TO GRADE AND COORDINATE DRY WELL LOCATION WITH FIELD CONDITIONS. SEE ARCHITECTURAL.
- 7 PROVIDE NEW THRU-WALL UNIT AND ASSOCIATED WIRING, CONTROLS AND ACCESSORIES.
- 8 PROVIDE NEW CONTROLLER FOR EXISTING WALL MOUNT HEAT PUMP. SEE SPECIFICATIONS.
- 9 PURGE, CLEAN AND REUSE EXISTING REFRIGERANT PIPING WHERE POSSIBLE.

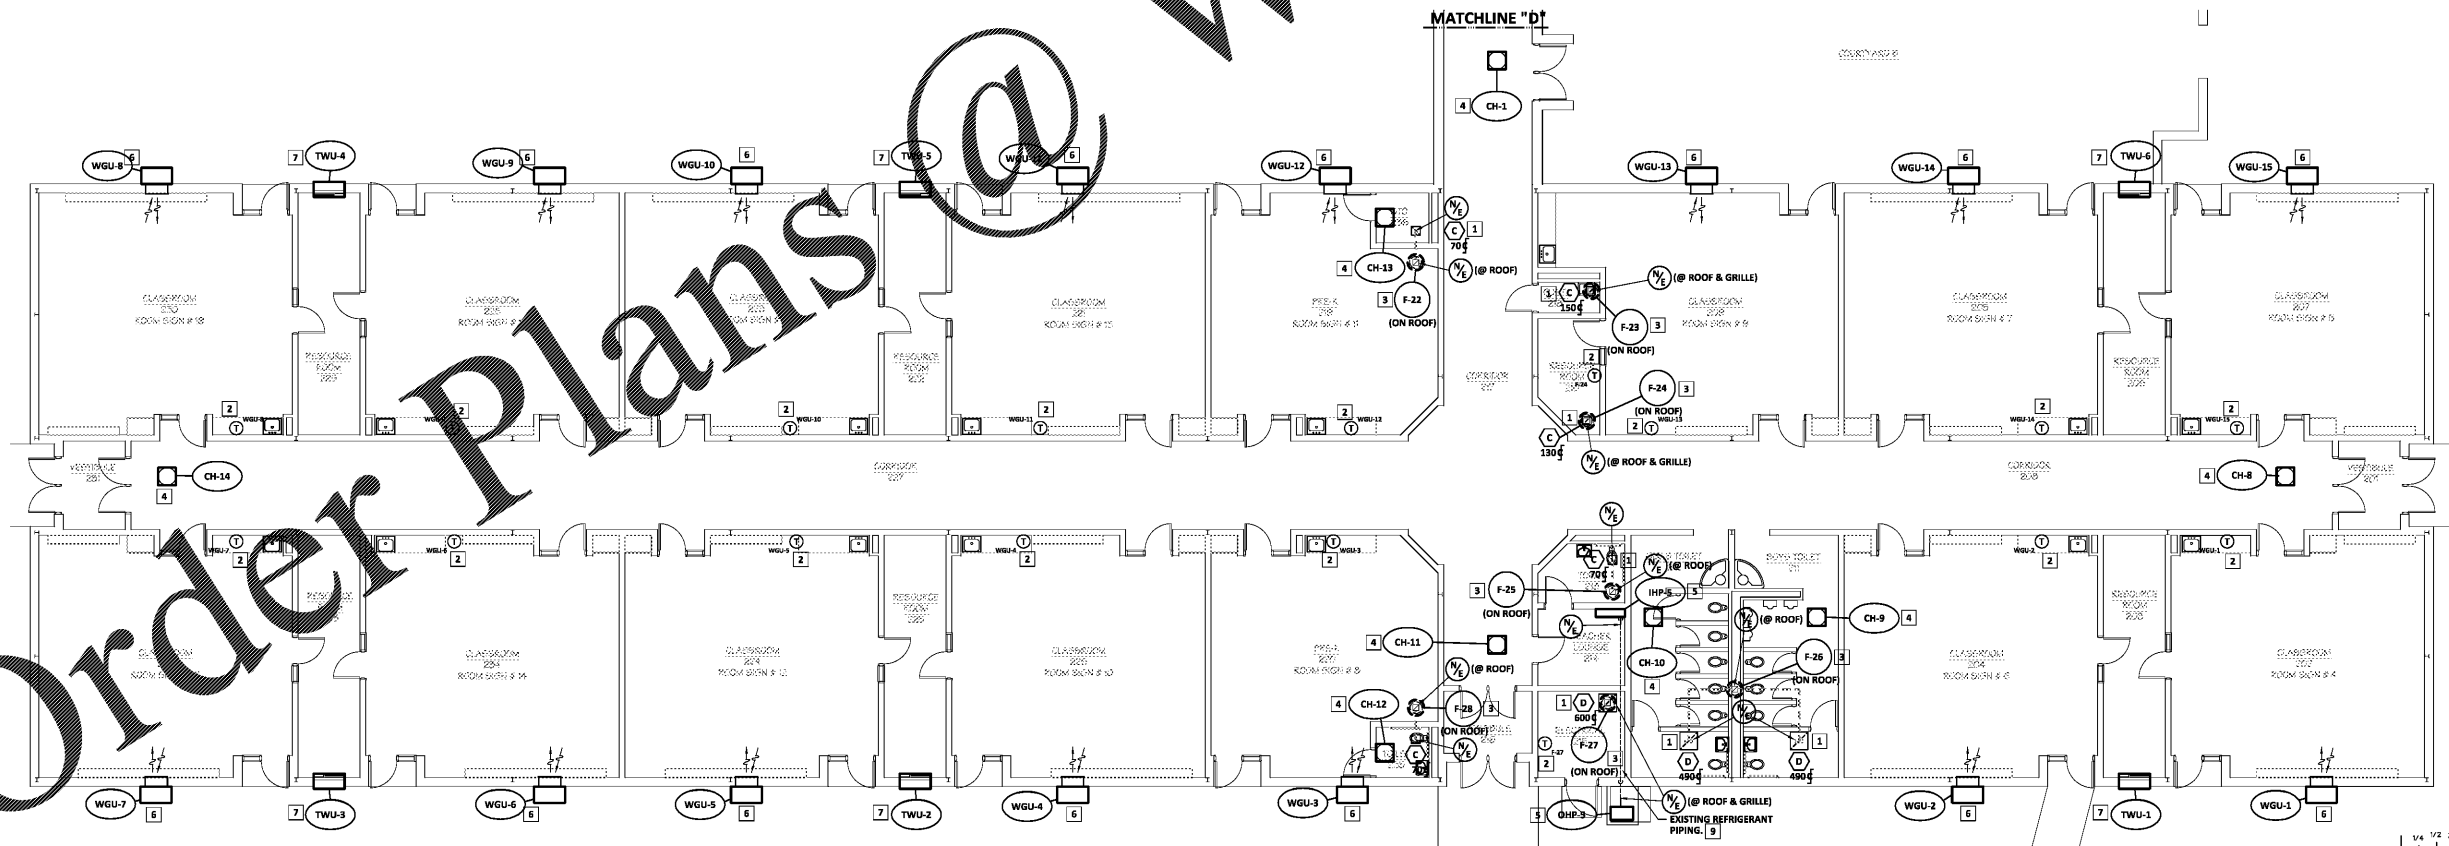

 1 HVAC NEW WORK PLAN - WING "B"
SCALE: 1/8" = 1'-0"



1/4 1/2 3/4
REFERENCE SCALE
PLOT DATE: 12/14/18
FILENAME: 18107M2
PLOT SCALE: 1 = 96
1/8

Order Plans @ www.LDILine.com