

DEMOLITION NOTES:

- 1 REMOVE EXISTING HORIZONTAL FAN COIL UNIT AND ALL ASSOCIATED CONTROLS AND WIRING. DISCONNECT ALL EXISTING PIPING AND DUCTWORK. SEE DETAIL 1, SHEET M402 FOR DISCONNECTION POINTS OF PIPING AND DUCTWORK.
- 2 REMOVE EXISTING ROOF MOUNTED EXHAUST FAN AND CURB DISCONNECT ALL ASSOCIATED DUCT, CONTROLS, AND WIRING. SEE DETAIL 1, SHEET M402 FOR DISCONNECTION POINTS OF DUCTWORK.



FULTON COUNTY SCHOOL SYSTEM
 RIVER EVES ELEMENTARY SCHOOL -
 RENOVATION
 8000 EVES ROAD
 ROSWELL, GA 30076

PROJECT NO: 18046.00

| | |
|------------|------------|
| 50% CD'S | 08/07/2018 |
| PERMIT SET | 02/20/2018 |
| 95% CD'S | 11/08/2018 |
| BID SET | 2/03/2018 |



 


CONTRACT DOCUMENT
 ISSUED FOR
 CONSTRUCTION

| | | | | | | | | | | | | | | | | | | | |
|--|--|--|--|--|--|--|--|--|--|--|--|--|--|--|--|--|--|--|--|
| | | | | | | | | | | | | | | | | | | | |
|--|--|--|--|--|--|--|--|--|--|--|--|--|--|--|--|--|--|--|--|

SHEET TITLE
 MECHANICAL
 DUCTWORK PLAN -
 SECTION D -
 DEMOLITION

SHEET NUMBER
MD101D

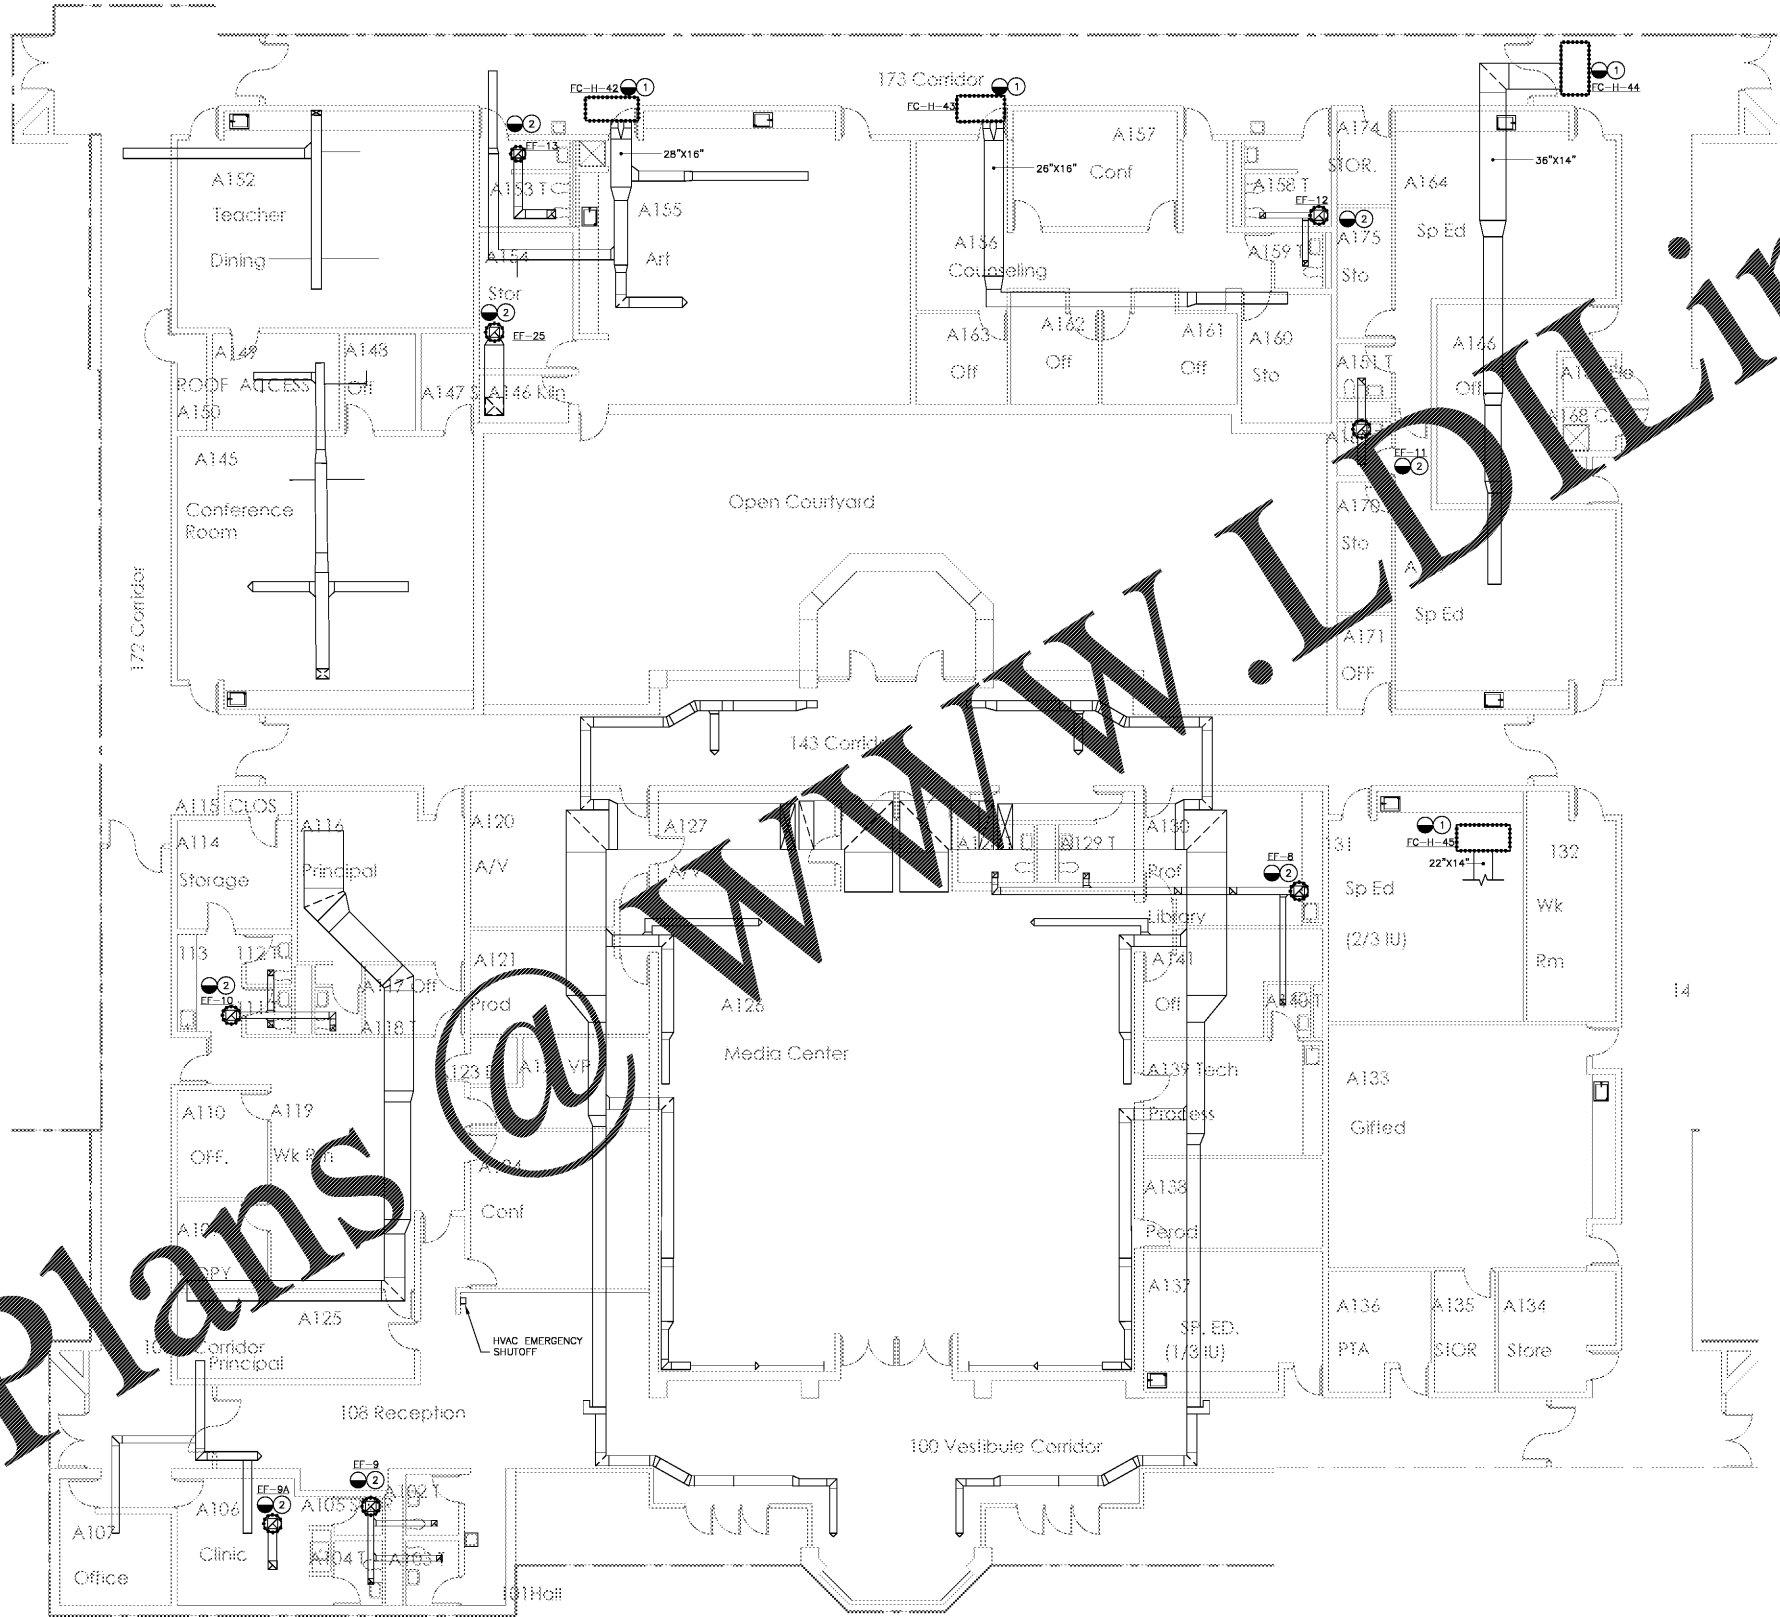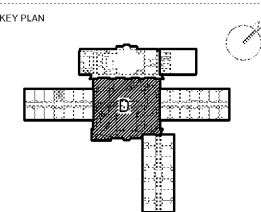

Order Plans @ www.LDLine.com

www.LDLine.com