

DEMOLITION NOTES:
 ① ALTERNATE #5: REMOVE EXISTING CLASSROOM SINK AND ASSOCIATED FAUCET, SUPPLIES, STOPS, TAILPIECE, AND P-TRAP. EXISTING SANITARY, VENT, AND DOMESTIC WATER PIPING SHALL REMAIN FOR REUSE IN NEW WORK.



**FULTON COUNTY SCHOOL SYSTEM
 RIVER EVES ELEMENTARY SCHOOL -
 RENOVATION**
 9000 EYES ROAD
 ROSWELL, GA 30076

PROJECT NO: 18046.00


 

50% CDS	8/07/2018
PERMIT SET	8/20/2018
95% CDS	11/08/2018
BID SET	2/03/2019



CONTRACT DOCUMENT
 ISSUED FOR
 CONSTRUCTION

SHEET TITLE
**PLUMBING PLAN -
 SECTION D -
 DEMOLITION**

SHEET NUMBER
PD101D

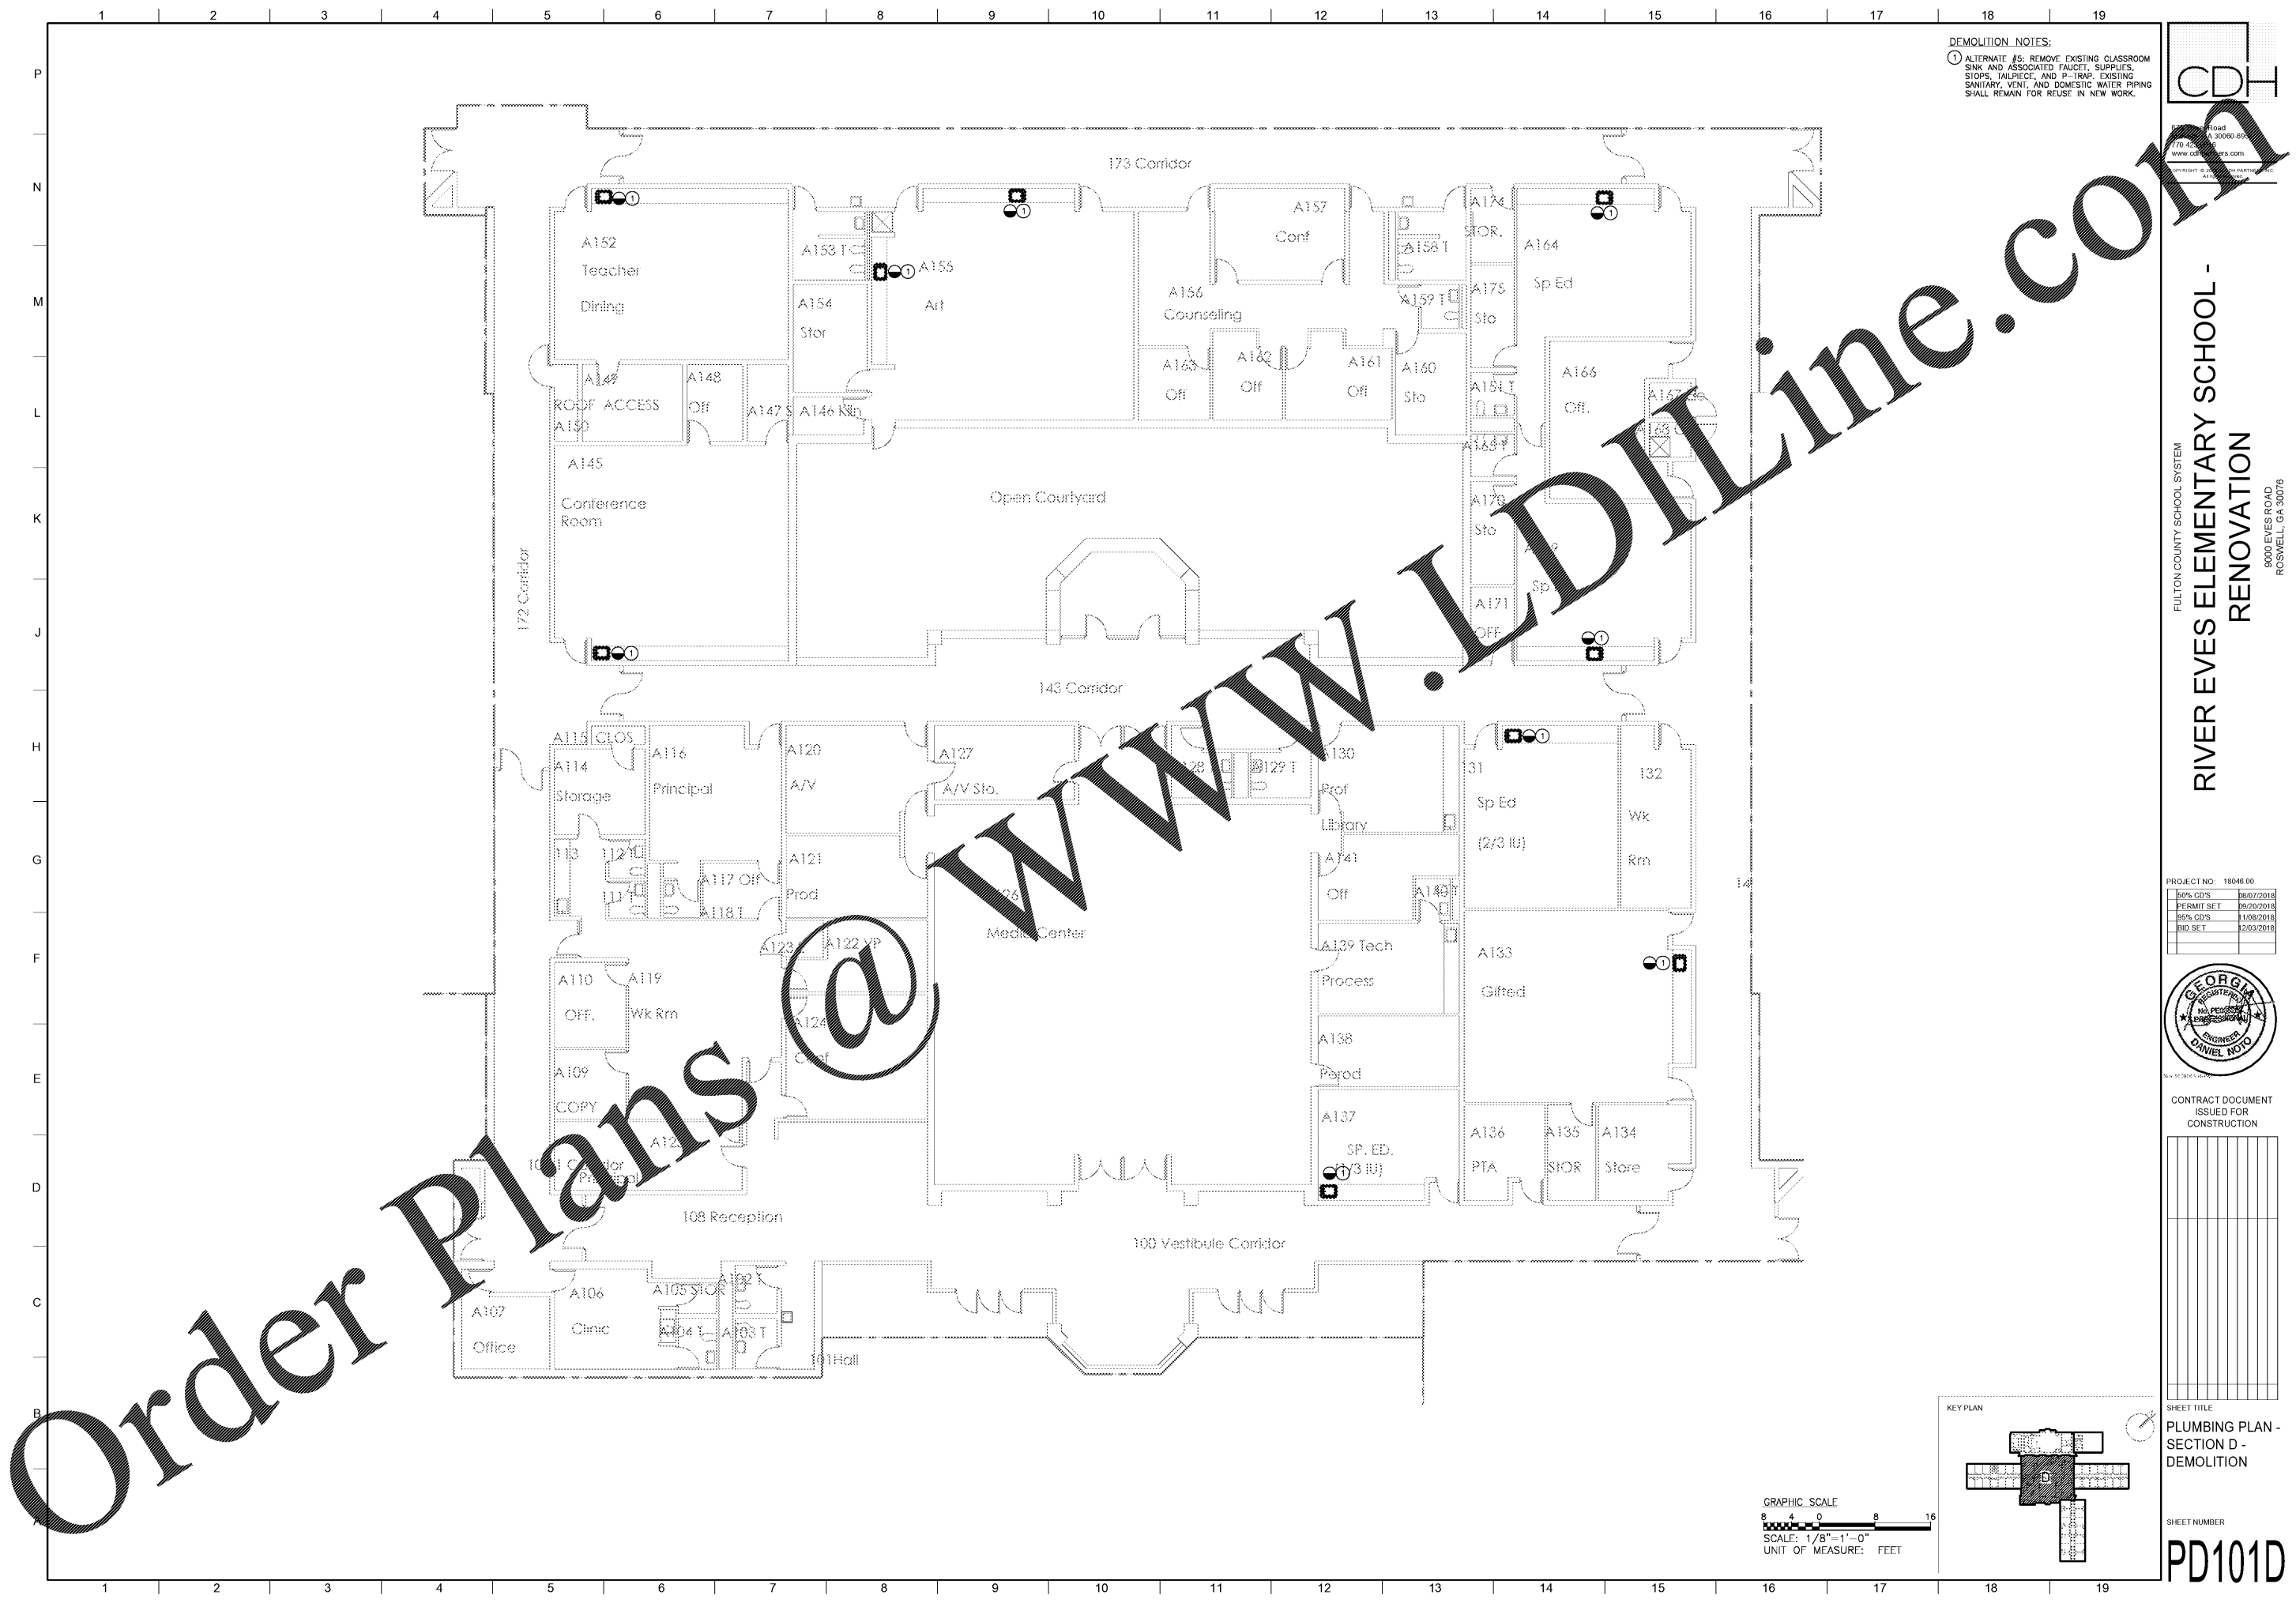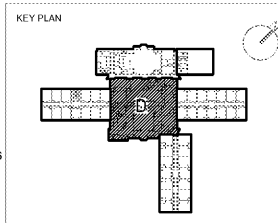

Order Plans @

WWW.IDIline.com