 



GENERAL NOTES

- 1.) ALL EXISTING SECURITY EQUIPMENT AND DEVICES ARE EXISTING TO REMAIN.
- 2.) THE ELECTRICAL CONTRACTOR IS TO VISIT THE SITE AND COMPLETELY REVIEW THE SCOPE OF WORK PRIOR TO BEGINNING THE PROJECT.
- 3.) ANY CIRCUIT OUTSIDE OF THE PHASE II AREA THAT IS AFFECTED BY THE REMOVAL OF A PANEL, CONDUIT, WIRE, ETC. IS TO BE IDENTIFIED AND REPORTED TO THE ARCHITECT IN WRITING UPON DISCOVERY.

SHEET NOTES

- 1 THIS SERVICE EQUIPMENT IS TO REMAIN. LABEL AS SHOWN ON THE DETAILS.
- 2 THE EXISTING FIRE ALARM DEVICES ARE TO BE REMOVED AND REPLACED NEW AS SHOWN ON THE NEW WORK FIRE ALARM PLAN AND COMPLETED IN PHASE I.
- 3 THE EGRESS LIGHTING IN THIS AREA WAS COMPLETED WITH PHASE I.
- 4 THESE FIXTURES ARE EXISTING TO REMAIN AND WERE ADDRESSED IN PHASE I OF THIS PROJECT.
- 5 PANEL P-5 IS TO BE COMPLETELY REMOVED AND REPLACED NEW.
- 6 PANELS P-2, P-3, AND P-4 SHALL BE COMPLETELY REMOVED.
- 7 PANEL SFDPPP IS EXISTING TO REMAIN.
- 8 THE GWH-1 & GWH-2 WERE INSTALLED IN PHASE I OF THIS PROJECT.

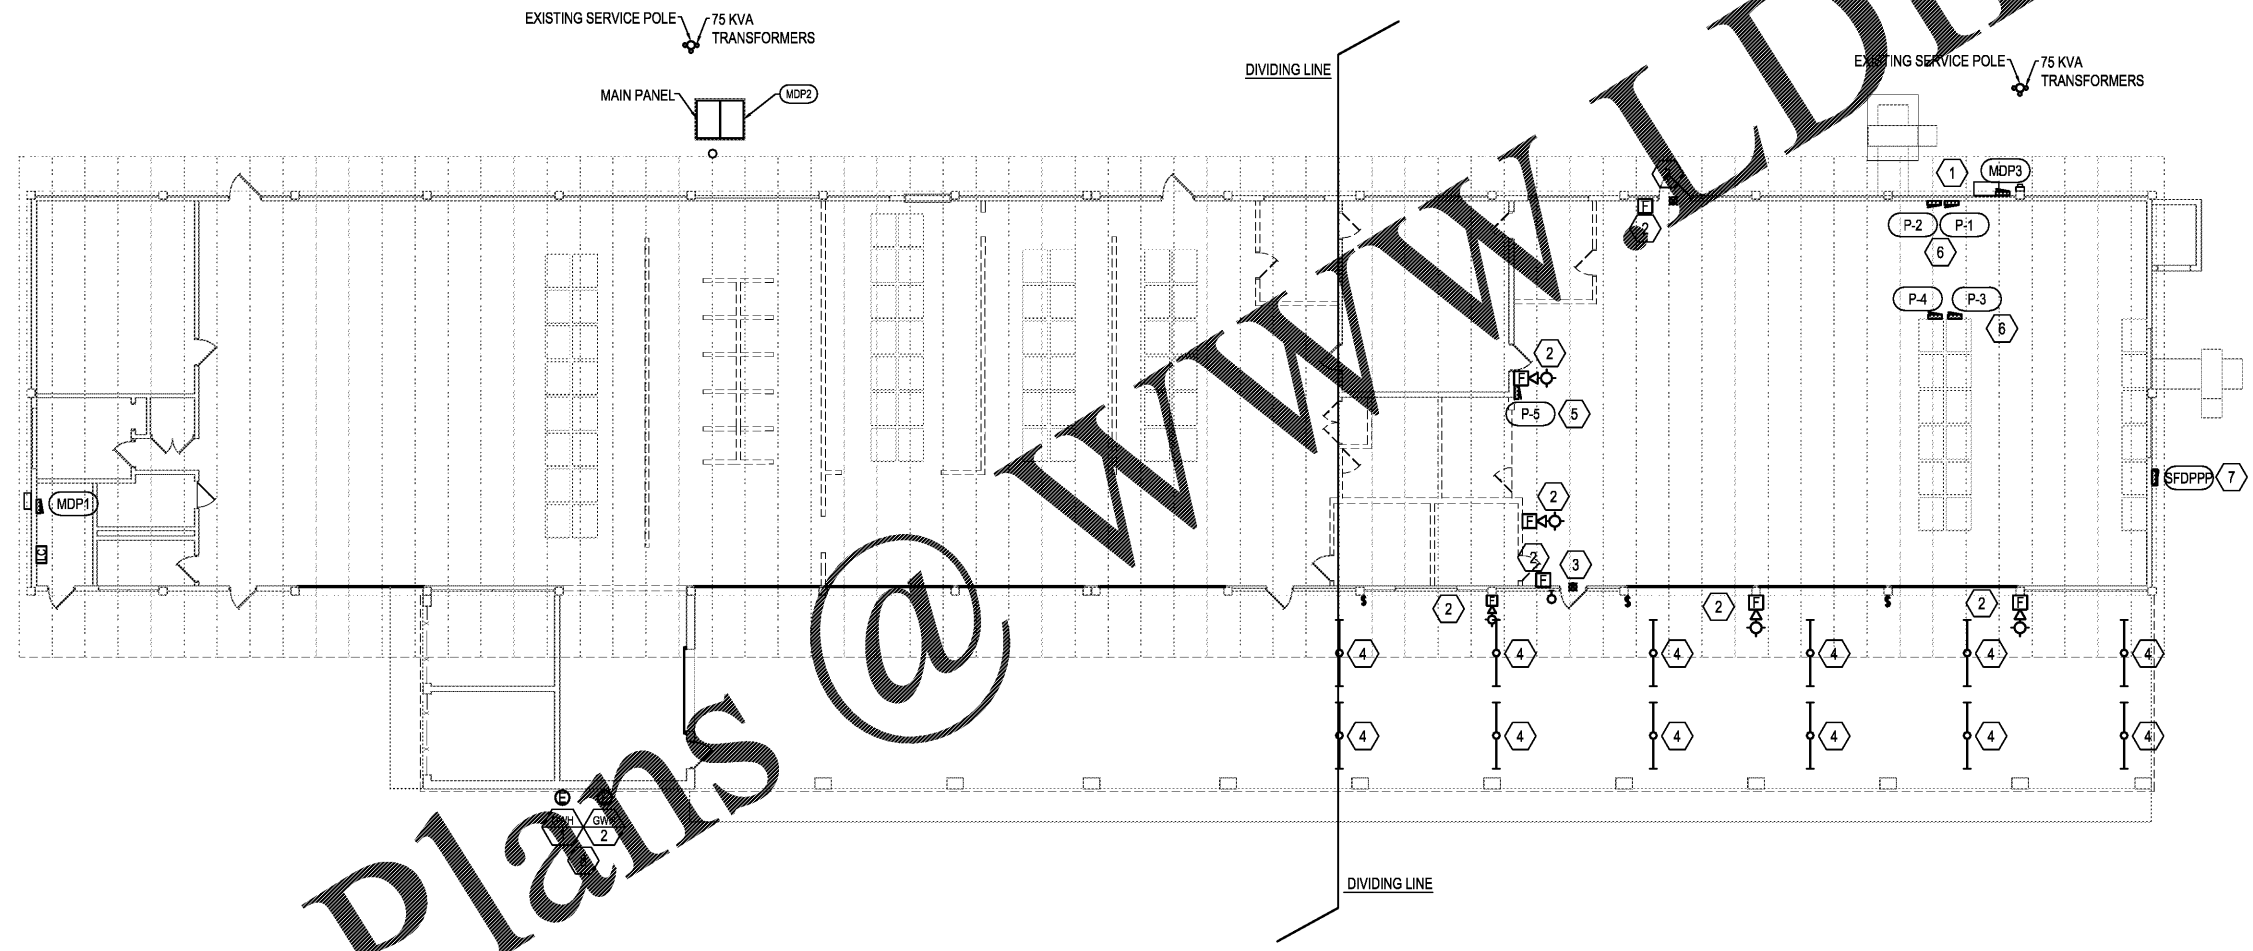

ISSUE	DATE
ISSUE FOR BID	12/19/2018

EXTERIOR DOORS, HARDWARE
 AND STOREFRONT REPLACEMENT
 MOBILE, ALABAMA

GMC NO. AMOB170029.004

DRAWN BY: ALS/GLH
 CHECKED BY: JCL



EXISTING SITE PLAN
 AND DEMOLITION PLAN
 PHASE II

E2.0
 sheet of

Order Plans @

WWW.DLINE.COM