


Order Plans

WWW.LDILINE.COM

WILSON AIR CENTER

NORTH TERMINAL

HCDT
 CHARLOTTE-DODD
 INTERNATIONAL AIRPORT
 5327 MERRILL FIELD DRIVE
 CHARLOTTE, NC 28203

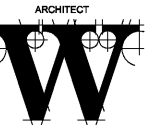

THE WILSON GROUP ARCHITECTS

PO BOX 5510 CHARLOTTE, NC 28209
 704-331-8747 • www.twgarchitects.com

**CIVIL ENGINEER
 TALBERT, BRIGHT &
 ELLINGTON**

3525 WHITEHALL PARK DRIVE, SUITE 210
 CHARLOTTE, NC 28273
 (704) 425-8070 FIRM NO.: C-1183

**STRUCTURAL ENGINEER
 STEWART**

101 N. TRYON ST., SUITE 1400
 CHARLOTTE, NC 28202
 (704) 889-3523 FIRM NO.: C-1051

**MECHANICAL, ELECTRICAL, PLUMBING &
 FIRE PROTECTION ENGINEER
 SABER ENGINEERING**

2923 S. TRYON ST., SUITE 280
 CHARLOTTE, NC 28203
 (704) 373-0068 FIRM NO.: C-2130

**LANDSCAPE ARCHITECT
 URBAN DESIGN PARTNERS**

1315-EE CENTRAL AVENUE
 CHARLOTTE, NC 28205
 (704) 334-3303 FIRM NO.: C-TBD

**COMMUNICATIONS INFRASTRUCTURE
 DB CONSULTING**


246 LOVES FARM ROAD
 BLACKSBURG, SC 29702
 (704) 497-7228 FIRM NO.: C-TBD

REVISIONS


DATE DECEMBER 7, 2018
 PROJECT NUMBER 9197-000

SHEET TITLE
WALL SECTIONS


SHEET NUMBER
A-362

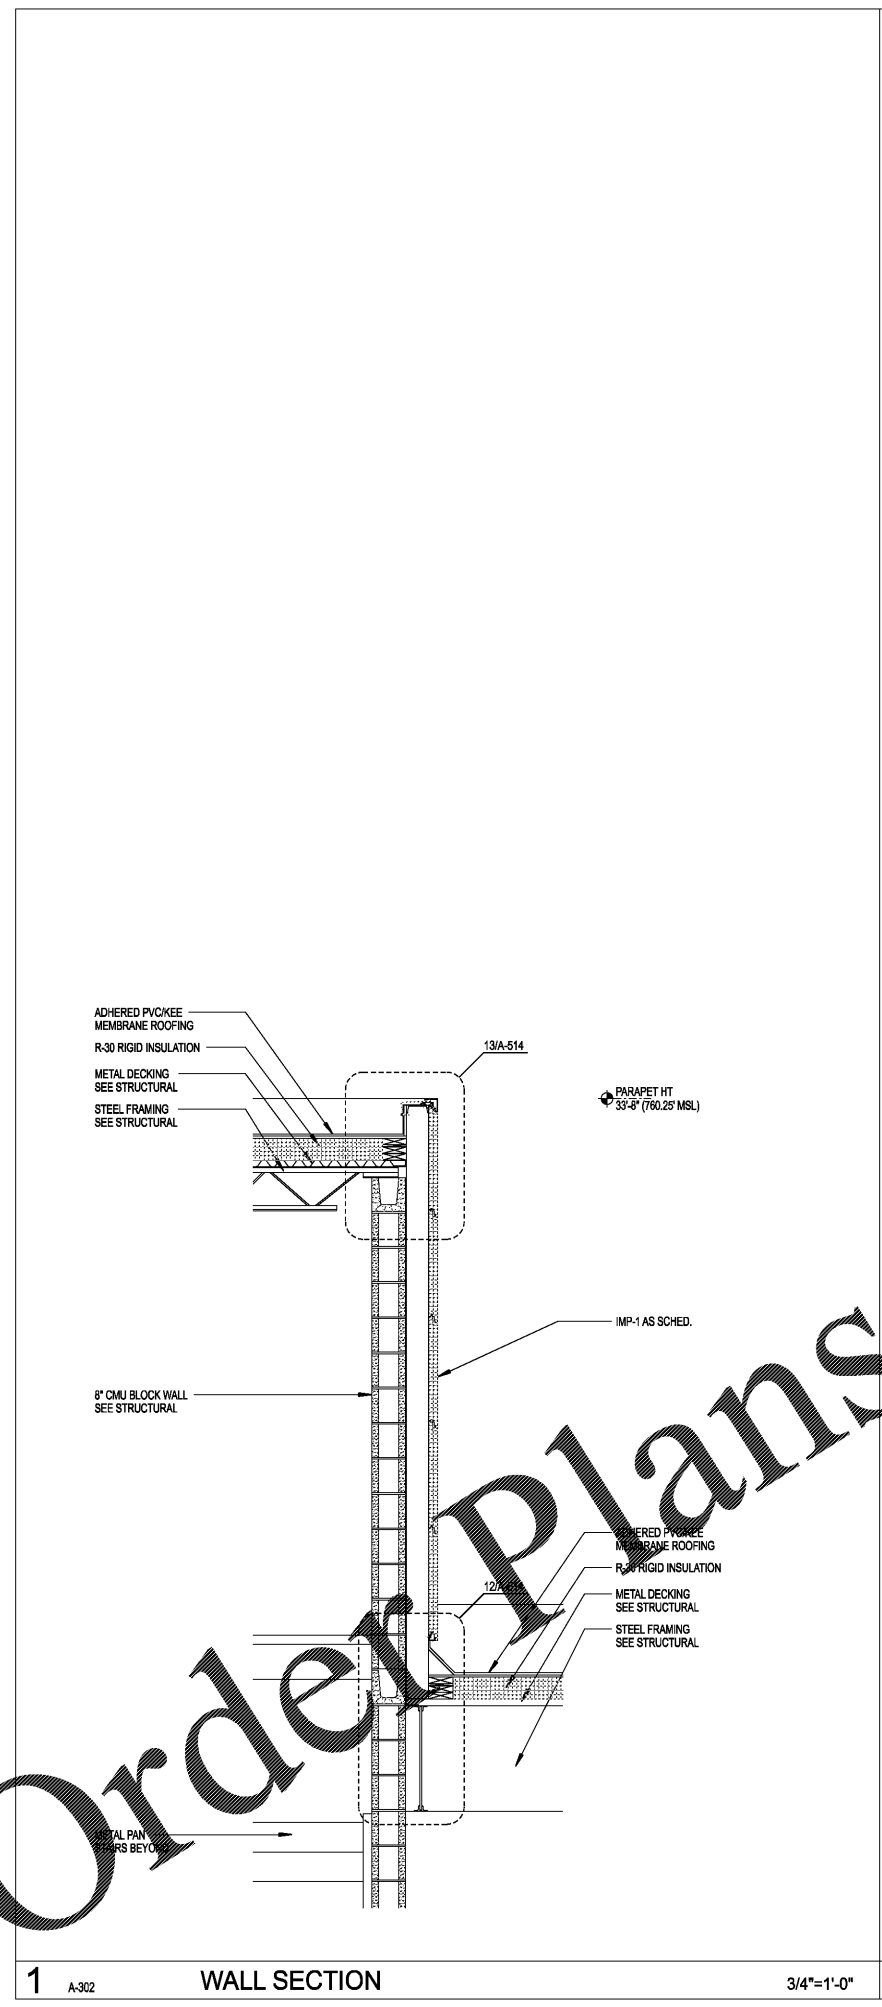

1 A-302 WALL SECTION 3/4"=1'-0"

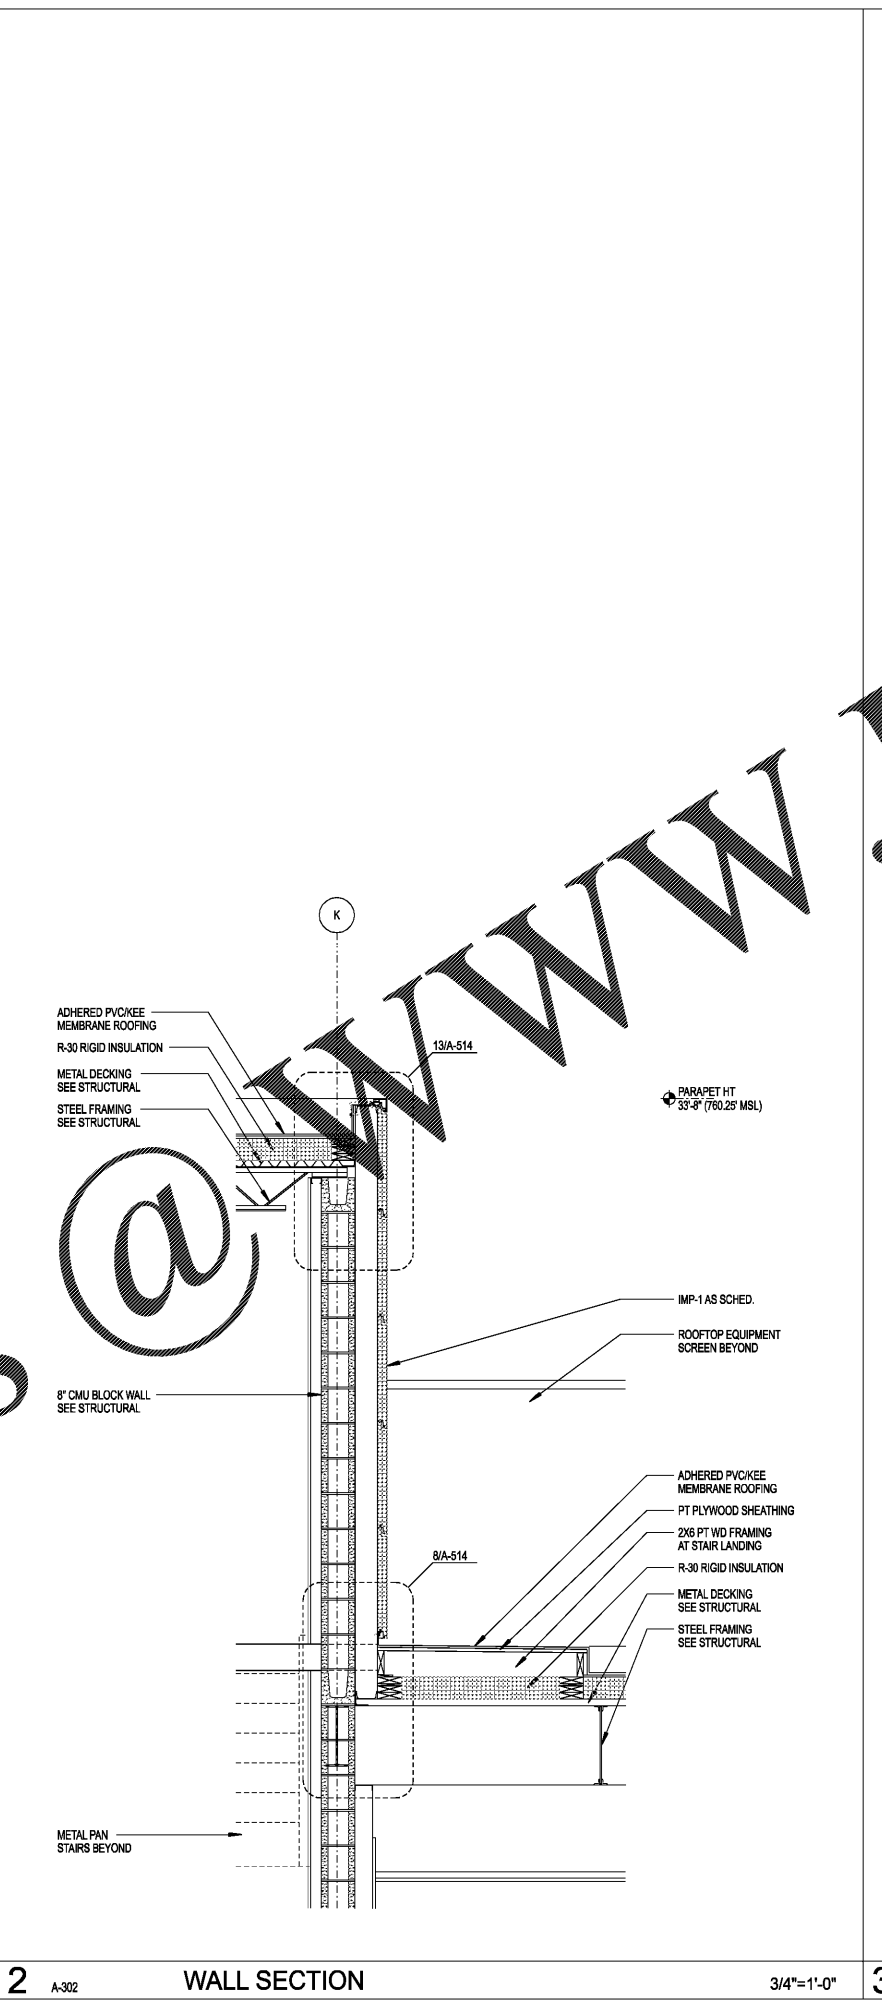

2 A-302 WALL SECTION 3/4"=1'-0"

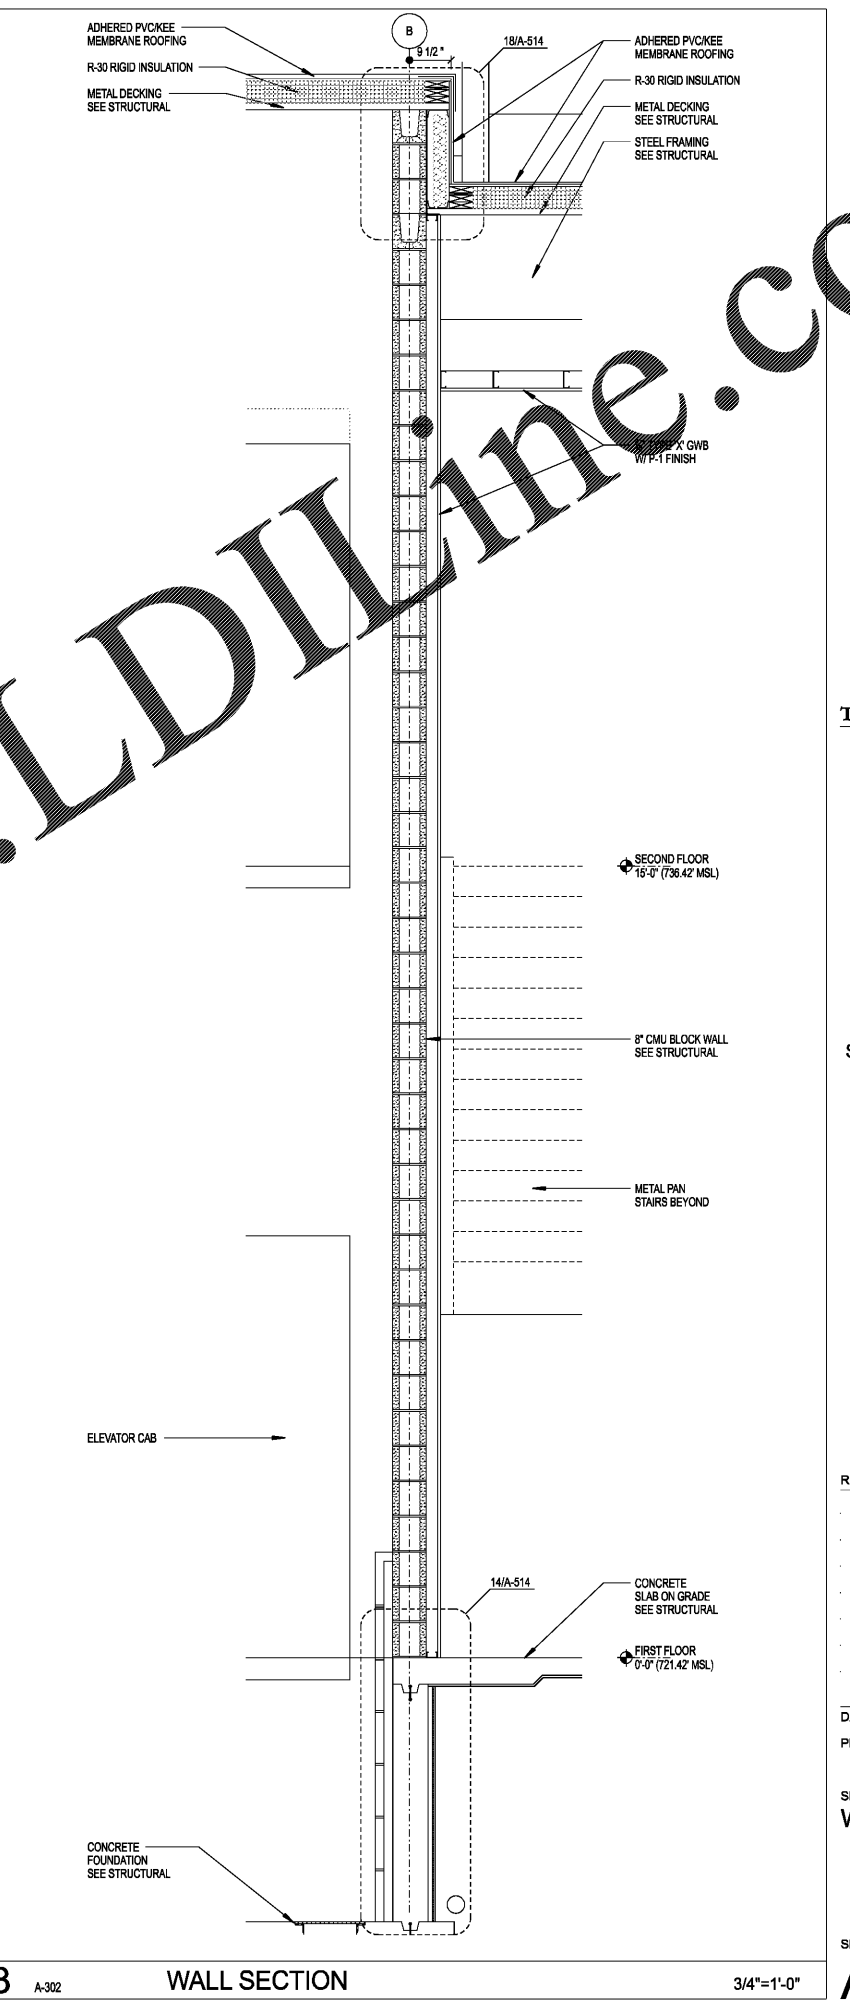

3 A-302 WALL SECTION 3/4"=1'-0"