


**WILSON AIR CENTER
NORTH TERMINAL**

HCDT
CHARLOTTE-DORRIS
INTERNATIONAL AIRPORT
5327 WOODS FIELD DRIVE
CHARLOTTE, NC 28203

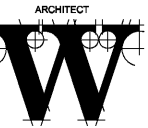

**THE WILSON GROUP
- ARCHITECTS -**

PO BOX 5510 CHARLOTTE, NC 28299
704-331-8747 • www.twgarchitects.com

CIVIL ENGINEER
**TALBERT, BRIGHT &
ELLINGTON**

3525 WHITEHALL PARK DRIVE, SUITE 210
CHARLOTTE, NC 28273
(704) 425-8070 FIRM NO.: C-1183

STRUCTURAL ENGINEER
STEWART

101 N. TRYON ST., SUITE 1400
CHARLOTTE, NC 28202
(704) 889-3523 FIRM NO.: C-1051

MECHANICAL, ELECTRICAL, PLUMBING &
FIRE PROTECTION ENGINEER
SABER ENGINEERING

2923 S. TRYON ST., SUITE 200
CHARLOTTE, NC 28203
(704) 373-0088 FIRM NO.: C-2130

LANDSCAPE ARCHITECT
**URBAN DESIGN
PARTNERS**

1315-EE CENTRAL AVENUE
CHARLOTTE, NC 28205
(704) 334-3303 FIRM NO.: C-TBD

COMMUNICATIONS INFRASTRUCTURE
DB CONSULTING

246 LOVEB FARM ROAD
BLACKSBURG, SC 29702
(704) 497-7228 FIRM NO.: C-TBD


REVISIONS

DATE DECEMBER 7, 2018
PROJECT NUMBER 9197-000

SHEET TITLE
**ENLARGED
LEVEL 1
EQUIPMENT
FLOOR PLAN**

SHEET NUMBER
A-453

| EQUIP. LEGEND | |
|---------------|-------------|
| SPEC. NO. | DESIGNATION |
| XXXXXX | XXXXXX |

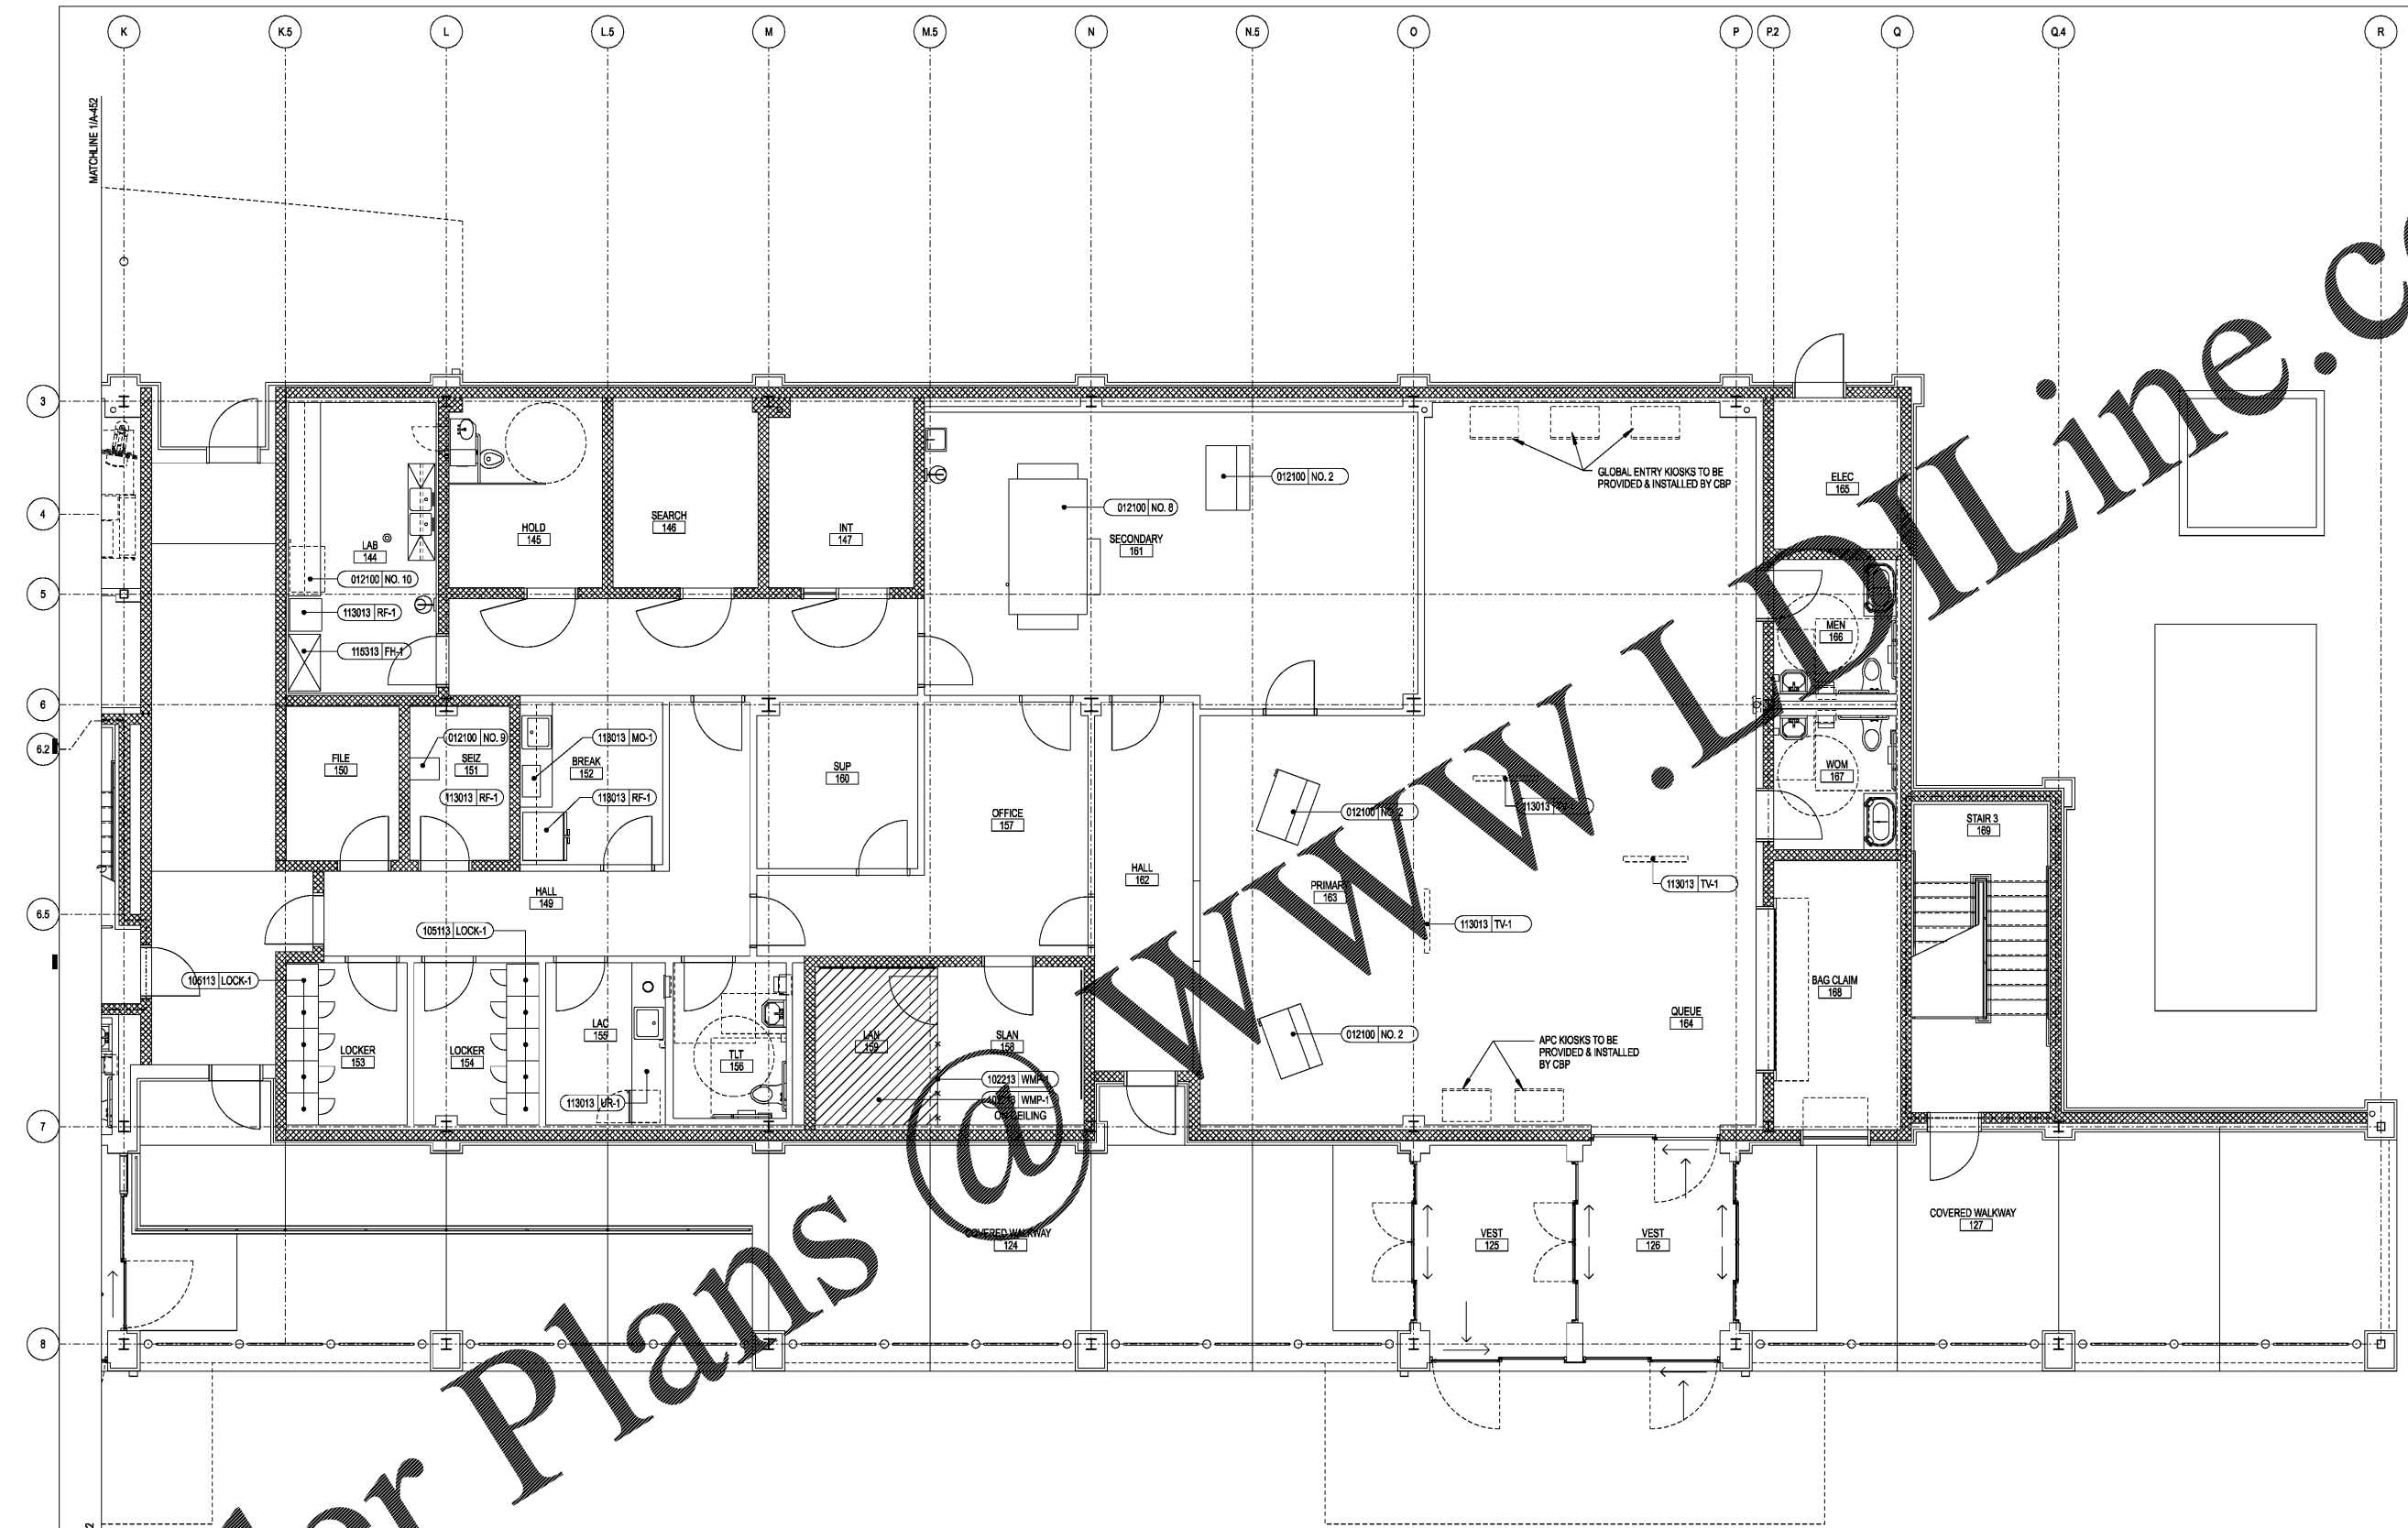

Order Plans

WWW.LDOnline.com