

WILSON AIR CENTER

NORTH TERMINAL

2923 South Tryon Street
Charlotte, North Carolina
tel 704.373.0088

MECHANICAL ELECTRICAL PLUMBING
DEC 7, 2018
PROJECT NUMBER = C-2130



ARCHITECT



THE WILSON GROUP
P O BOX 5510
CHARLOTTE, NC 28299
(704) 331-9747

CIVIL ENGINEER
TALBERT, BRIGHT & ELLINGTON
3525 WHITEHALL PARK DRIVE, SUITE 210
CHARLOTTE, NC 28273
(704) 426-6070 FIRM NO. C-1163

STRUCTURAL ENGINEER
STEWART
101 N. TRYON ST., SUITE 1400
CHARLOTTE, NC 28202
(704) 909-3523 FIRM NO. C-1051

MECHANICAL, ELECTRICAL, PLUMBING & FIRE PROTECTION ENGINEER
SABER ENGINEERING
2923 S. TRYON ST., SUITE 280
CHARLOTTE, NC 28203
(704) 373-0088 FIRM NO. C-2130

LANDSCAPE ARCHITECT
URBAN DESIGN PARTNERS
1318-E8 CENTRAL AVENUE
CHARLOTTE, NC 28205
(704) 334-3303 FIRM NO. C-130

COMMUNICATIONS INFRASTRUCTURE
DB CONSULTING
346 LONES FARM ROAD
BLACKSBURG, SC 29702
(704) 497-7228 FIRM NO. C-130


REVISIONS

Table with 2 columns: Description, Date. Contains 5 empty rows for revisions.


DATE DECEMBER 7, 2018
PROJECT NUMBER 9197-000

SHEET TITLE
ROOF PLAN

SHEET NUMBER
P-103

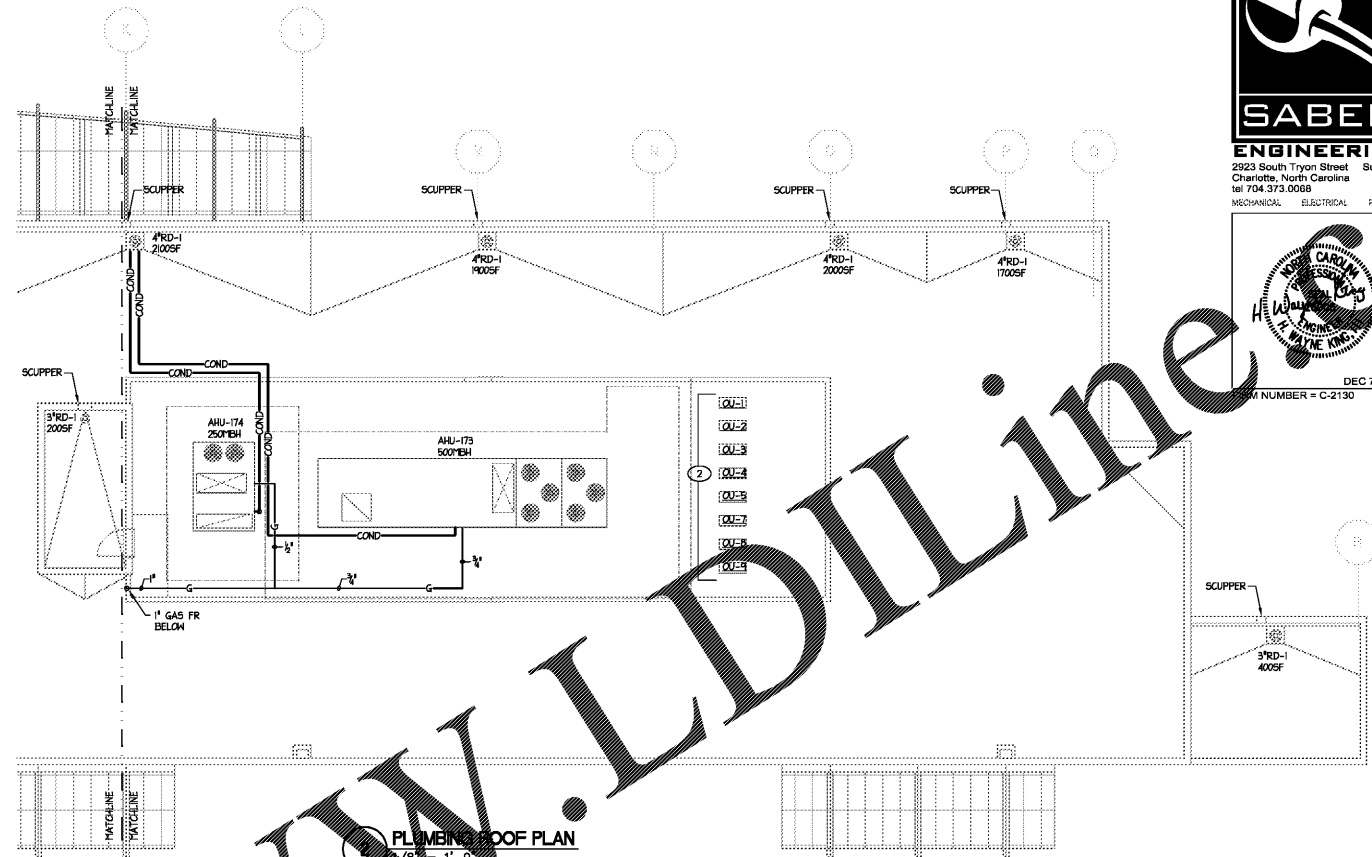


PLUMBING ROOF PLAN
1/8" = 1'-0"

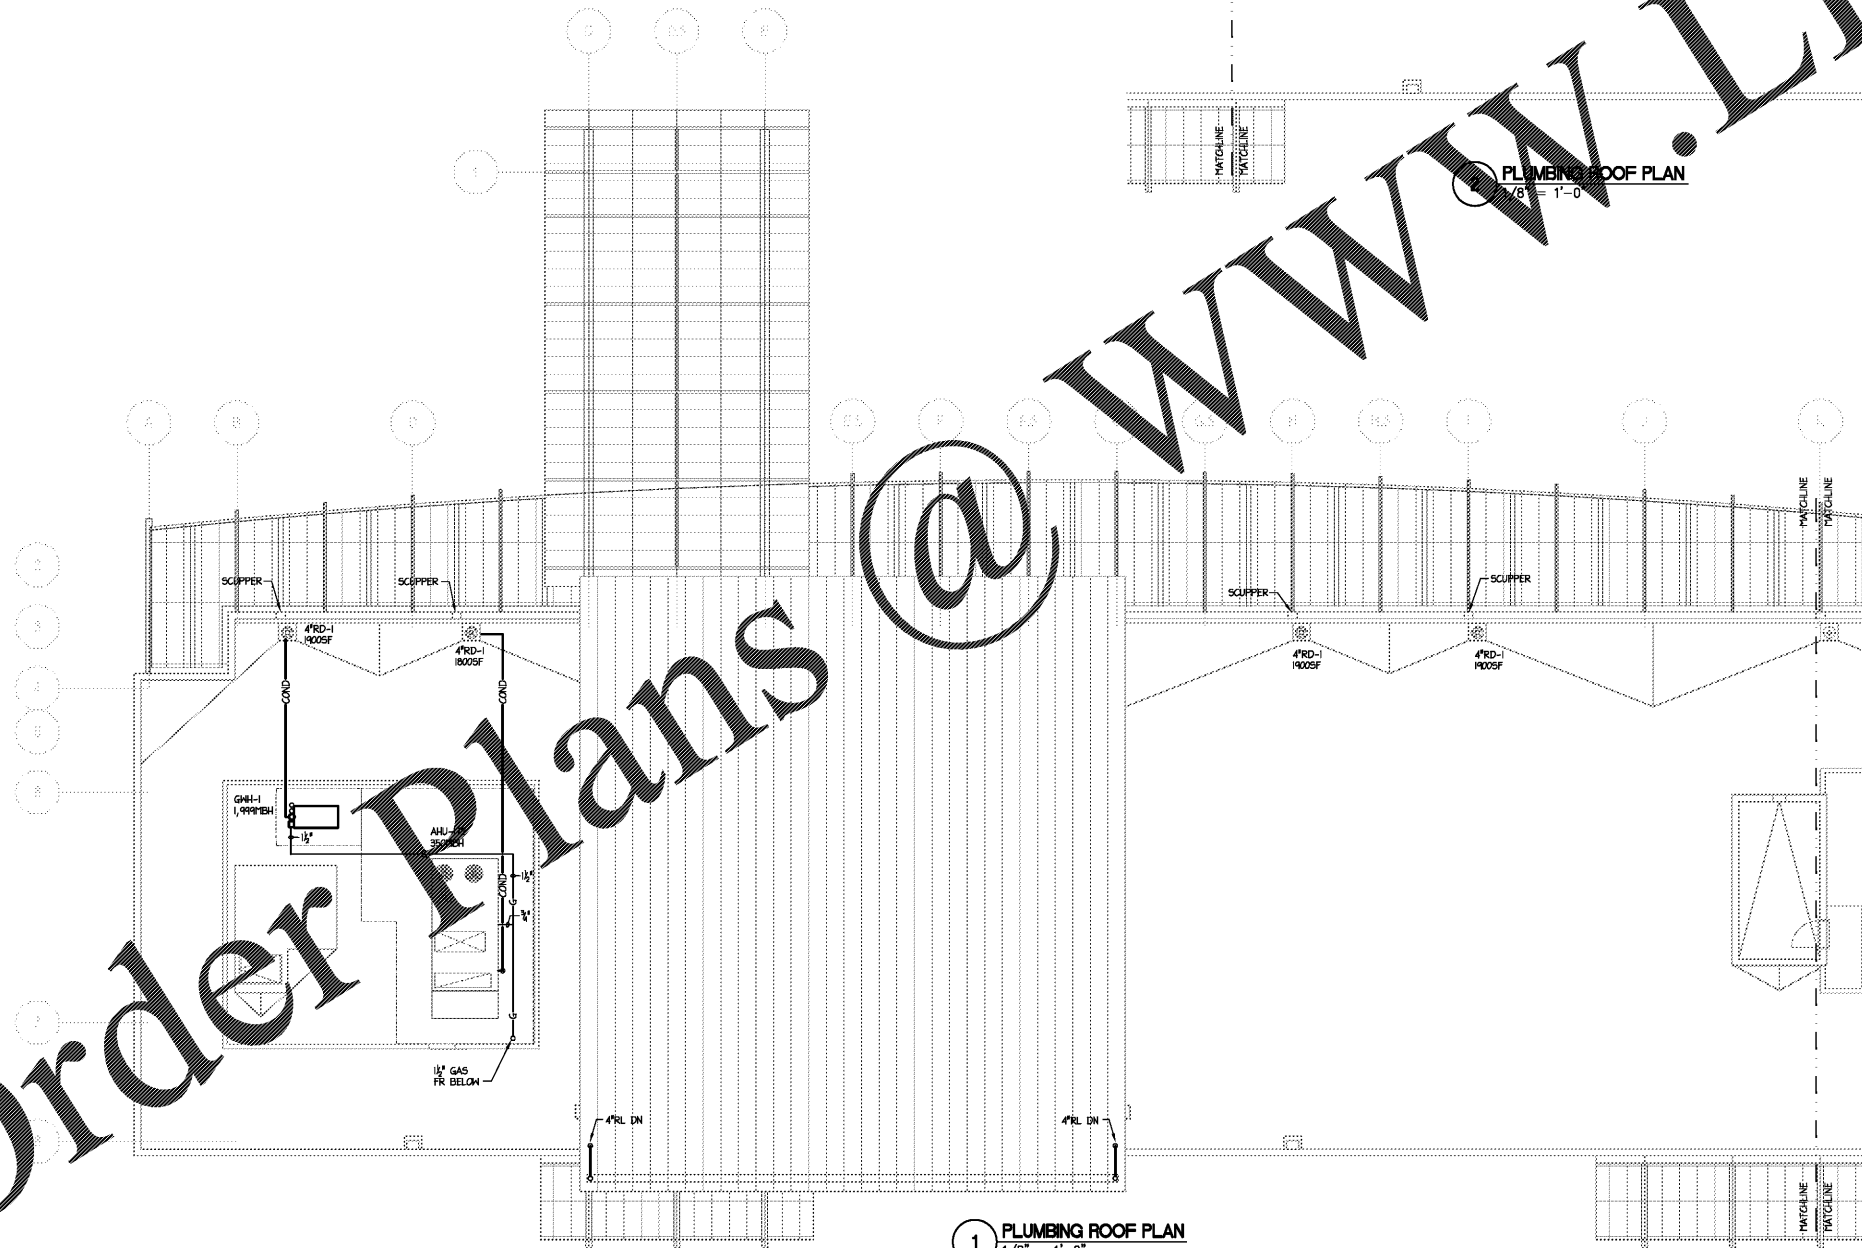

1 PLUMBING ROOF PLAN
1/8" = 1'-0"

NS-1710-P0103.dwg, Revised By: Sabber
Date: 12/27/18 - 8:26am

Order Plans @

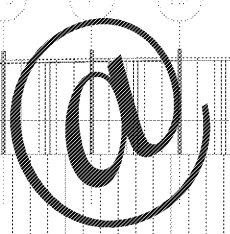

WWW.LDILine.com