


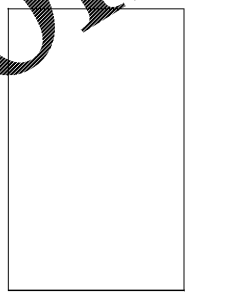

**SABER ENGINEERING**  
 2923 South Tryon Street Suite 280  
 Charlotte, North Carolina 28217  
 tel 704.373.0088  
 MECHANICAL ELECTRICAL PLUMBING  
 FIRE PROTECTION ENGINEERING  
 DEC 7, 2018  
 SHEET NUMBER = C-2130

**WILSON AIR CENTER  
 NORTH TERMINAL**

HCD 18-0018  
 CHARLOTTE-DOMESTIC  
 INTERNATIONAL AIRPORT  
 550 WOODRIS FIELD DRIVE  
 CHARLOTTE, NC 28208



ARCHITECT  
**THE WILSON GROUP**  
 P O BOX 5510  
 CHARLOTTE, NC 28299  
 (704) 331-9747

CIVIL ENGINEER  
**TALBERT, BRIGHT & ELLINGTON**  
 3525 WHITEHALL PARK DRIVE, SUITE 210  
 CHARLOTTE, NC 28273  
 (704) 426-8070 FIRM NO. C-1163

STRUCTURAL ENGINEER  
**STEWART**  
 101 N. TRYON ST., SUITE 1400  
 CHARLOTTE, NC 28202  
 (704) 909-3523 FIRM NO. C-1051

MECHANICAL, ELECTRICAL, PLUMBING &  
 FIRE PROTECTION ENGINEER  
**SABER ENGINEERING**  
 2923 S. TRYON ST., SUITE 280  
 CHARLOTTE, NC 28208  
 (704) 373-0088 FIRM NO. C-2130

LANDSCAPE ARCHITECT  
**URBAN DESIGN PARTNERS**  
 1318-E8 CENTRAL AVENUE  
 CHARLOTTE, NC 28205  
 (704) 334-3303 FIRM NO. C-TBD

COMMUNICATIONS INFRASTRUCTURE  
**DB CONSULTING**  
 248 LONES FARM ROAD  
 BLACKSBURG, SC 29702  
 (704) 497-7228 FIRM NO. C-TBD


REVISIONS

NO.	DATE	DESCRIPTION


DATE DECEMBER 7, 2018  
 PROJECT NUMBER 9197-000

SHEET TITLE  
**ROOF PLAN**

SHEET NUMBER  
**M-103**

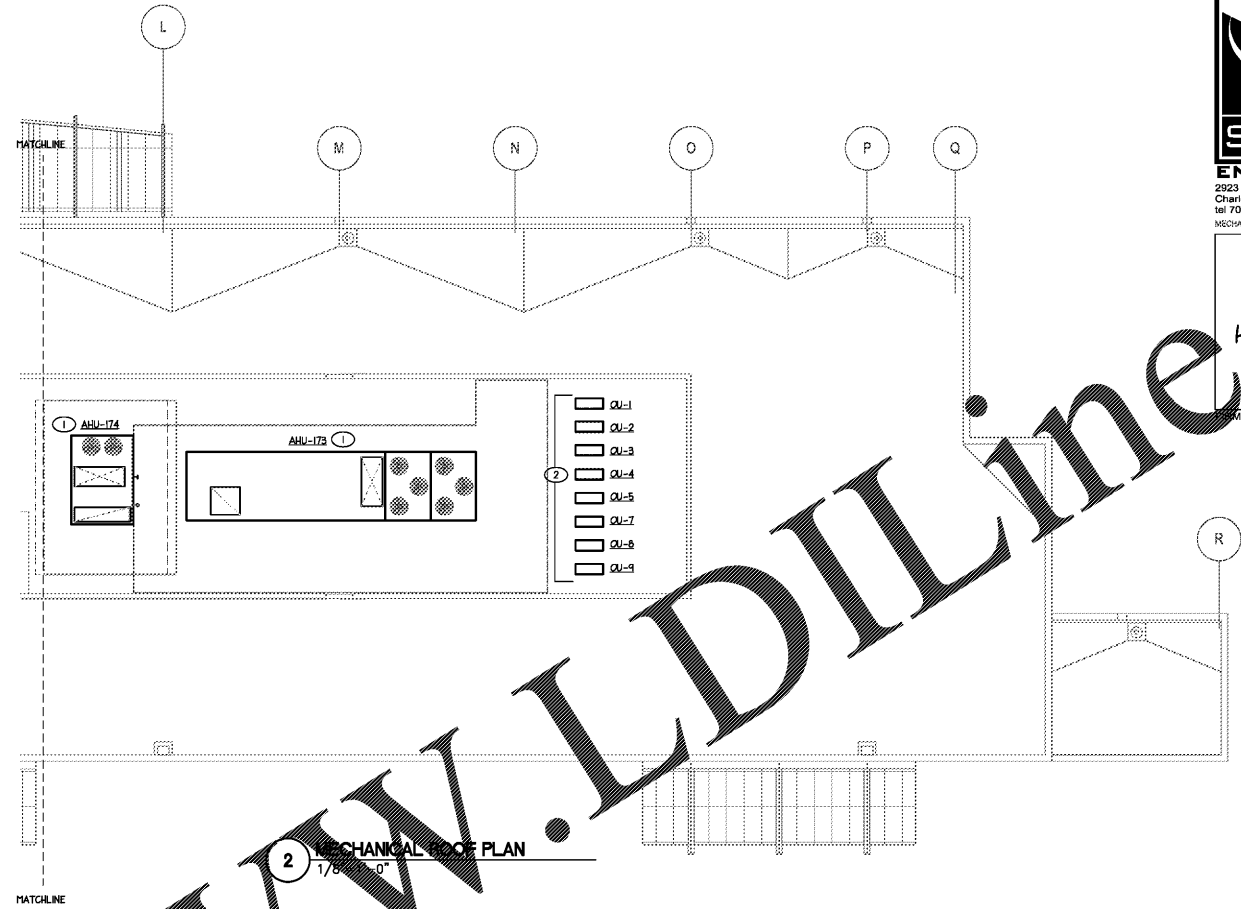

**2 MECHANICAL ROOF PLAN**  
 1/8"=1'-0"

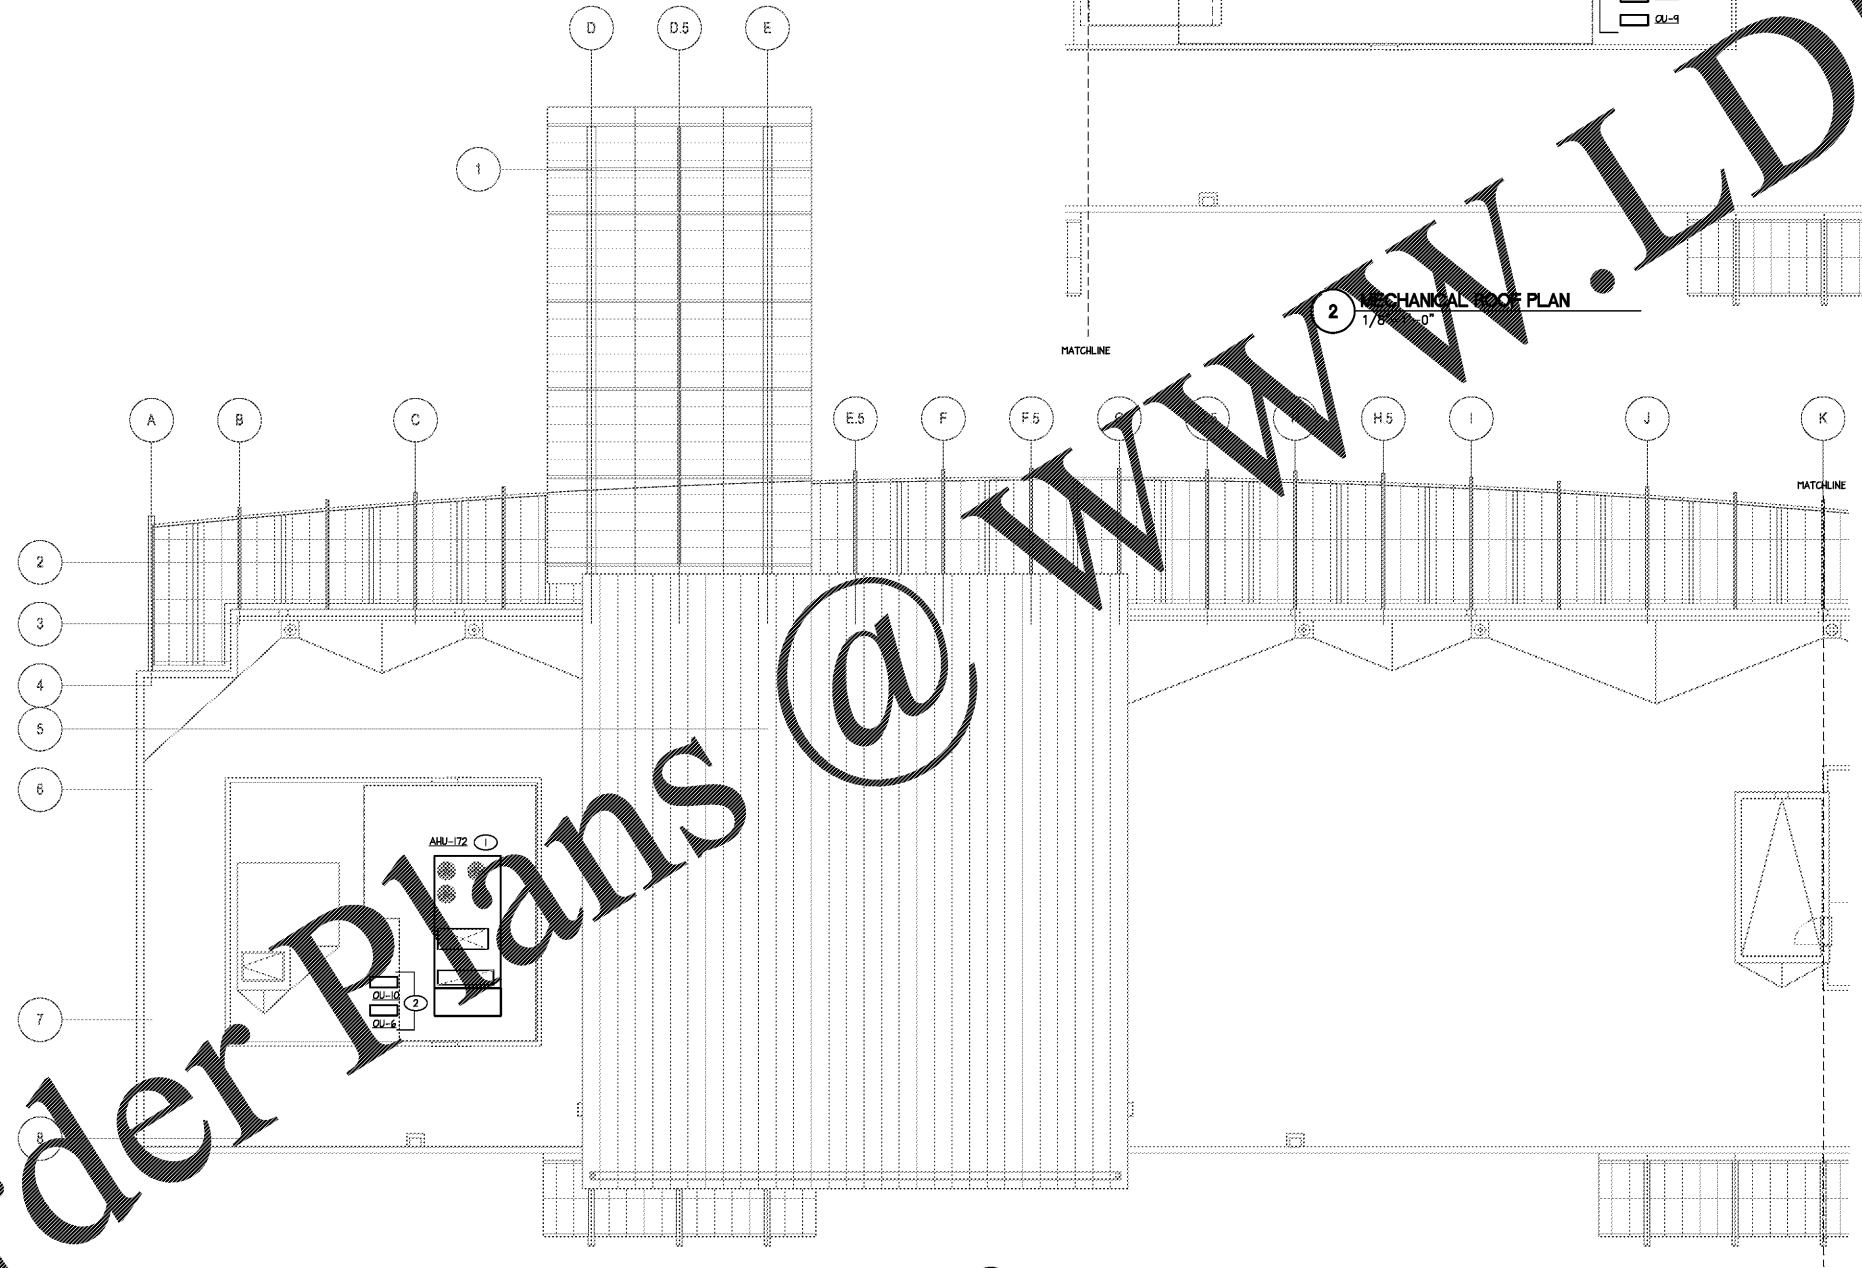

**1 MECHANICAL ROOF PLAN**  
 1/8"=1'-0"

**TAGGED NOTES - THIS SHEET**

- 1 RTU ON ROOF CURB. ROUTE CONDENSATE DRAIN LINE TO ROOF DRAIN. SEE PLUMBING ROOF PLAN FOR ROUTING.
- 2 QU UNITS ON ROOF VIBRATION ISOLATION PADS.

Order Plans @

WWW.LDILINE.COM