



SABER ENGINEERING
 2923 South Tryon Street Suite 280
 Charlotte, North Carolina 28203
 tel 704.373.0068




DEC 7, 2018
 NUMBER = C-2130

WILSON AIR CENTER

NORTH TERMINAL

HCDT FIRM
 CHARLOTTE, NC
 INTERNATIONAL AIRPORT
 CONRAD W. WALLACE
 CHARLOTTE, NC 28203

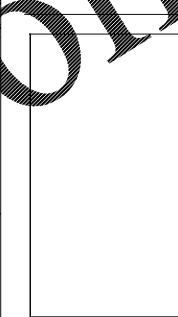

ARCHITECT



THE WILSON GROUP

P O BOX 5510
 CHARLOTTE, NC 28299
 (704) 331-9747

CIVIL ENGINEER
TALBERT, BRIGHT & ELLINGTON

3525 WHITEHALL PARK DRIVE, SUITE 210
 CHARLOTTE, NC 28273
 (704) 426-6070 FIRM NO. C-1163

STRUCTURAL ENGINEER

STEWART
 101 N. TRYON ST., SUITE 1400
 CHARLOTTE, NC 28202
 (704) 909-3523 FIRM NO. C-1051

MECHANICAL, ELECTRICAL, PLUMBING & FIRE PROTECTION ENGINEER

SABER ENGINEERING
 2923 S. TRYON ST., SUITE 280
 CHARLOTTE, NC 28203
 (704) 373-0068 FIRM NO. C-2130

LANDSCAPE ARCHITECT

URBAN DESIGN PARTNERS
 1318-66 CENTRAL AVENUE
 CHARLOTTE, NC 28205
 (704) 394-3303 FIRM NO. C-TBD

COMMUNICATIONS INFRASTRUCTURE

DB CONSULTING
 246 LONES FARM ROAD
 BLACKSBURG, SC 29702
 (704) 497-7228 FIRM NO. C-TBD

REVISIONS

DATE DECEMBER 7, 2018


PROJECT NUMBER 9197-000

SHEET TITLE


EXTERIOR ELEVATIONS LIGHTING PLANS

SHEET NUMBER


E-204L

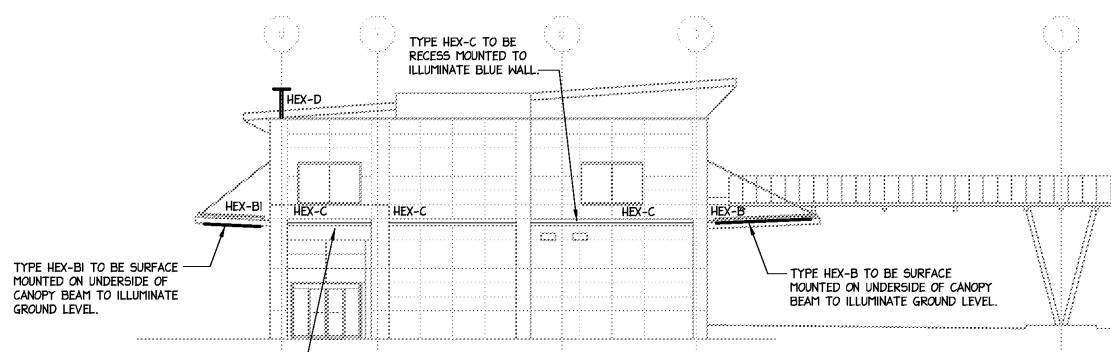


1 EAST ELEVATION
 1"=10'

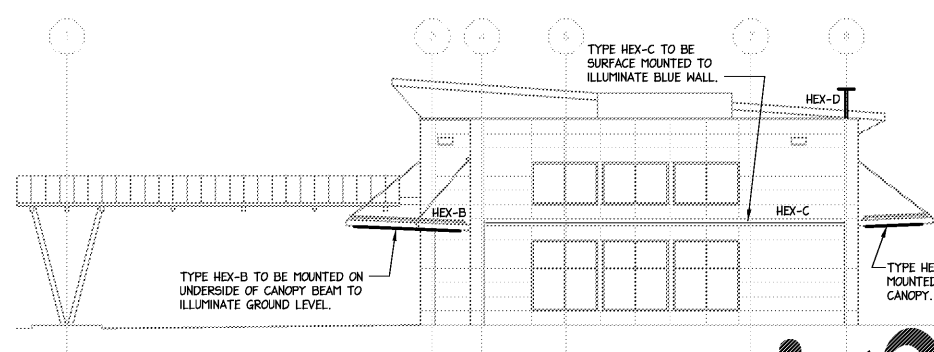

2 WEST ELEVATION
 1"=10'

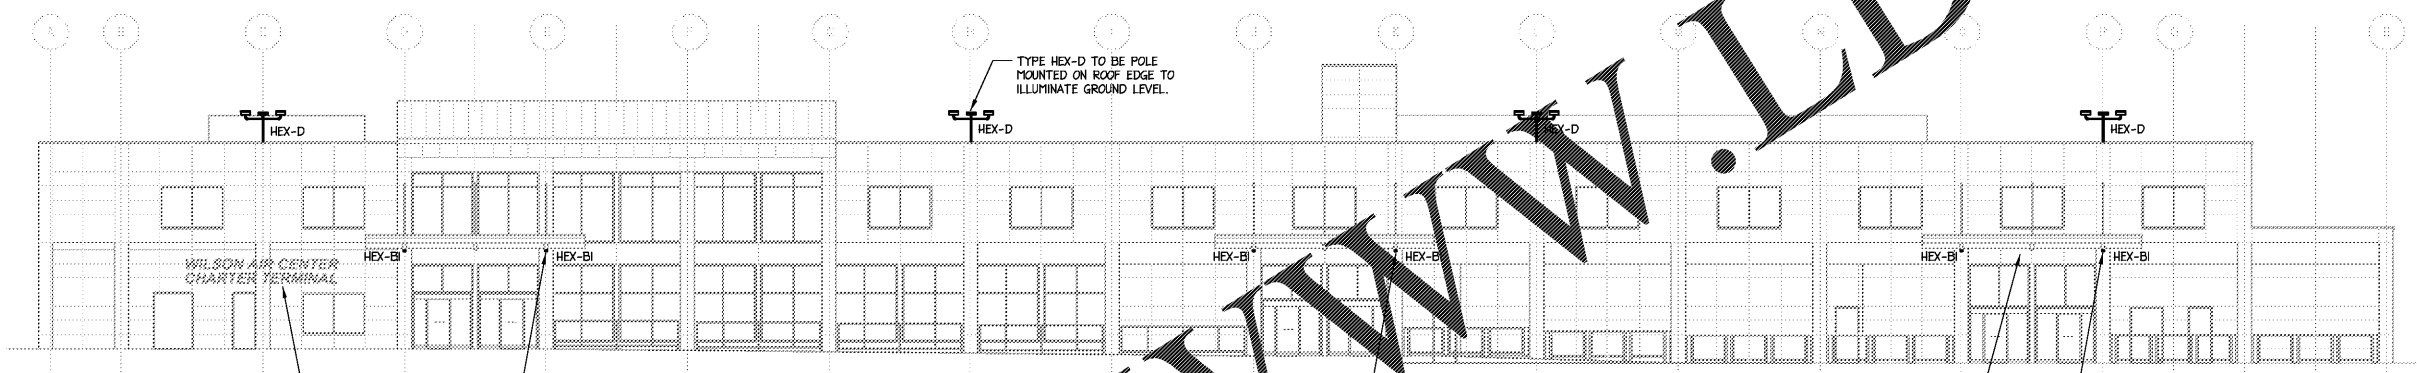

3 SOUTH ELEVATION
 1"=10'

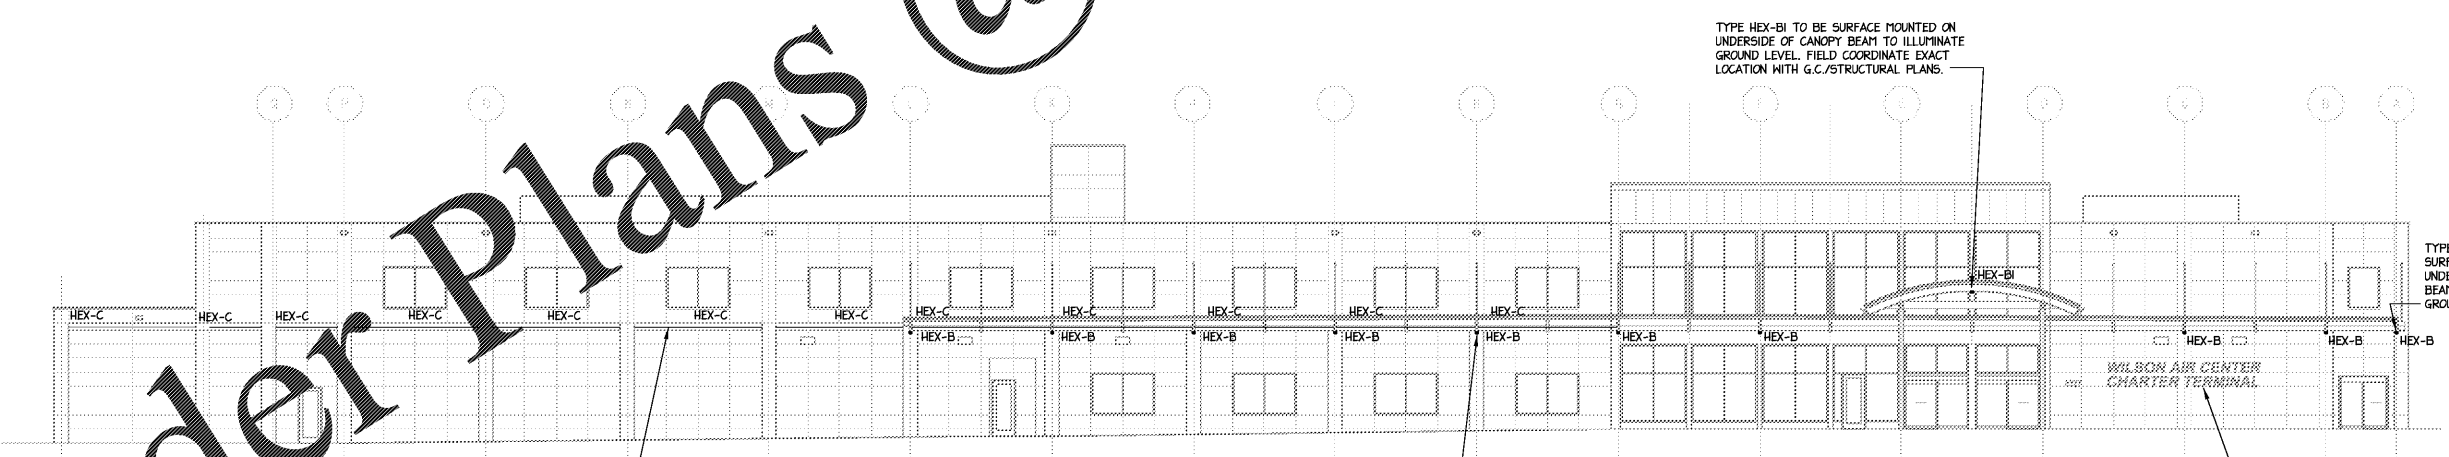

4 NORTH ELEVATION
 1"=10'

Order Plans @ www.LDILine.com