


**NOTES:**

1. PRIOR TO STARTING ANY UNDERGROUND SERVICE WORK, THE CONTRACTOR SHALL CONTACT THE LOCAL ELECTRICAL UTILITY SERVICE REPRESENTATIVE AND COORDINATE REQUIREMENTS FOR THE TRANSFORMER LOCATION, CONCRETE PAD REQUIREMENTS, PRIMARY SURGE ARRESTORS, SECONDARY CONDUIT AND WIRE AND METERING REQUIREMENTS. ALL WORK AND ANY COST RELATIVE TO THE ABOVE THAT IS THE CONTRACTOR'S RESPONSIBILITY SHALL BE INCLUDED AS PART OF THIS CONTRACT.

2. ELECTRICAL CONTRACTOR SHALL COORDINATE WITH LOCAL TELEPHONE COMPANY TO PROVIDE A COMPLETE UNDERGROUND SERVICE INSTALLATION INTO THE BUILDING. ELECTRICAL CONTRACTOR SHALL PROVIDE (4) 4" CONDUITS WITH PULL CORDS FROM THE TELEPHONE BACKBOARD INSIDE THE BUILDING TO THE MANHOLE ON SITE OR AS DIRECTED BY THE LOCAL TELEPHONE COMPANY REPRESENTATIVE.

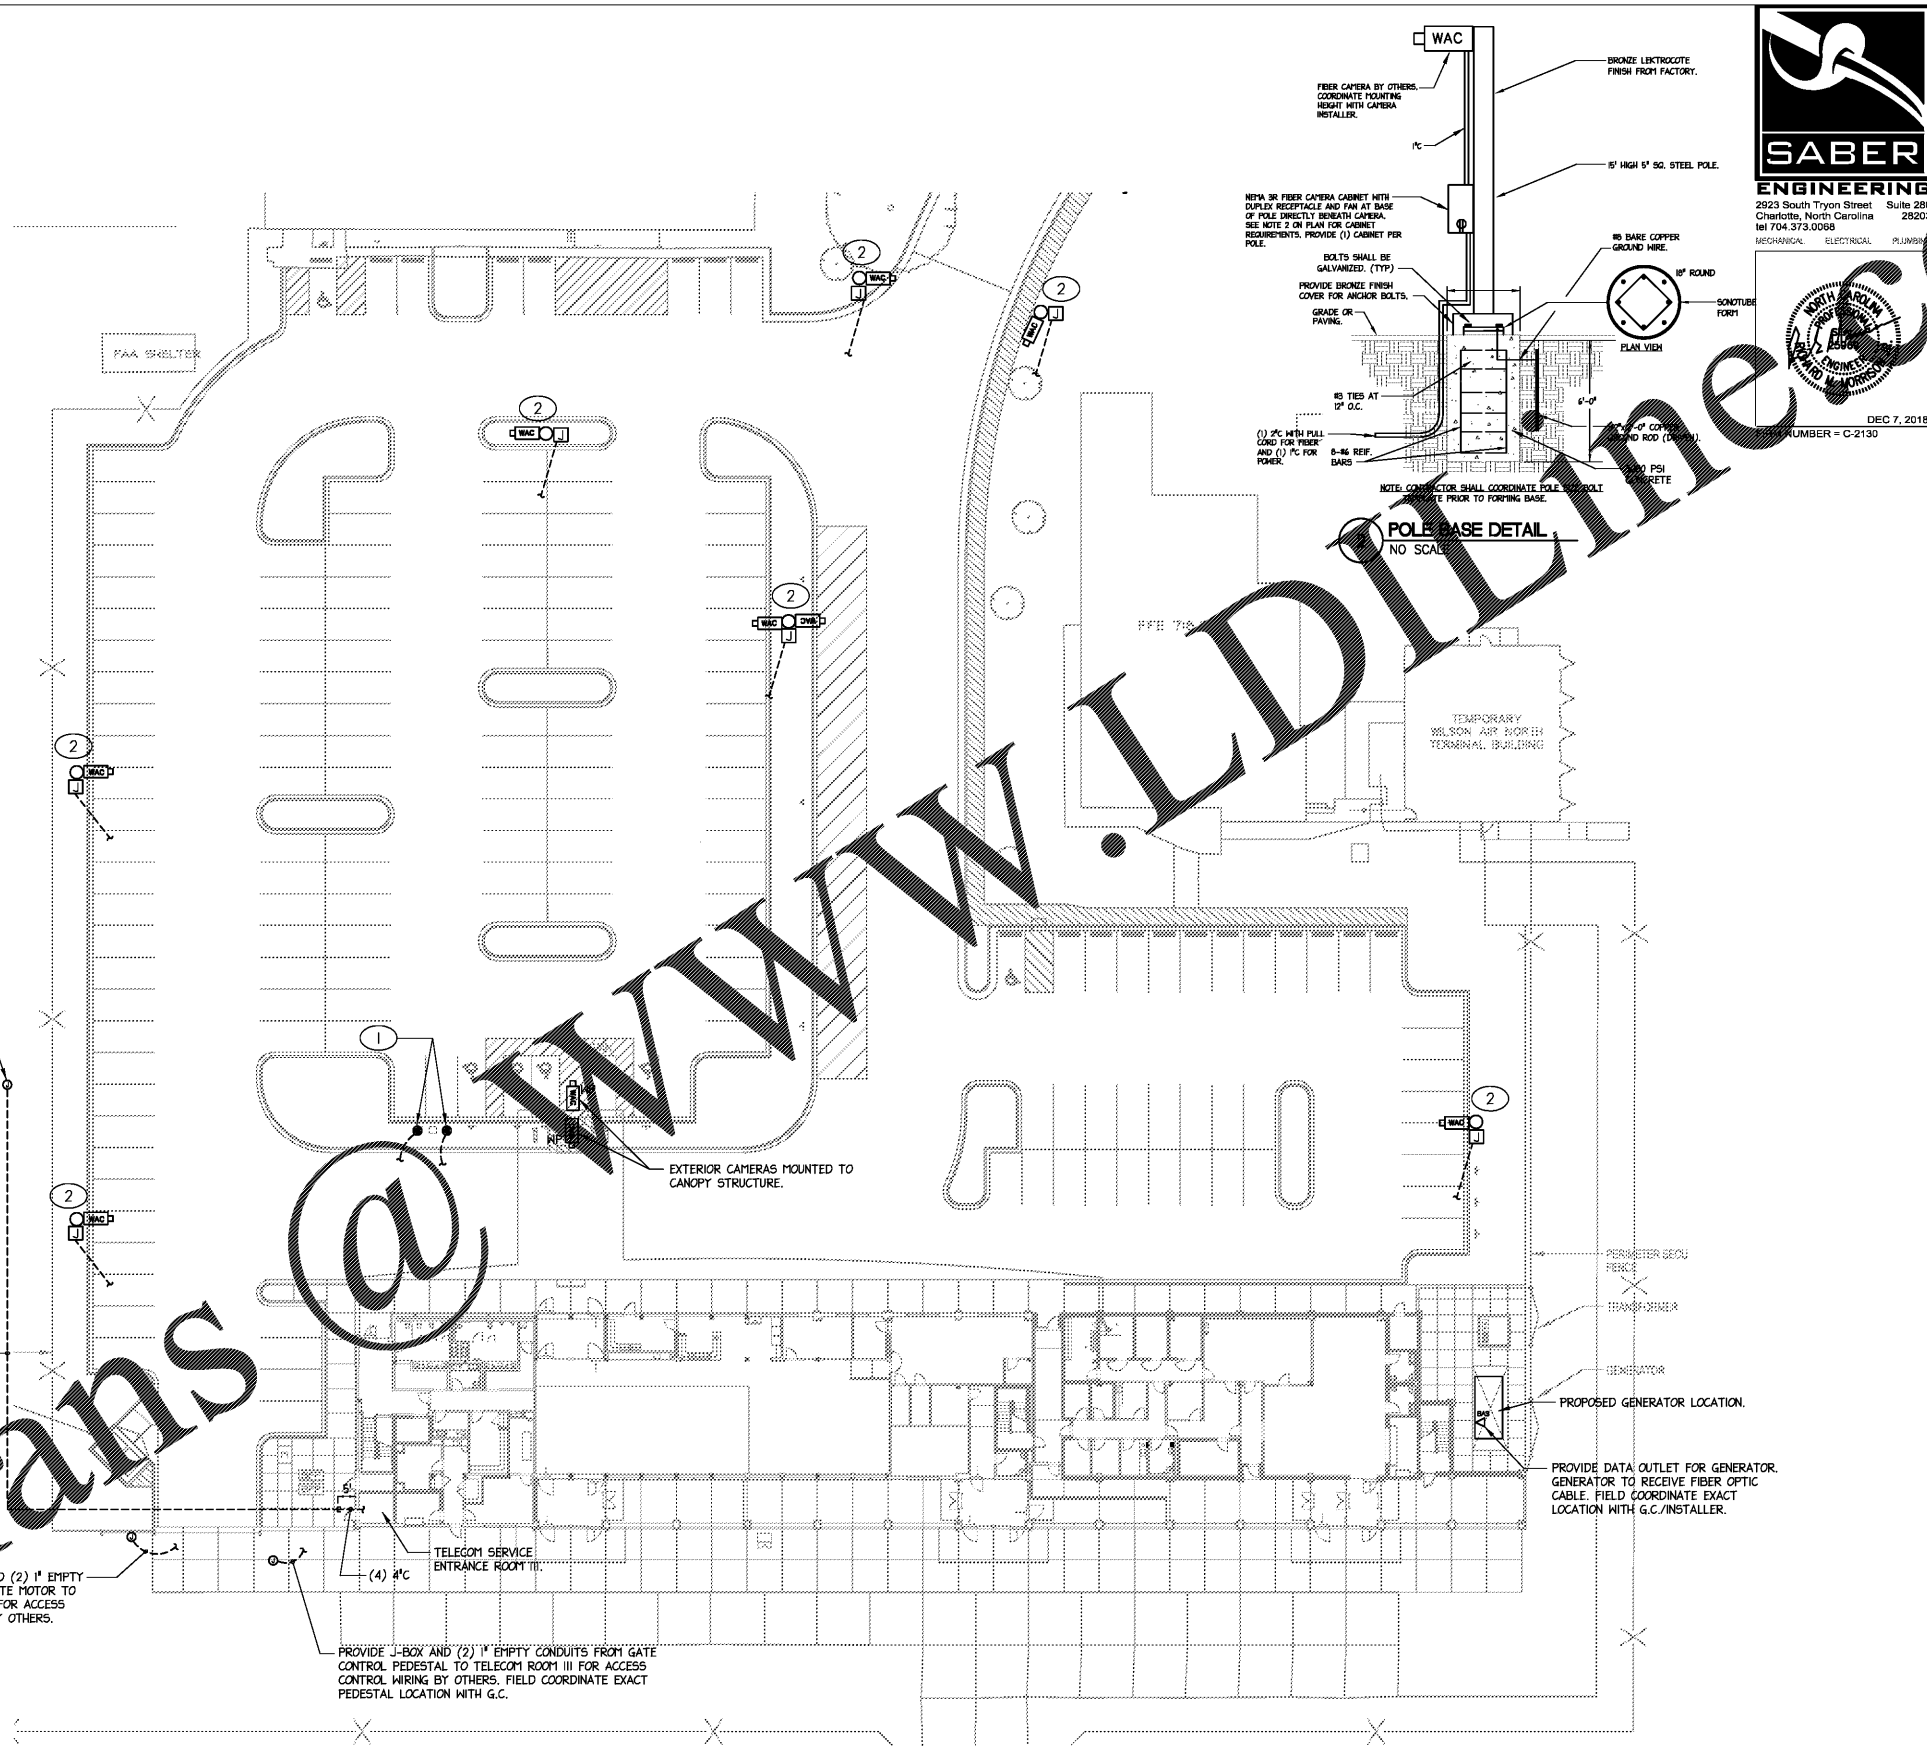


**NOTES:**

- ① ELECTRIC CAR CHARGING PEDESTAL. PROVIDE (1) EMPTY 1" PVC CONDUIT TO TELECOM ROOM 139 FOR DATA.
- ② PROVIDE 15' POLE AS MANUFACTURED BY PELCO PRODUCTS INC WITH THE FOLLOWING PART #S PB-5100, PB-5334, SP-1009-NC FOR SECURITY CAMERA BY OTHERS. PROVIDE POLE BASE PER DETAIL. NEMA 3R ENCLOSURE SHALL BE HOFFMAN/PROTEK SERIES 24"x24"x12" MINIMUM WITH INTEGRAL SOLAR SHADE, 6" FAN, AND PLYWOOD INTERIOR BACKBOARD MOUNTED TO POLE. PROVIDE 120V/20A CIRCUIT TO HOFFMAN BOX AS INDICATED. PROVIDE EMPTY 2" WITH PULL CORD BACK TO TELECOM ROOM III AS REQUIRED FOR FIBER OPTIC CABLE BY OTHERS.

① SITE LOW VOLTAGE PLAN  
1"=20'




2923 South Tryon Street Suite 280  
Charlotte, North Carolina 28203  
Tel 704.373.0088

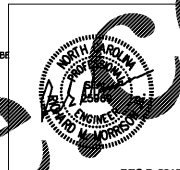

MECHANICAL, ELECTRICAL, PLUMBING  
NUMBER = C-2130  
DEC 7, 2018

**WILSON AIR CENTER  
NORTH TERMINAL**

HDDT F...  
CHARLOTTE, NC 28208

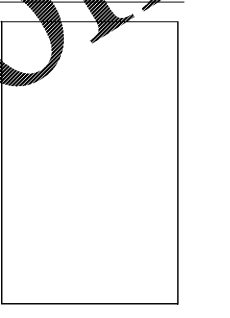

ARCHITECT  
**THE WILSON GROUP**  
P O BOX 5510  
CHARLOTTE, NC 28209  
(704) 551-5747

CIVIL ENGINEER  
**TALBERT, BRIGHT & ELLINGTON**  
3525 WHITEHALL PARK DRIVE, SUITE 210  
CHARLOTTE, NC 28275  
(704) 428-6070 FIRM NO. C-1183

STRUCTURAL ENGINEER  
**STEWART**  
101 N. TRYON ST., SUITE 1400  
CHARLOTTE, NC 28202  
(704) 909-3523 FIRM NO. C-1051

MECHANICAL, ELECTRICAL, PLUMBING & FIRE PROTECTION ENGINEER  
**SABER ENGINEERING**  
2923 S. TRYON ST., SUITE 280  
CHARLOTTE, NC 28203  
(704) 373-0088 FIRM NO. C-2130

LANDSCAPE ARCHITECT  
**URBAN DESIGN PARTNERS**  
1318-ES CENTRAL AVENUE  
CHARLOTTE, NC 28205  
(704) 334-3303 FIRM NO. C-118D

COMMUNICATIONS INFRASTRUCTURE  
**DB CONSULTING**  
246 LOVES FARM ROAD  
BLACKSBURG, VA 22602  
(704) 487-7228 FIRM NO. C-118D

**REVISIONS**

| NO. | DESCRIPTION |
|-----|-------------|
|     |             |
|     |             |
|     |             |
|     |             |

DATE: DECEMBER 7, 2018  
PROJECT NUMBER: 9197-000

SHEET TITLE: **SITE PLAN**

SHEET NUMBER: **LV-200**

Order Plans @