





SABER ENGINEERING
 2923 South Tryon Street Suite 280
 Charlotte, North Carolina 28203
 tel 704.373.0069



DEC 7, 2018
 SHEET NUMBER = C-2130

**WILSON AIR CENTER
 NORTH TERMINAL**

HCD 00018
 CHARLOTTE-MAS
 INTERNATIONAL AIRPORT
 5301 WILSONS FIELD ROAD
 CHARLOTTE, NC 28208

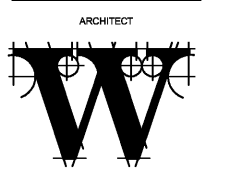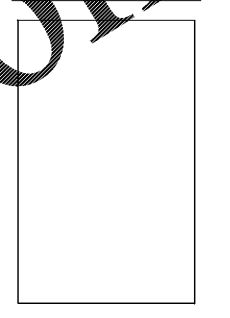

ARCHITECT
THE WILSON GROUP
 P. O. BOX 5510
 CHARLOTTE, NC 28299
 (704) 351-9747

CIVIL ENGINEER
**TALBERT, BRIGHT &
 ELLINGTON**
 3025 WHITEHALL PARK DRIVE, SUITE 210
 CHARLOTTE, NC 28273
 (704) 426-6070 FIRM NO. C-1163

STRUCTURAL ENGINEER
STEWART
 101 N. TRYON ST., SUITE 1400
 CHARLOTTE, NC 28202
 (704) 909-3523 FIRM NO. C-1051

MECHANICAL, ELECTRICAL, PLUMBING &
 FIRE PROTECTION ENGINEER
SABER ENGINEERING
 2923 S. TRYON ST., SUITE 280
 CHARLOTTE, NC 28203
 (704) 373-0069 FIRM NO. C-2130

LANDSCAPE ARCHITECT
URBAN DESIGN PARTNERS
 1318-68 CENTRAL AVENUE
 CHARLOTTE, NC 28205
 (704) 334-3333 FIRM NO. C-18D

COMMUNICATIONS INFRASTRUCTURE
DB CONSULTING
 246 LOVES FARM ROAD
 BLACKSBURG, SC 29702
 (704) 497-7228 FIRM NO. C-18D


REVISIONS

DATE DECEMBER 7, 2018
 PROJECT NUMBER 9197-000

SHEET TITLE
ROOF PLANS

SHEET NUMBER
LV-203

NOTES:
 1 PROVIDE DATA OUTLET AT ROOF TOP UNIT. FIELD COORDINATE EXACT LOCATION AND INSTALLATION REQUIREMENTS WITH G.C./LOW VOLTAGE VENDOR.

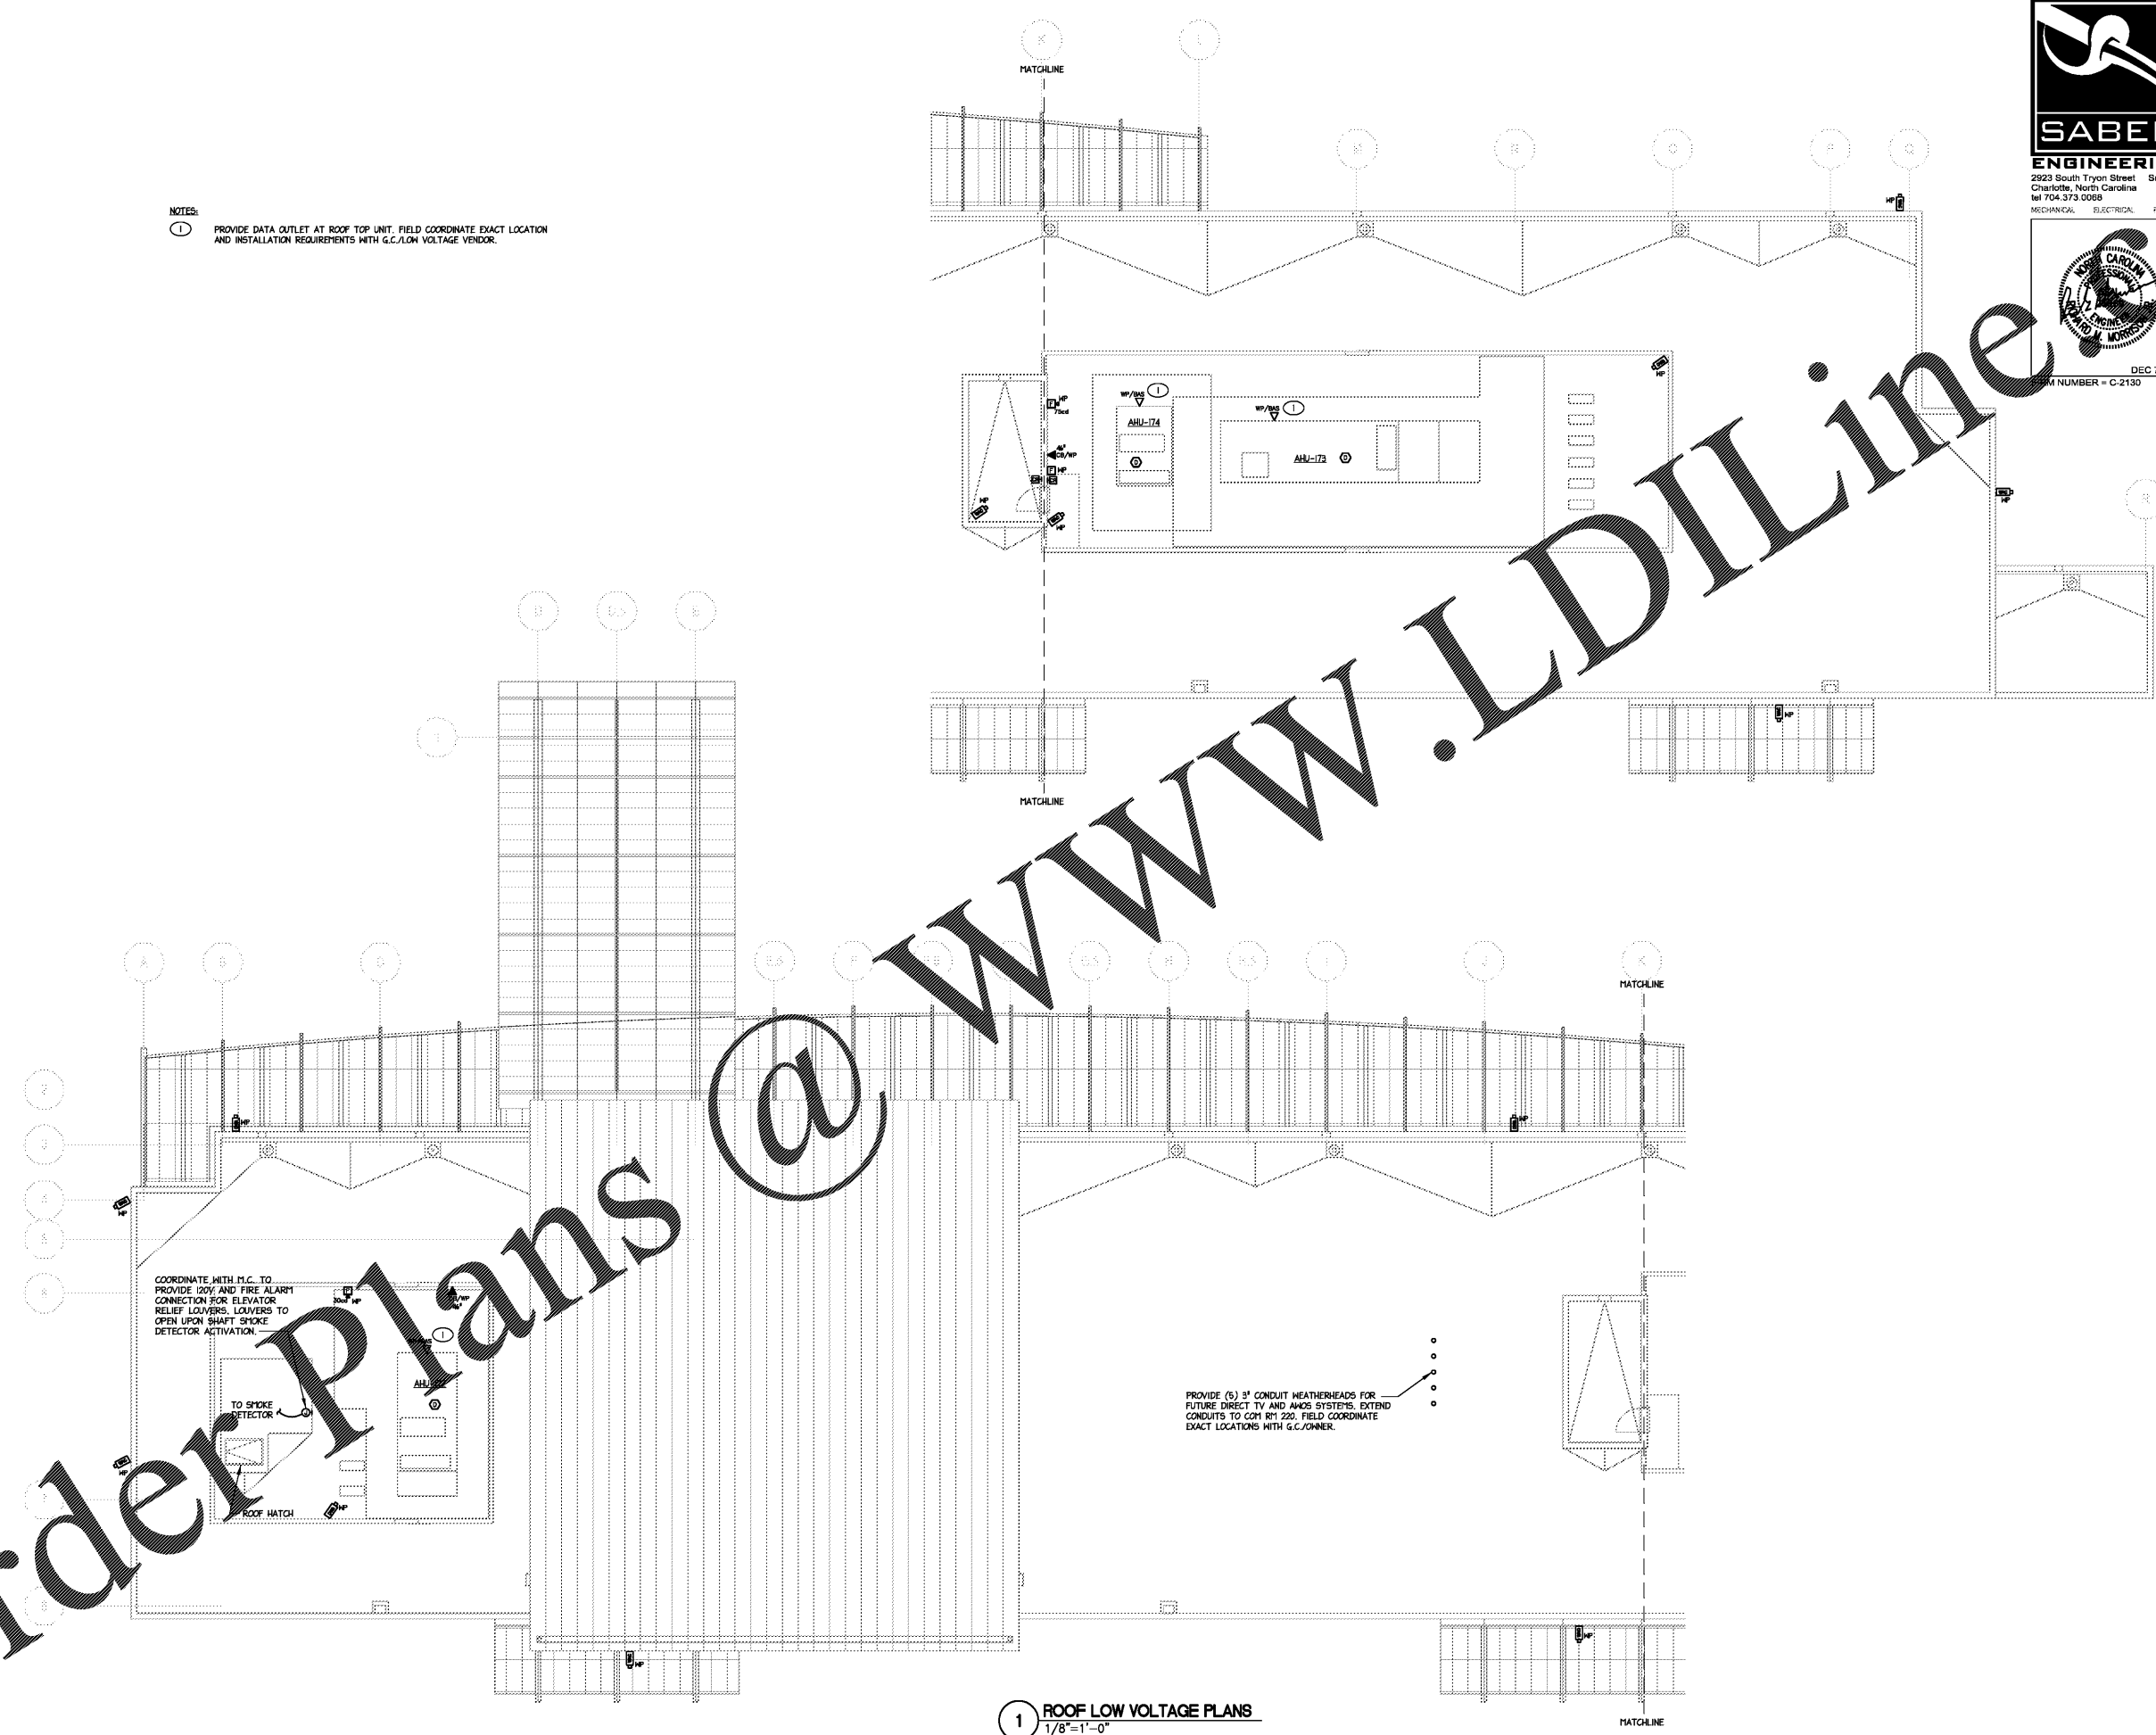

1 ROOF LOW VOLTAGE PLANS
 1/8"=1'-0"

Order Plans @

WWW.LDILine.com