


Order Plans

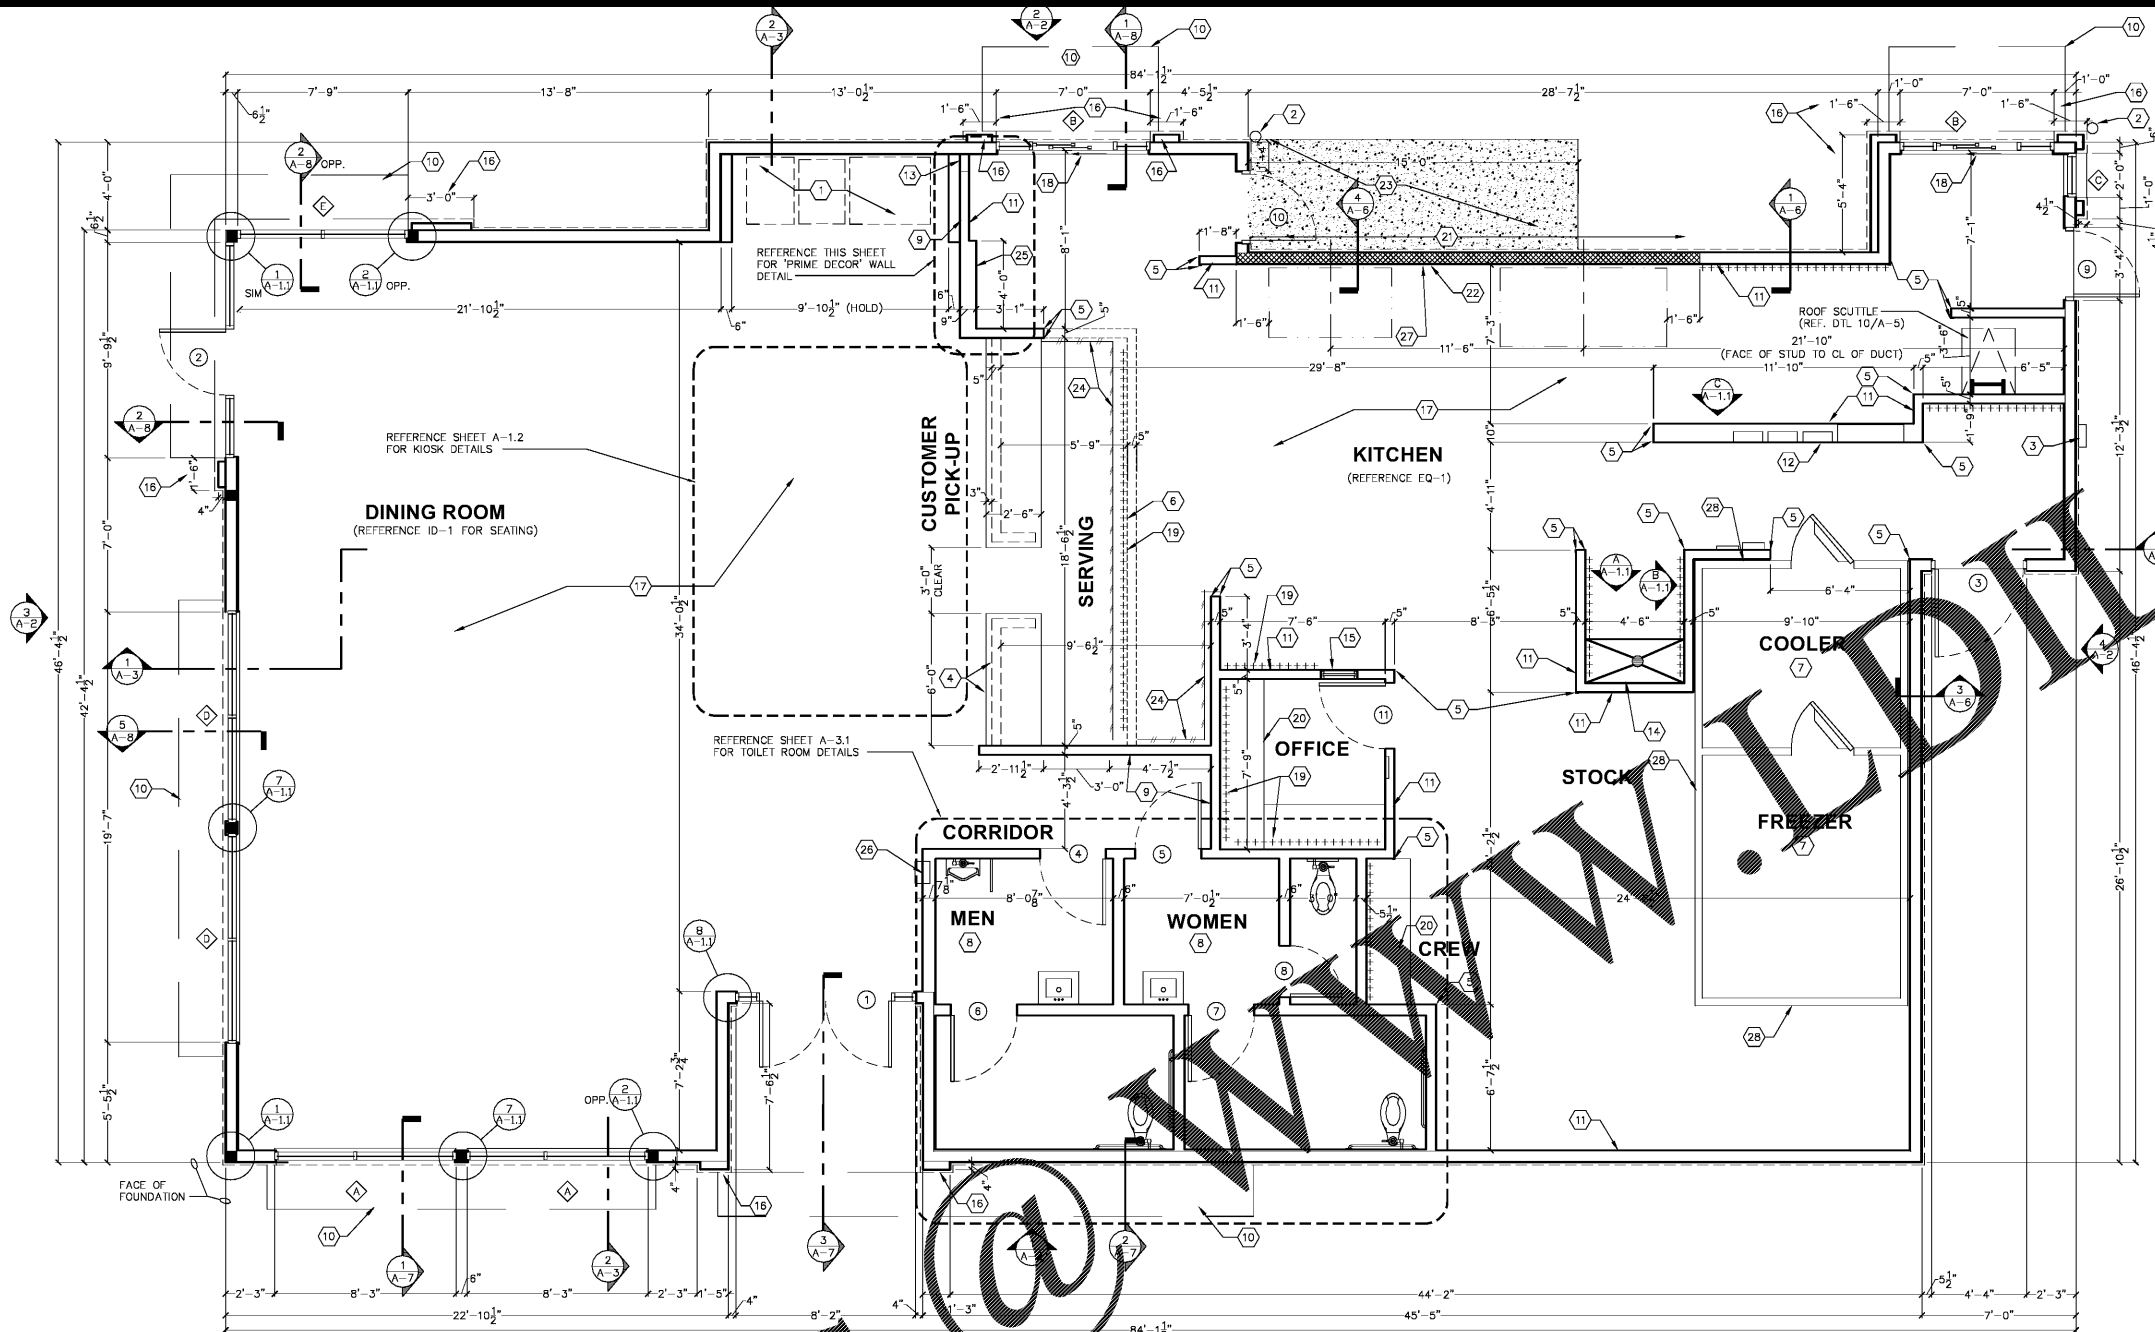

FLOOR PLAN
SCALE: 1/4" = 1'-0"

- OUTSIDE FACE OF FOUNDATION WALL BELOW.
- C. ALL ANGLED WALLS ARE AT 90° UNLESS NOTED OTHERWISE.
- D. FIRE EXTINGUISHERS, SHALL COMPLY WITH APPLICABLE BUILDING CODES AND LOCAL RESTRICTIONS. G.C. SHALL PROVIDE ONE (1) TYPE "ABC" EXTINGUISHER IN A SEMI-RECESSED, CLEAR ANODIZED ALUMINUM CABINET IN THE DINING ROOM AS LOCATED BY THE FIRE-MARSHAL AND ONE (1) TYPE "K" EXTINGUISHER WALL-MOUNTED ON A BRACKET IN THE KITCHEN. COORD. W/ FOOD SERVICE AND THE LOCAL FIRE MARSHAL.
- E. ELEVATION OF DRIVE-THROUGH LANE 2" (MAXIMUM) BELOW FINISH FLOOR ELEVATION. DRIVE-THROUGH LANE AT SAME ELEVATION AS FINISH FLOOR IS PREFERRED. REFERENCE DETAIL #5, SHEET A-1.1 FOR DOOR AND WINDOW TYPES. REFER TO SHEET A-1.0.
- F. AT THE KITCHEN THE G.C. IS TO PROVIDE STAINLESS STEEL OUTER CORNERS AT QUARRY TILE BASE IN LIEU OF QUARRY TILE CORNERS - SEE [HTTP://WWW.CENTURY-CORNERS.COM](http://www.century-corners.com)

KEYED NOTES:

- SELF-SERVE DRINKS AND CONDIMENT STAND. REFER TO SHEET D-1.
- STEEL BOLLARD - REFER TO SHEET S-1.
- ELECTRIC SERVICE - REFER TO ELECTRICAL DRAWINGS.
- SERVICE COUNTER PARTITION BY G.C. REFER TO DETAILS ON SHEET E-4 FOR ADDITIONAL INFORMATION. COORDINATE COUNTER TOP/FINISHES INSTALLATION RESPONSIBILITIES WITH THE SUPPLIER. MAXIMUM COUNTER HEIGHT = 32" A.F.F.
- CORNER GUARDS - REFER TO SHEET #4, SHEET A-1.1.
- MENU BOARD BULKHEAD ASSEMBLY. REFER TO SHEET A-4.1
- INTERIOR WALL IN BOTH FLOOR OR CONCRETE SLAB. VERIFY SIZE WITH MANUFACTURER.
- PROVIDE ADDITIONAL BULKHEADS BEHIND URINAL SCREEN AND BEHIND PLUMBING FIXTURES TO SUPPORT OF WATER LINES (TYPICAL). ALL WALLS AT EXISTING TRUSSES TO BE FRAMED AND FINISHED TO THE ROOF LINE OF ROOF ABOVE.
- RESTROOMS
- RESTROOMS - USE "DUROCK" PANELS AT FINISH FLOOR TO 24" A.F.F. WATER RESISTANT GYPSUM BOARD FROM 24" A.F.F. TO 6" ABOVE FINISHED CEILING. PROVIDE ALTERNATE BID OF 5/8" USE "FIBEROCK" PANELS IN LIEU OF DUROCK.
- DINING ROOM - CORRIDOR
- 5/8" TYPE "SHEETROCK" TYPE "X" GYPSUM WALL BOARD. FINISH: CORONADO PAINT - LIGHT ORANGE PEEL APPLIED WITH CORONADO AIR ASSIST TIP (Z-12KD) OR EQUAL.
- ELECTRICAL PANELS
- OPTION #1: RECESS ELECTRICAL CONTACTOR PANEL AND PANELS "A", "B" AND "M" IN FURRED OUT WALL ADJACENT TO EXTERIOR FRAMING. G.C. TO VERIFY PANEL SIZES PRIOR TO FURR-OUT TO INSURE ADEQUATE SPACE.
- OPTION #2: HILL PHOENIX INTEGRATED WALL UNIT INCLUDES PANELS "A", "B", "M" AND MASTER CONTRACTOR PANEL IN ONE CABINET. UNIT TO BE SURFACE MOUNTED ON A 4" HIGH CONCRETE CURB. REFERENCE SHEET E-5 FOR ADDITIONAL INFORMATION.
- PROVIDE 10"x10" FINISHED OPENING THROUGH WALL CENTERED AT 13" A.F.F. FOR ROUTING OF UTILITIES.
- CAN WASH - DUROCK SUBSTRATE ON ALL THREE SIDES, FLOOR TO CEILING.
- OFFICE WINDOW - REFERENCE SHEET A-1.0.
- 4" DEEP FURR-OUT ELEMENT, 18" FINISH WIDTH MINIMUM (U.N.O.). REFER TO WALL SECTIONS. PROVIDE 12" DEEP CONCRETE CURB (REF. FOUNDATION PLAN) AND FRAMING AS REQUIRED FOR FINISH DIMENSION REQUIREMENTS.
- TILE FLOOR (REFERENCE SPECIFICATIONS ON ID SHEETS).
- DRIVE-THROUGH SLIDING WINDOW.
- +++++ INDICATES 5/8" PLYWOOD BACKING ON WALLS FOR EQUIPMENT AS INDICATED ON PLAN OR SHELF SUPPORT FROM 48" A.F.F. TO 96" A.F.F., BEHIND 3-COMPARTMENT SINK AND PREP SINK AND ON BULKHEAD AT MENU BOARD WALL FROM 6'-8" A.F.F. TO BOTTOM OF ROOF TRUSSES.
- COUNTER TOP - REFERENCE DETAIL #5, A-1.1.
- USE 5/8" DUROCK (BOTH SIDES) ON 3'-5/8", 18 GAUGE CEE STUD FRAMING AT 16" O.C. BEHIND HOOD. WALL TO EXTEND 18" BEYOND EACH END OF HOOD.
- STAINLESS STEEL PANELS BELOW AND 18" WIDE AT EACH SIDE OF HOOD SUPPLIED BY HOOD MANUFACTURER AND INSTALLED BY G.C.
- 4" CONCRETE WALK BETWEEN DRIVE-THROUGH BUMP-OUTS. CONCRETE WALK IS NOT REQUIRED IF EXPEDITING DOORS ARE NOT USED.
- INDICATES 3"x12" SUBWAY TILE. REFER TO SHEET ID-1/AD-1.1.
- REMAINING BACK OF HOUSE WALLS TO BE FINISHED IN FIBERGLASS REINFORCED PANELS, FRP-1 (REFER TO APPLICABLE INTERIOR FINISH SCHEDULE)
- 8" STUD WALL. REFER TO INTERIOR FINISH SCHEDULE.
- PROVIDE TYPE ABC FIRE-EXTINGUISHER IN SIMI-RECESSED WALL-CABINET.
- PROVIDE TYPE X FIRE EXTINGUISHER AT KITCHEN - LOCATED ON WALL-MOUNTED HOOK WERE REQUIRED BY FIRE-MARSHAL
- PROVIDE DRAFT-STOP - 2X4 FRAMING W/ TAPED AND SEALED GYP BETWEEN THE DECK AND THE TOP OF COOLER - ABOVE CEILING AT COOLER / FREEZER
- WALLS AT RESTROOMS SHOWN W/ ADDITIONAL DIMENSION SPACE TO ALLOW FOR TILE WALL FINISHES; STUDS @ 5-1/2" & 6" WALLS ARE TO BE 2X4 (NOM) STUDS W/ FINISHES, ETC.
- BACK OF HOUSE FLOOR & BASE FINISHES TO BE THE FOLLOWING UNLESS NOTED OTHERWISE BY INTERIOR DECOR:
 - FLOOR - QUARRY TILE - 6X6 - DAL-TILE COLOR: -0042 "AIRD GRAY" W/ ADDED ABRASIVE GRAIN.
 - BASE - QUARRY TILE - 5X6 - DAL-TILE COLOR: Q-3565 "AIRD GRAY"
 - GROUT - LATICRETE - SPECTRALOCK 2000G - COLOR: #45 "RAVEN"
 - TRANSITION STRIPS (AS NEEDED) - SCHLUTER SYSTEM - SCHIENE AND / OR AE 1000 - R, SATIN ANODIZED ALUMINUM - 3/8" - 10MM
- OFFICE WINDOW - 1'-8"(W) X 2'-0" TALL CLEAR ANODIZED ALUM. STOREFRONT FRAMING W/ SINGLE PANEL, CLEAR, TEMPERED GLAZING SET 3'-0" (MIN.) A.F.F.



PREMIER KINGS, INC.
5529 CARMICHAEL ROAD
MONTGOMERY, ALABAMA 36117
P-O-BOX
LINES@BKCALABAMA.COM

2126 Morris Avenue
Birmingham, AL 35203
Phone: (205) 329-1751
Fax: (205) 329-1752
www.hpluhba.com

hendon huckestein architects, PC
architecture • planning • interior design



FLOOR PLAN
A-1