


Order Plans

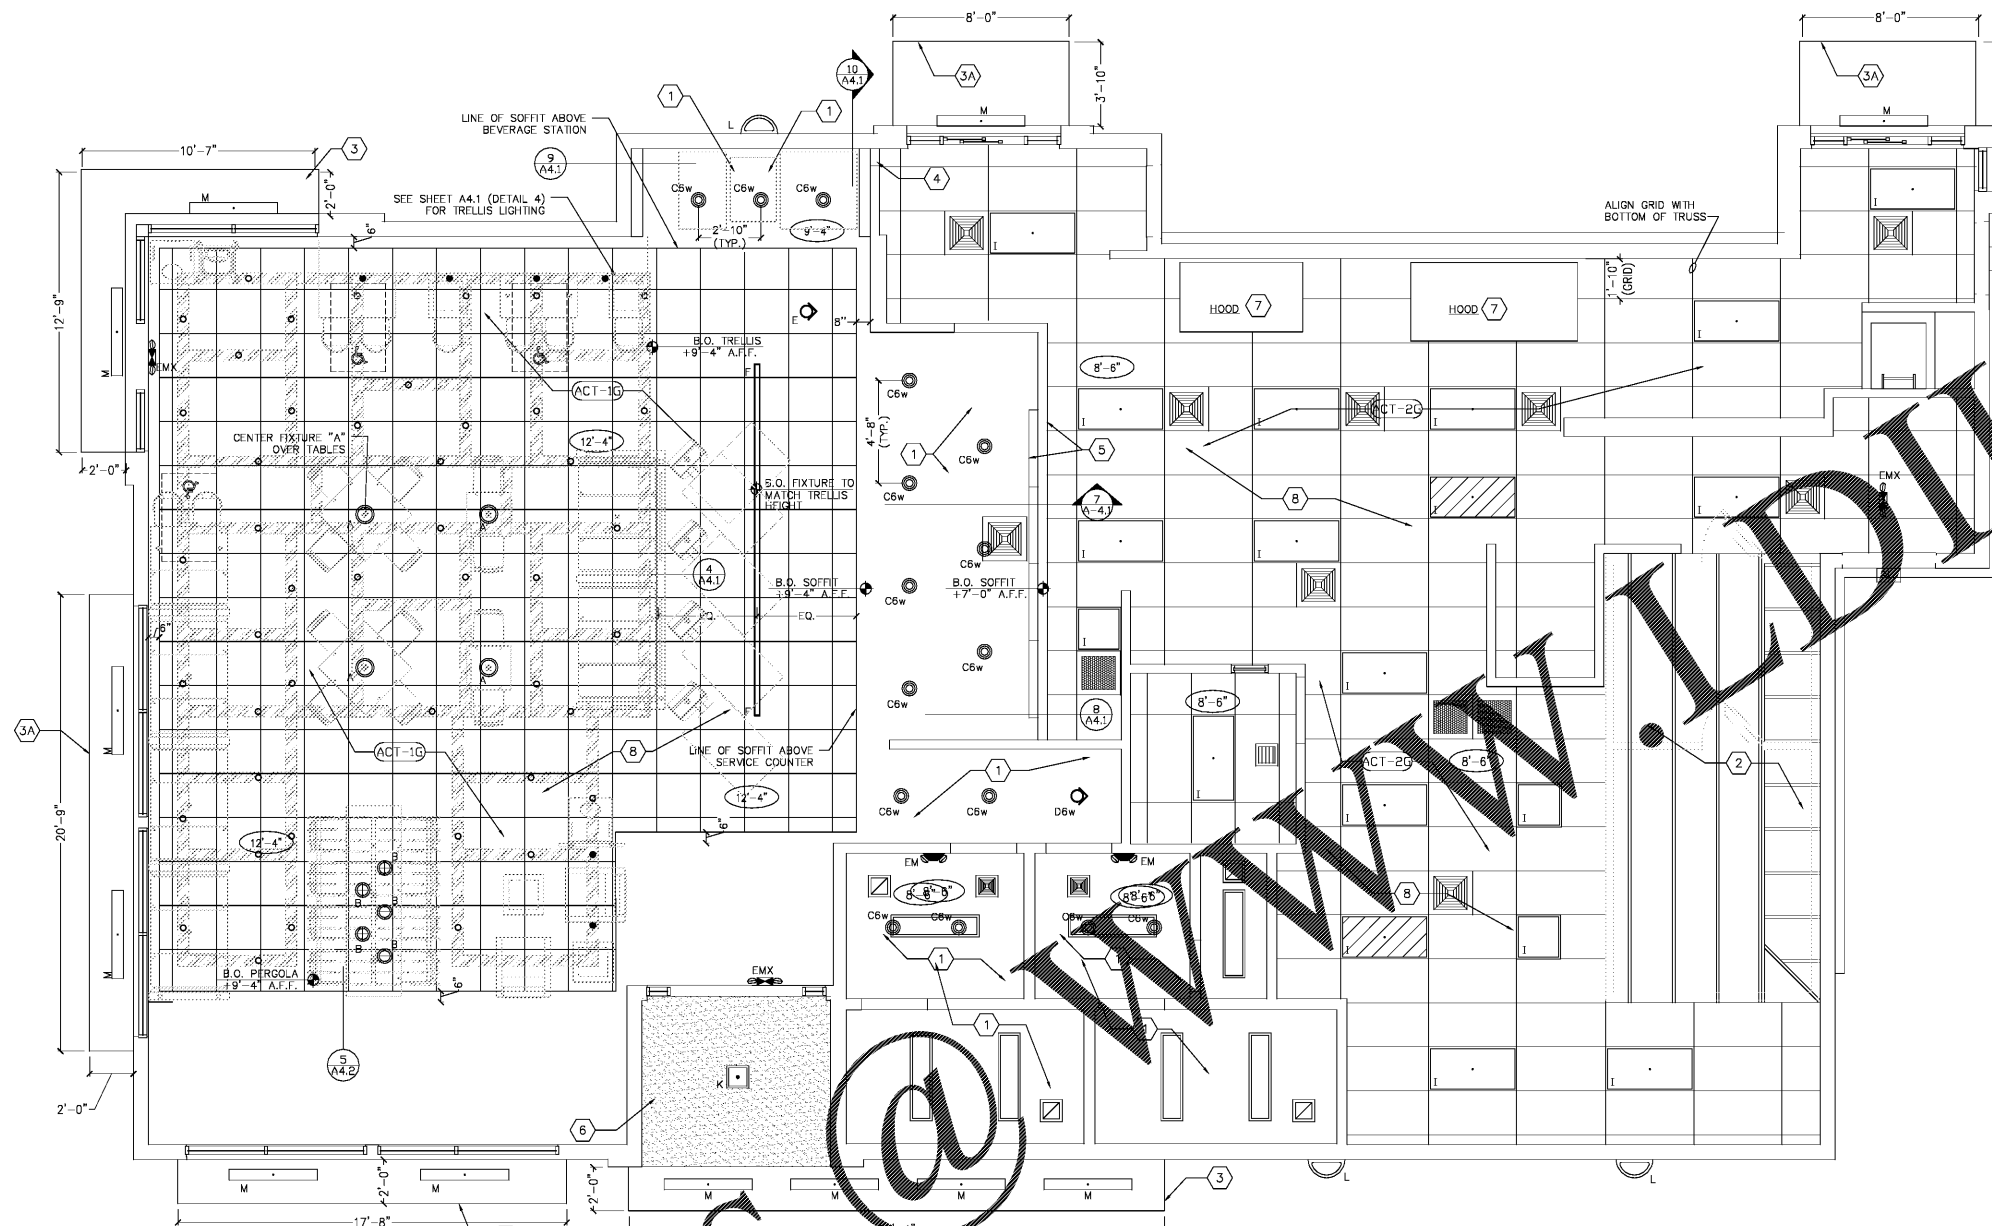

**REFLECTED CEILING PLAN**  
SCALE: 1/4" = 1'-0"

**GENERAL NOTES:**

- A. ALL DIMENSIONS SHOWN ON REFLECTED CEILING PLAN ARE FROM FACE OF WALL UNLESS NOTED OTHERWISE.
- B. THE REFERENCE HEIGHTS INDICATED ON PLAN ARE FROM FINISH FLOOR (F.F.).
- C. GENERAL CONTRACTOR TO COORDINATE DINING ROOM LIGHTING WITH APPROVED INTERIOR DECOR DRAWINGS.
- D. CONTRACTOR SHALL VERIFY FIXTURE QUANTITIES AND ALSO MAKE PROPER ADJUSTMENTS FOR ANY CHANGES IN PLAN DUE TO ADDITIONAL REQUIREMENTS, LOCAL CODES, ETC.
- E. FOR H.V.A.C. PLAN, SECTIONS, DUCT LOCATIONS, SUPPLY AND RETURN GRILLE SIZES AND ADDITIONAL INFORMATION, REFERENCE SHEET M-1.
- F. ALL FIXTURES SHALL BE LOCATED IN CENTER OF CEILING TILES UNLESS NOTED OTHERWISE.
- G. REFERENCE SHEET E-1 FOR LIGHTING LAYOUT REQUIREMENTS AND ADDITIONAL INFORMATION.
- H. REFERENCE INTERIOR DECOR SHEETS FOR FINISH SPECIFICATIONS.
- I. CONTRACTOR SHALL VERIFY PENDANT LOCATIONS WITH DECOR SUPPLIER DRAWINGS.

**KEYED NOTES:**

- 1 GYPSUM BOARD WALK-IN SOFFIT EXPOSED TRUSSES ABOVE WALK-IN BOX. REFER TO W.I.B. DRAWINGS FOR INTERIOR LIGHT FIXTURES.
- 2 FABRICATED METAL CANOPY
- 3A FABRICATED METAL CANOPY OR AWNING
- 4 STAINLESS STEEL SERVICE CHASE
- 5 MENU BOARD AND HEADER. REFERENCE DTL 7/A-4.1
- 6 SOFFIT ABOVE ENTRY. -CEILING PAINT TO MATCH INTERIOR CEILING IF VESTIBULE IS ENCLOSED. -CEILING PAINT TO BE EP-2G IF VESTIBULE IS OPEN. (REFER TO EXTERIOR FINISH SCHEDULE)
- 7 MECHANICAL EXHAUST HOOD ABOVE
- 8 SUSPENDED ACOUSTICAL TILE CEILING. REFER TO FINISH SCHEDULE.

**NOTE:**  
DINING ROOMS ARE DESIGNED TO A 35 - 40 FOOT-CANDLE LEVEL.  
KITCHENS ARE DESIGNED TO 50 FOOT-CANDLE LEVEL.  
RESTROOMS ARE DESIGNED TO 50 FOOT-CANDLE. FOR ADDITIONAL INFORMATION ON LIGHTING REQUIREMENTS REFER TO BURGER KING LIGHTING STANDARDS POSTED @ DESIGNWITHBK.COM/COMMON DOCUMENTS.

**SYMBOLS LEGEND**

SYMBOL	DESCRIPTION
	SUPPLY AIR DIFFUSERS
	RETURN AIR GRILLES
	EXHAUST FAN GRILLES
A	SINGLE PENDANT. COORDINATE LOCATION AND QUANTITY WITH DECOR SUPPLIER.
B	SINGLE PENDANT. COORDINATE LOCATION AND QUANTITY WITH DECOR SUPPLIER.
C6w	6" DIAMETER RECESSED DOWNLIGHT
D6w	6" DIAMETER ADJUSTABLE WALL WASH DOWNLIGHT
E	ADJUSTABLE TRACK LIGHT
F	PROFILE LIGHT
G	2" DIAMETER DOWNLIGHT
G1	2" DIAMETER WALL WASH DOWNLIGHT
I	2x4 RECESSED FLAT LENS (NIGHT LIGHT WHEN SHOWN HATCHED)
K	12x12 RECESSED SOFFIT LIGHT
L	SURFACE MOUNTED EXTERIOR WALL SCONCE (ALSO USED IN OPEN CANOPIES)
M	WET LISTED 4'-0" CANOPY LIGHT (USED UNDER AWNINGS AND CLOSED CANOPIES)
N	WALL MOUNTED SECURITY LIGHT
EM	EMERGENCY LIGHT
EMX	EXIT LIGHT

REF. SHEET M-1 FOR SPECIFICATIONS  
REFERENCE SHEET E-1.1 FOR SPECIFICATIONS

NO.	DATE	BY	CHECKED BY	REVISED FOR
1	01.31.19	B.M.W.	B.M.W.	CONSTRUCTION



PREMIER KINGS, INC.  
5529 CARMICHAEL ROAD  
MONTGOMERY, ALABAMA 36117  
P-O-BOX 11000  
LINSEY@BKALABAMA.COM

2126 Morris Avenue  
Birmingham, AL 35203  
Phone: (205) 329-7251  
Fax: (205) 329-7251  
www.hpluhba.com

hendons huckestein architects, PC  
architecture • planning • interior design



PROJECT # 18026.02  
RCC-60 TALL 20/20 IMAGE: NOVEMBER 2018 DESIGN RELEASE  
**BURGER KING RESTAURANT**  
CORNER OF US280 & BURNS LANE  
HARTSVILLE, AL  
01.31.19  
REFLECTED CEILING - OPTION 2