




- NOTES:
- SUSPENDED TRELLIS 3D LAMINATE ON PVC BOARD, REF (K) OMINIPOINT COLUMNS ALMOND CHERRY 12 MIL.
 - GENERAL DIMENSIONS 6"x4" SUSPENDED FROM AN OPEN TRUSS CEILING.
 - SUSPENDED SYSTEM: UNISTRUT ELEMENTS AND THREADED RODS.
 - FIT UNISTRUT BETWEEN JOIST SYSTEM WITH SUFFICIENT CLEARANCE ALLOW FOR MOVEMENT DURING INSTALLATION. PROVIDE (2) 3/8" UNISTRUT AND ONE (1) WASHER (ID:0.375, OD 1.00).
 - NUMBER OF MODULES SHALL BE DETERMINED BY BUILDING CONDITIONS. ALL MODULES SHALL BE INTERCONNECTED.
 - ADJUST CONNECTION ELEMENTS DURING INSTALLATION PER BUILDING CONDITIONS.
 - LIGHT FIXTURES SHALL BE LOCATED AT THE MODULES, NOT THE CONNECTING ELEMENTS. CONCEALED LED LIGHTS PER BURGER KING LIGHTING STANDARDS. THE MINIMUM NUMBER OF CONCEALED TRELLIS LIGHT FIXTURES SHALL COMPLY WITH BUILDING CODES AND REGULATIONS. FOR LIGHT FIXTURE TYPES REFER TO LIGHT FIXTURE SCHEDULE FOUND ON DESIGNWITHBK.COM (COMMON DOCUMENTS).

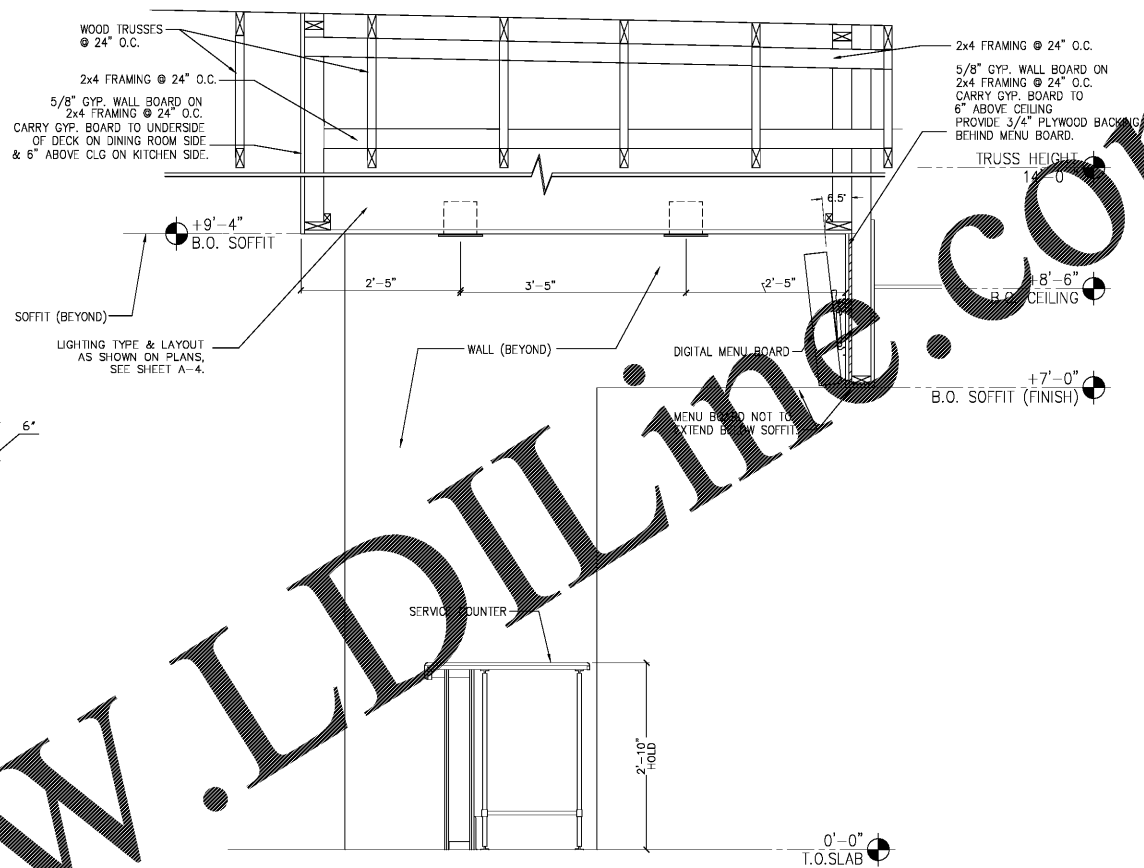

7 MENU BOARD HEADER & FRONT SERVICE COUNTER SOFFIT DETAIL
SCALE: 3/4" = 1'-0"

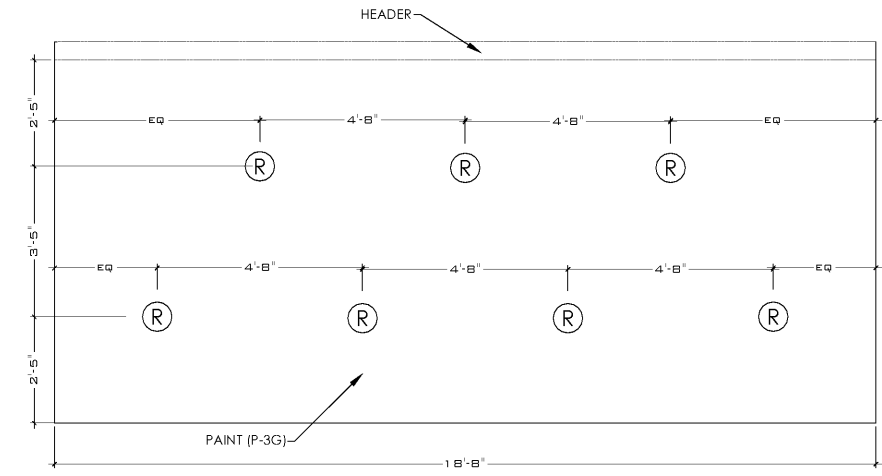


8 FRONT SERVICE COUNTER SOFFIT DETAIL
SCALE: 1/2" = 1'-0"

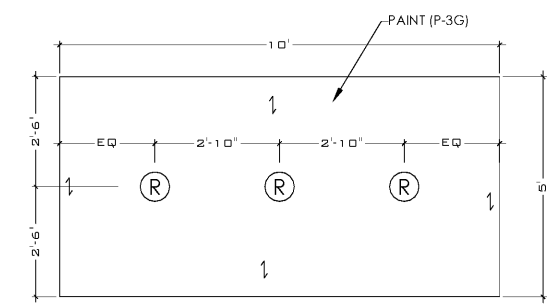

9 BEVERAGE STATION SOFFIT DETAIL
SCALE: 1/2" = 1'-0"

10 BEVERAGE STATION SOFFIT DETAIL
SCALE: 3/4" = 1'-0"
SUSPENDED ACOUSTICAL CEILING CONDITION.

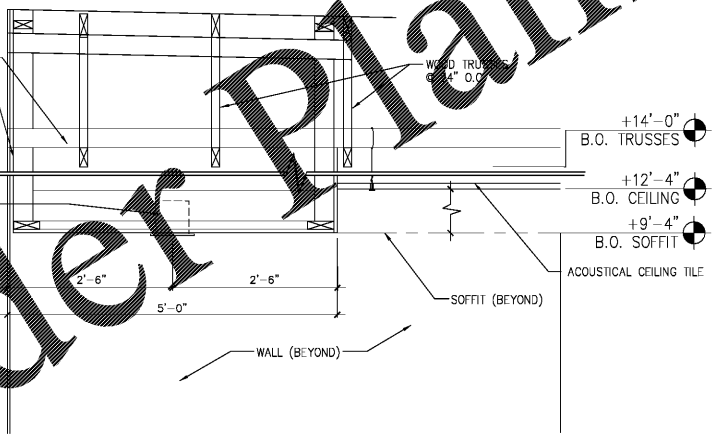

4 TRELLIS DETAILS
SCALE: 3/8" = 1'-0"

SEE ELECTRICAL CEILING PLAN (E-1) FOR CONTINUATION

Order Plans @ www.ldilines.com

NO.	DATE	REVISION	RELEASED FOR CONSTRUCTION
01.31.19			

DRAWN BY: MRW
CHECKED BY: LHM
E.O. 3119



PREMIER KINGS, INC.
5529 CARMICHAEL ROAD
MONTGOMERY, ALABAMA 36117
P-O-BOX 1100
LINSEY@BKALABAMA.COM

2126 Morris Avenue
Birmingham, AL 35203
Phone: (205) 329-1751
Fax: (205) 329-1751
www.hpluhba.com

hendon huckestein architects, PC
architecture • planning • interior design



PROJECT # 18026.02
RCC-60 TALL 20/20 IMAGE: NOVEMBER 2018 DESIGN RELEASE
BURGER KING RESTAURANT
CORNER OF US280 & BURNS LANE
HARRERSVILLE, AL
REFLECTED CEILING DETAILS