


Order Plans @

WWW.LDLINE.COM

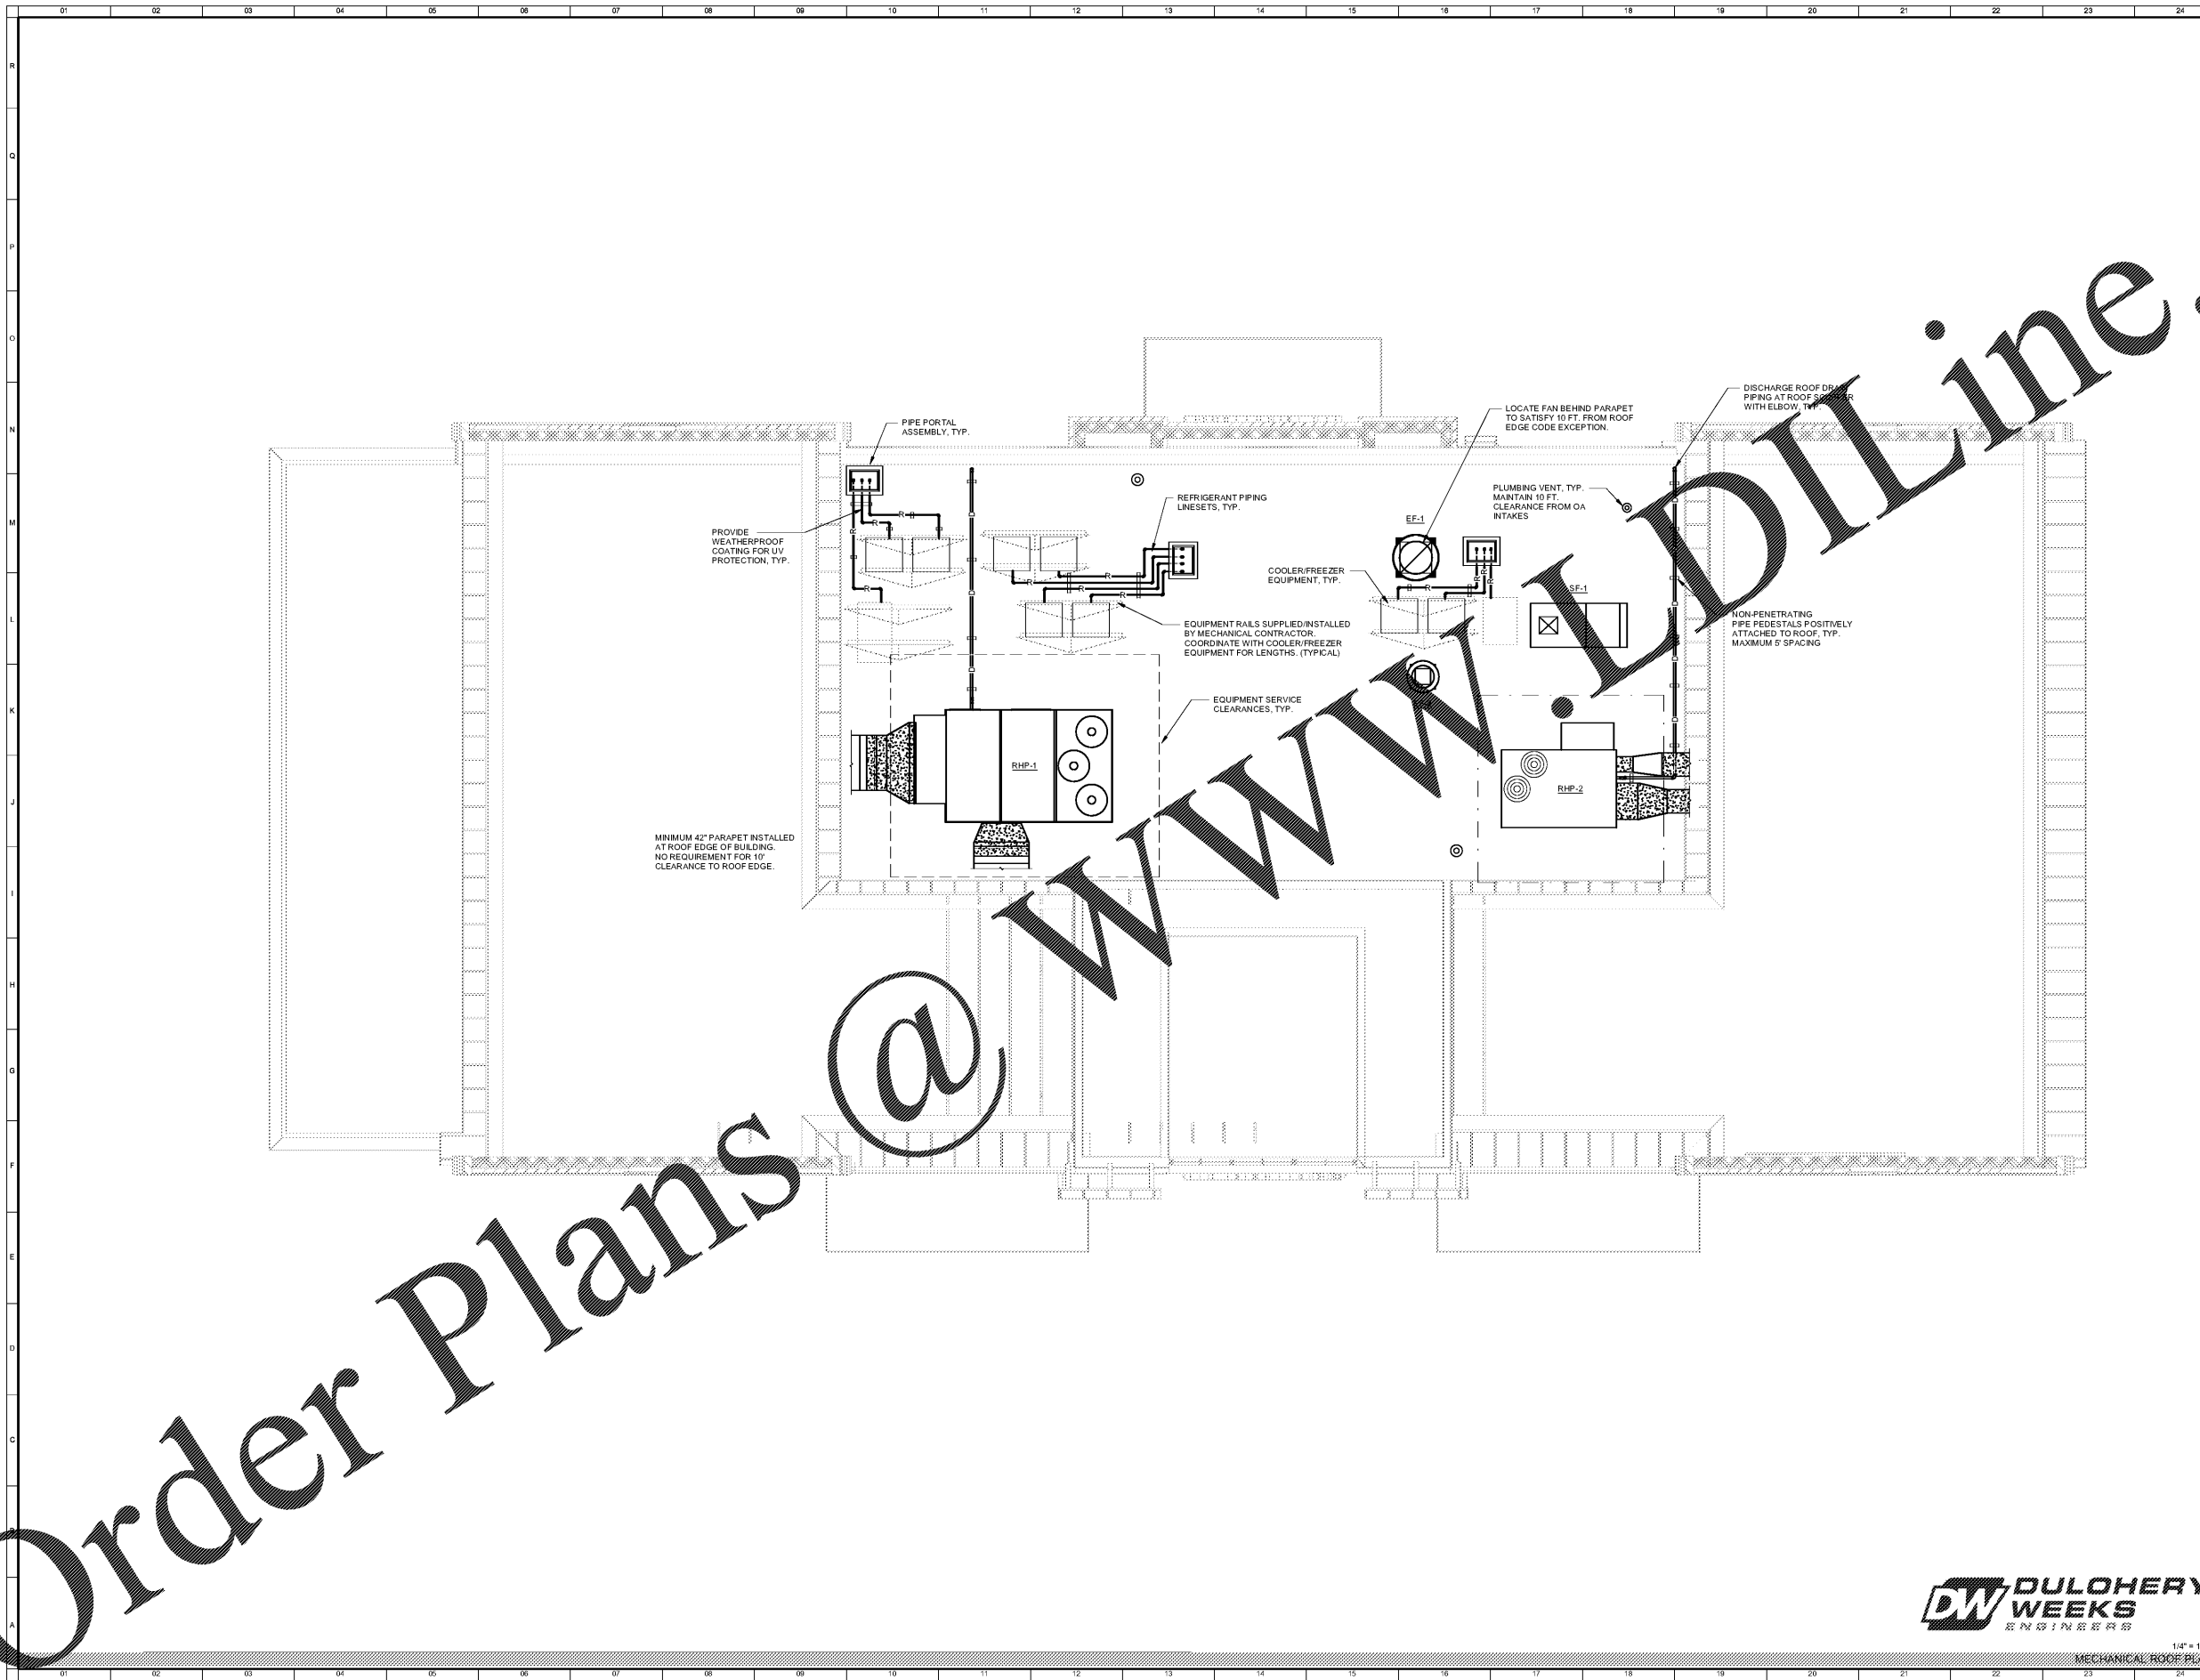

LYNCH
ARCHITECTS
17 WEST MCCONOUGH ST.
SAVANNAH, GA 31401

PARKER'S CANE BAY

THE PARKER COMPANIES
17 WEST MCCONOUGH ST.
SAVANNAH, GA 31401

Parkers

Revisions

NO.	DATE	DESCRIPTION

MECHANICAL ROOF PLAN

Scale: 1/4" = 1'-0"

DATE: 07/01/19

PROJECT: P-1801

DESIGNER: DW

M102



2/1/2019 9:14:00 AM