


Order Plans

Oct 24, 2018 1:28pm - User: cels richardson
 L:\2018-19-2019\15 Loves - Meadowview, VA\15100000\SHEET 415 YE-4 POWER FLOOR PLANS.dwg

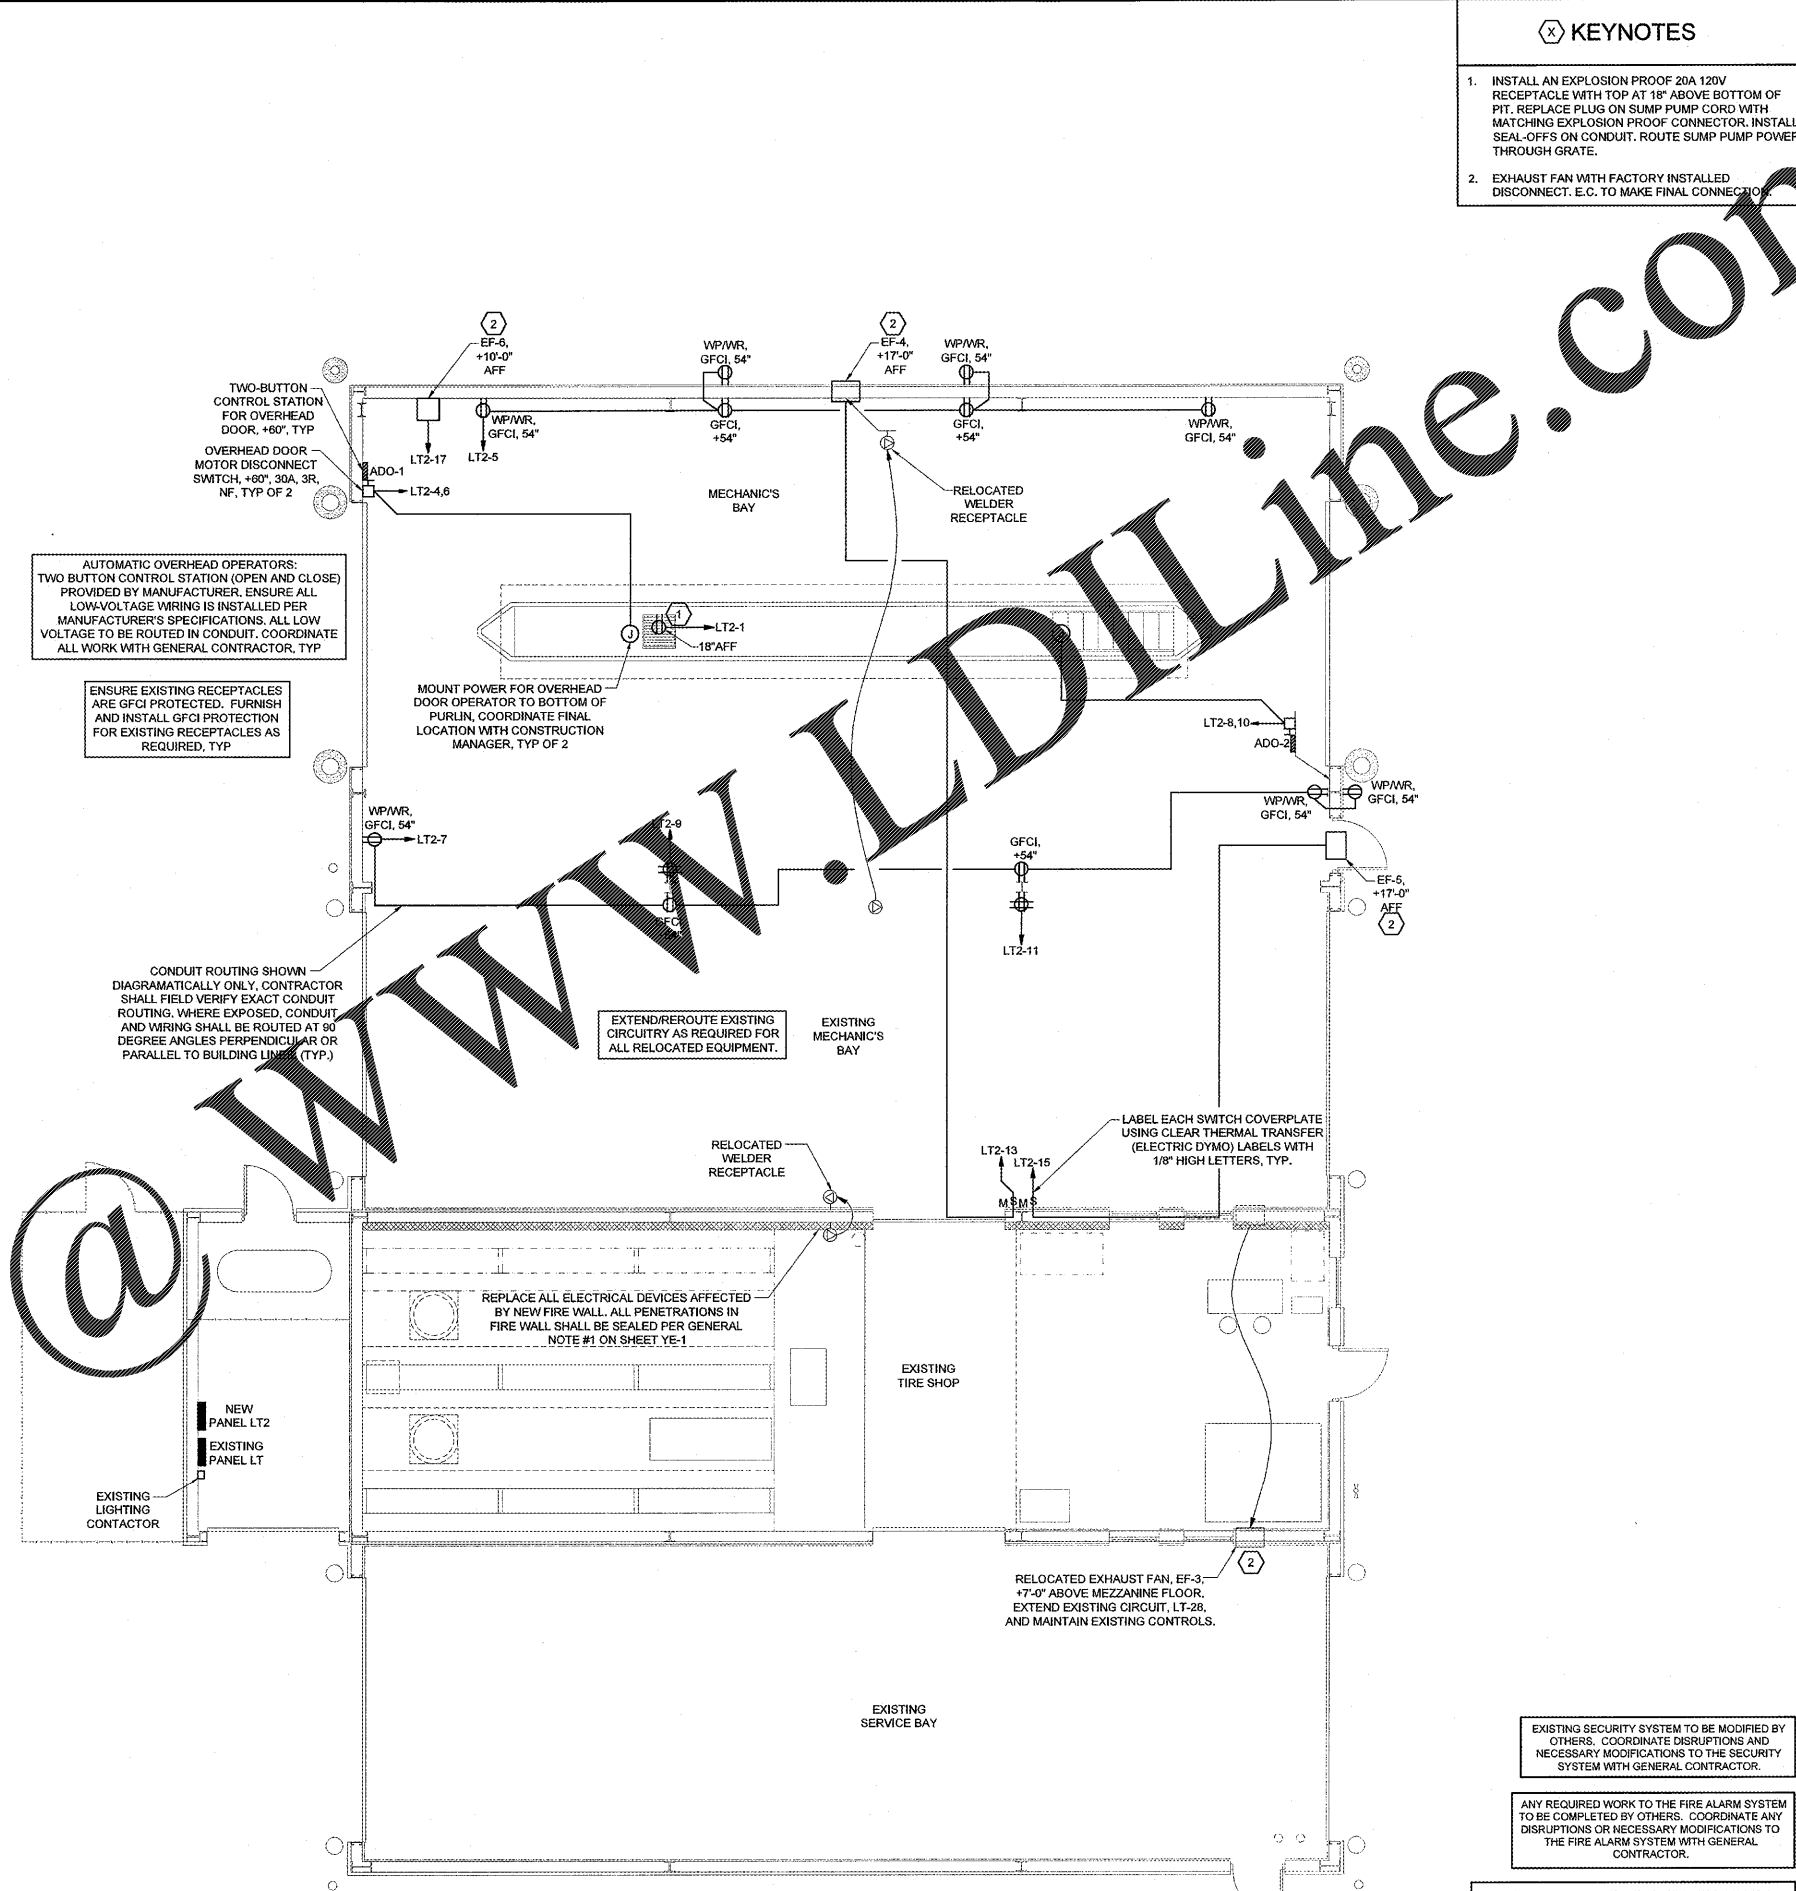

1 POWER FLOOR PLAN
SCALE: 1/4"=1'-0"

KEYNOTES

- INSTALL AN EXPLOSION PROOF 20A 120V RECEPTACLE WITH TOP AT 18" ABOVE BOTTOM OF PIT. REPLACE PLUG ON SUMP PUMP CORD WITH MATCHING EXPLOSION PROOF CONNECTOR. INSTALL SEAL-OFFS ON CONDUIT. ROUTE SUMP PUMP POWER THROUGH GRATE.
- EXHAUST FAN WITH FACTORY INSTALLED DISCONNECT. E.C. TO MAKE FINAL CONNECTIONS.

AUTOMATIC OVERHEAD OPERATORS: TWO BUTTON CONTROL STATION (OPEN AND CLOSE) PROVIDED BY MANUFACTURER. ENSURE ALL LOW VOLTAGE WIRING IS INSTALLED PER MANUFACTURER'S SPECIFICATIONS. ALL LOW VOLTAGE TO BE ROUTED IN CONDUIT. COORDINATE ALL WORK WITH GENERAL CONTRACTOR, TYP

ENSURE EXISTING RECEPTACLES ARE GFCI PROTECTED. FURNISH AND INSTALL GFCI PROTECTION FOR EXISTING RECEPTACLES AS REQUIRED, TYP

CONDUIT ROUTING SHOWN DIAGRAMATICALLY ONLY. CONTRACTOR SHALL FIELD VERIFY EXACT CONDUIT ROUTING. WHERE EXPOSED, CONDUIT AND WIRING SHALL BE ROUTED AT 90 DEGREE ANGLES PERPENDICULAR OR PARALLEL TO BUILDING LINES (TYP)

EXTEND/REROUTE EXISTING CIRCUITRY AS REQUIRED FOR ALL RELOCATED EQUIPMENT.

LABEL EACH SWITCH COVERPLATE USING CLEAR THERMAL TRANSFER (ELECTRIC DYMO) LABELS WITH 1/8" HIGH LETTERS, TYP.

REPLACE ALL ELECTRICAL DEVICES AFFECTED BY NEW FIRE WALL. ALL PENETRATIONS IN FIRE WALL SHALL BE SEALED PER GENERAL NOTE #1 ON SHEET YE-1

RELOCATED EXHAUST FAN, EF-3 +7'-0" ABOVE MEZZANINE FLOOR. EXTEND EXISTING CIRCUIT, LT-28, AND MAINTAIN EXISTING CONTROLS.

EXISTING SECURITY SYSTEM TO BE MODIFIED BY OTHERS. COORDINATE DISRUPTIONS AND NECESSARY MODIFICATIONS TO THE SECURITY SYSTEM WITH GENERAL CONTRACTOR.

ANY REQUIRED WORK TO THE FIRE ALARM SYSTEM TO BE COMPLETED BY OTHERS. COORDINATE ANY DISRUPTIONS OR NECESSARY MODIFICATIONS TO THE FIRE ALARM SYSTEM WITH GENERAL CONTRACTOR.

EACH SUBCONTRACTOR IS RESPONSIBLE FOR HAVING A THOROUGH KNOWLEDGE OF ALL DRAWINGS AND SPECIFICATIONS IN THEIR RELATED FIELD. THE FAILURE TO ACQUAINT HIMSELF WITH THIS KNOWLEDGE DOES NOT RELIEVE THE RESPONSIBILITY OF PERFORMING HIS WORK PROPERLY. NO ADDITIONAL COMPENSATION SHALL BE ALLOWED BECAUSE OF CONDITIONS THAT OCCUR DUE TO FAILURE TO FAMILIARIZE WORKERS WITH THIS KNOWLEDGE.

HFA
ARCHITECTS
ENGINEERS
INTERIORS

FRISON FRENCH
& ASSOCIATES, LTD.

1705 S. ... Blvd, Suite 3
Bentonville, Arkansas 72712
972.275.7780
1.888.520.9685
www.hfa-ae.com


STIPULATION FOR REUSE
THIS DRAWING IS THE PROPERTY OF HFA ARCHITECTS ENGINEERS INTERIORS. IT IS TO BE USED ONLY FOR THE PROJECT AND SITE SPECIFICALLY IDENTIFIED ON THE DRAWING. ANY REUSE OF THIS DRAWING FOR ANY OTHER PROJECT WITHOUT THE WRITTEN PERMISSION OF HFA ARCHITECTS ENGINEERS INTERIORS IS STRICTLY PROHIBITED. THE USER OF THIS DRAWING SHALL BE RESPONSIBLE FOR OBTAINING ALL NECESSARY PERMITS AND APPROVALS FROM THE APPROPRIATE AGENCIES.

13365 GLENBROOK AVE
MEADOWVIEW, VA 24361

Light Mechanical Service Addition

PROJECT NUMBER: 03-18-20613

Loves
Travel Stop &
Country Stores

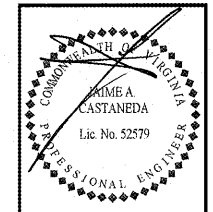

OCT 24 2018

ISSUE BLOCK	

STORE NO.	613
DOCUMENT DATE:	10/25/18
CHECKED BY:	CRA
DRAWN BY:	TEC
PROTO CYCLE:	

POWER FLOOR PLANS

SHEET:
YE-4