
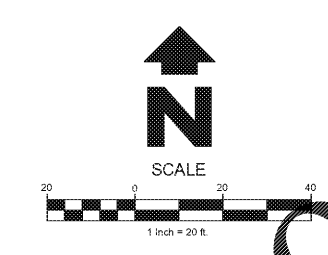
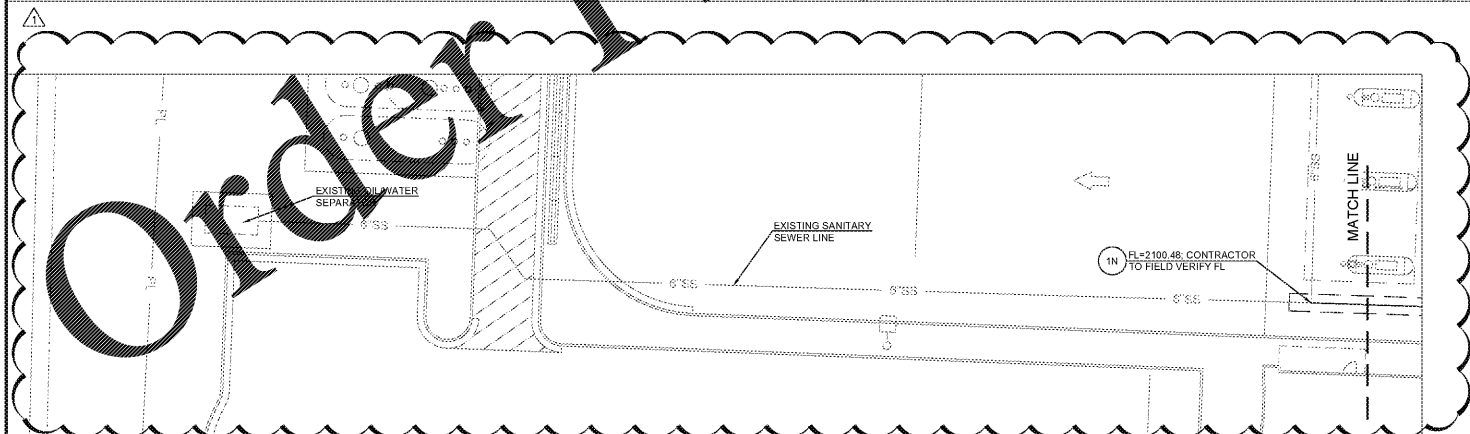


J:\07_2019\19-10-02am - User: isarah.bryant\c:\0362-18-2673 Loves - Meadowview, VA\01\CIVIL\Construction Documents\Folder2019\01-07 (ADD-1) 03-18-2018 10 proj.dwg

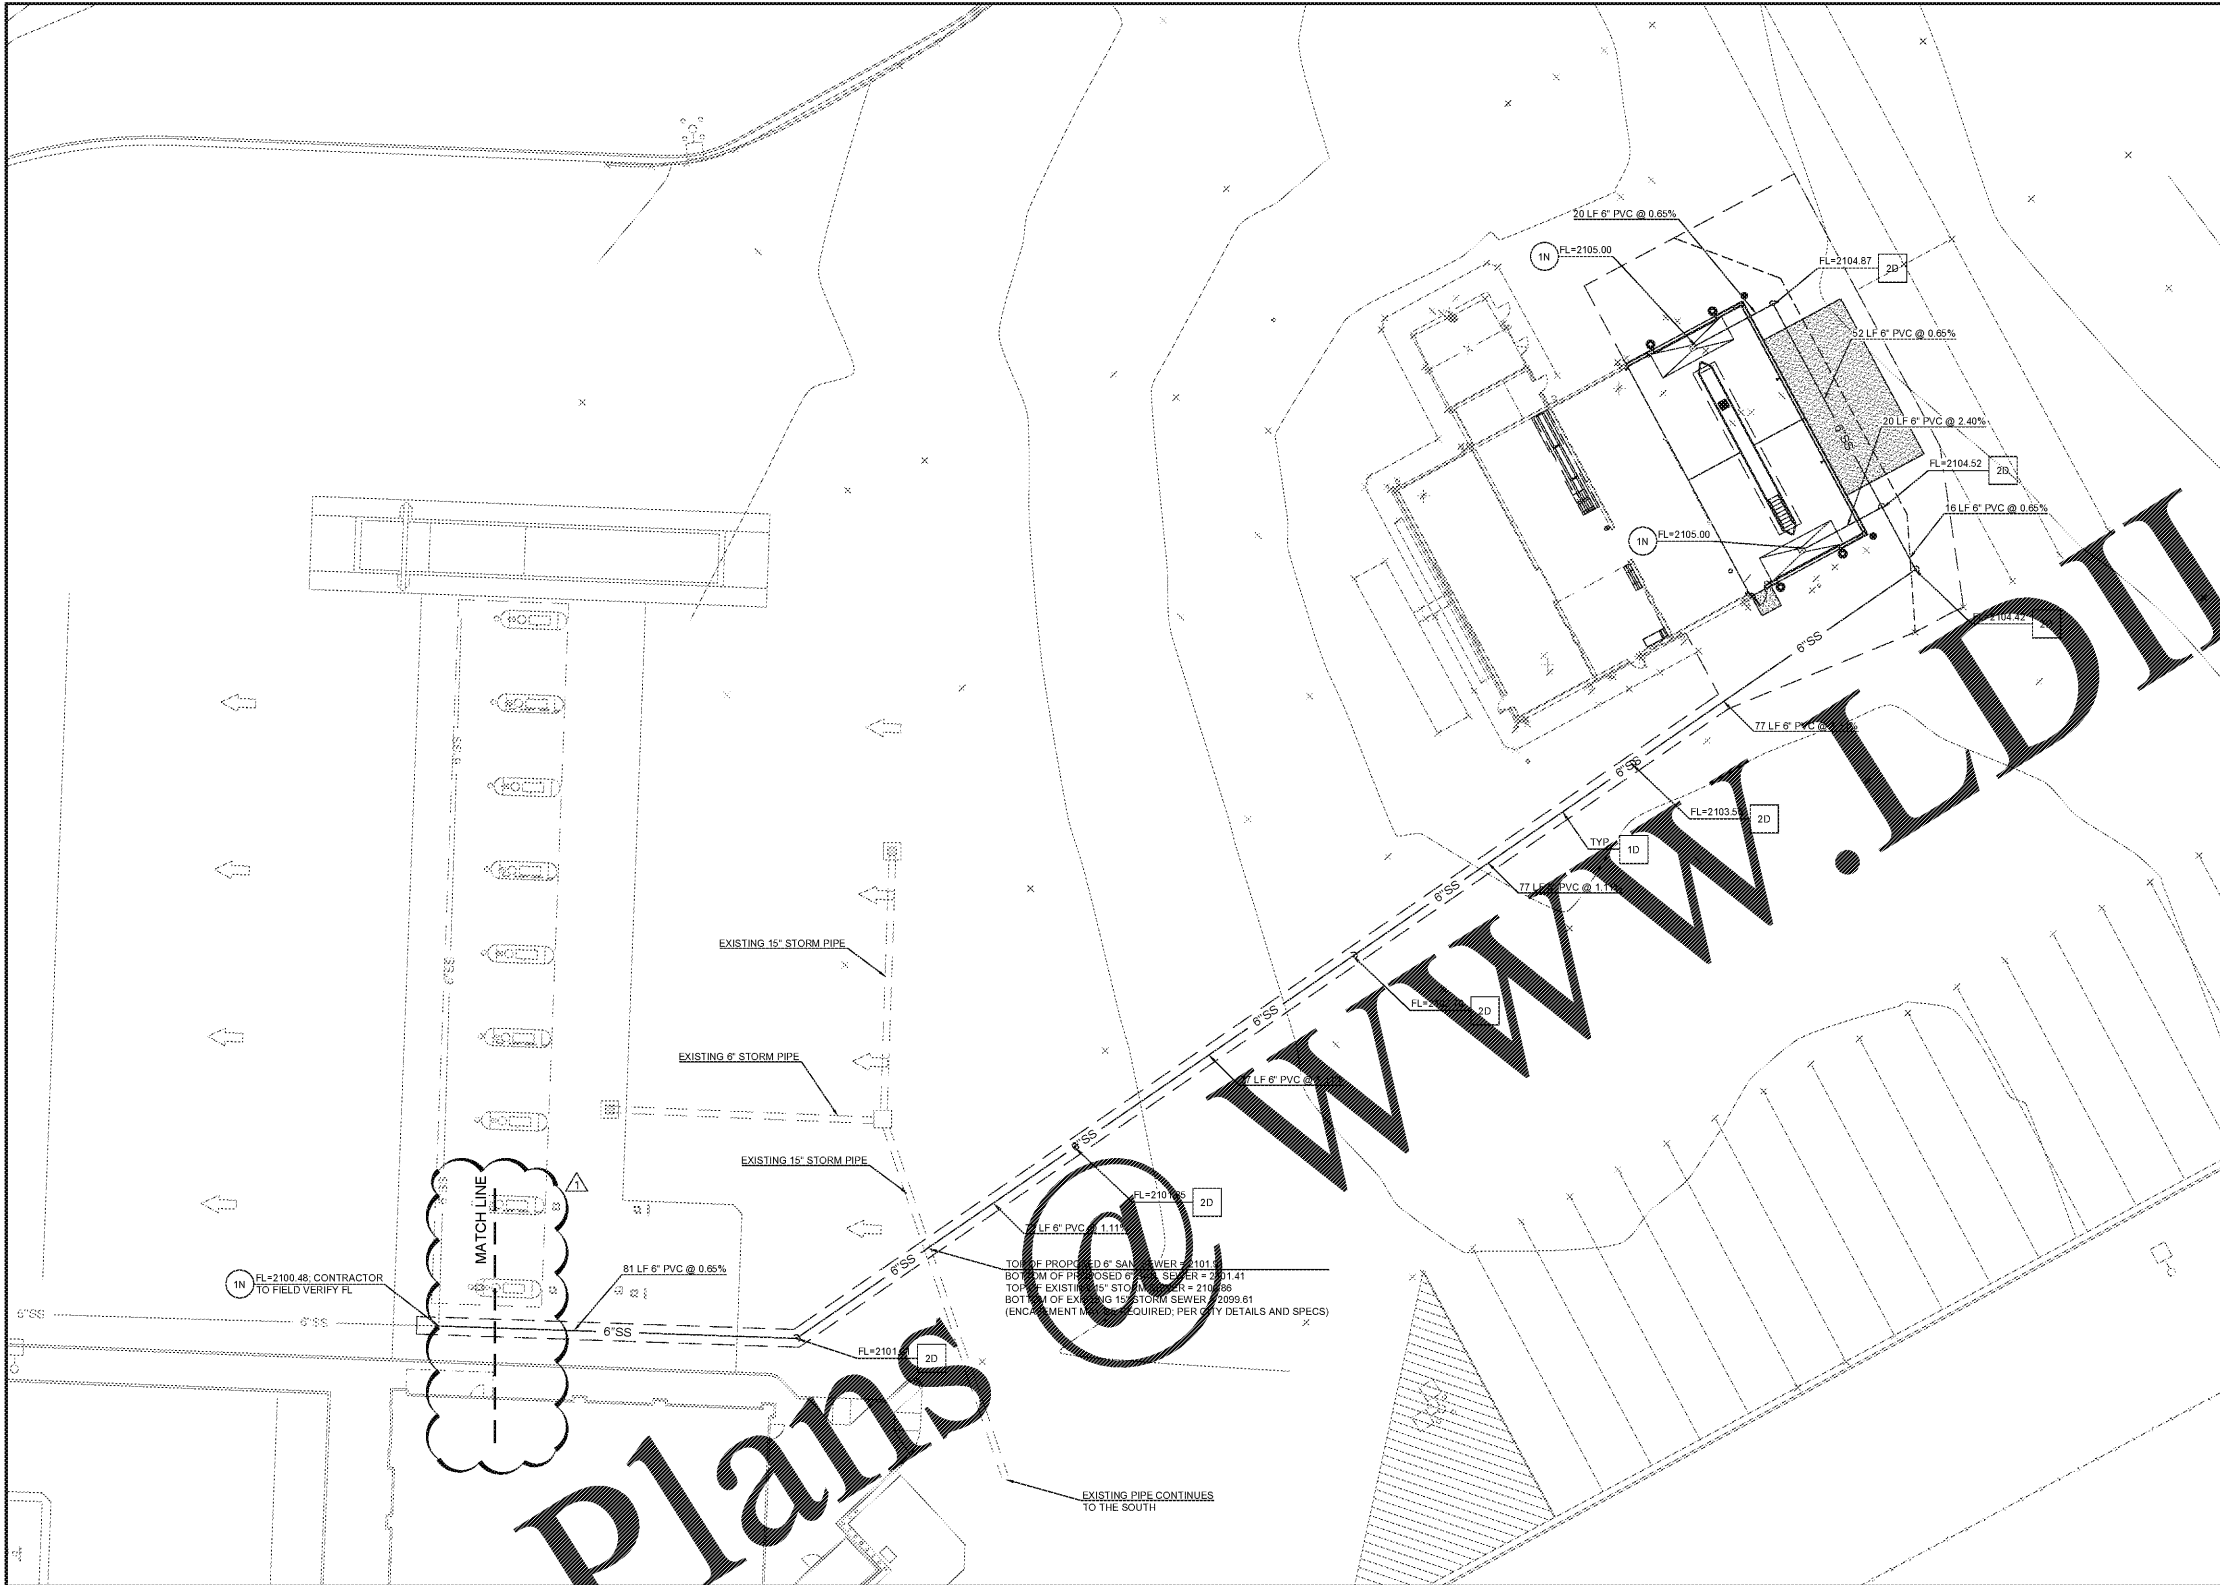

- PROPOSED LEGEND**
- PROPERTY LINE
 - x-x- SANITARY SEWER LINE
- NOTES**
- 1N. CONNECT TO INTERNAL MEP EQUIPMENT; SEE MEP PLANS FOR MORE INFORMATION.
 - 2D. CONNECT TO EXISTING SANITARY SEWER CLEAN OUT.
- DETAILS**
- 1D. UTILITY TRENCH AND BEDDING. SEE DETAIL 3/YCV-3.
 - 2D. SANITARY SEWER CLEAN-OUT (SEE MEP PLANS FOR SCHEDULE). SEE DETAIL 4/YCV-3.

HFA
HARRISON FRENCH & ASSOCIATES, LTD.
 1705 S. Patton Blvd., Suite 3
 Fayetteville, Arkansas 72712
 479.273.7790
 f 888.520.9685
 www.hfs-ae.com

STIPULATION FOR REUSE
 THESE DRAWINGS ARE THE PROPERTY OF HARRISON FRENCH & ASSOCIATES, LTD. AND ARE NOT TO BE REPRODUCED, COPIED, OR TRANSMITTED IN ANY FORM OR BY ANY MEANS, ELECTRONIC OR MECHANICAL, INCLUDING PHOTOCOPYING, RECORDING, OR BY ANY INFORMATION STORAGE AND RETRIEVAL SYSTEM, WITHOUT THE WRITTEN PERMISSION OF HARRISON FRENCH & ASSOCIATES, LTD. FOR USE ON A DIFFERENT PROJECT SITE. THE REPRODUCTION OF THESE DRAWINGS FOR ANY OTHER PROJECT WITHOUT THE WRITTEN PERMISSION OF HARRISON FRENCH & ASSOCIATES, LTD. IS STRICTLY PROHIBITED. THIS DRAWING IS NOT TO BE REPRODUCED OR TRANSMITTED IN ANY FORM OR BY ANY MEANS, ELECTRONIC OR MECHANICAL, INCLUDING PHOTOCOPYING, RECORDING, OR BY ANY INFORMATION STORAGE AND RETRIEVAL SYSTEM, WITHOUT THE WRITTEN PERMISSION OF HARRISON FRENCH & ASSOCIATES, LTD.

13365 GLENBROOK AVE
 MEADOWVIEW, VA 24361
Love's
Travel Stop & Country Stores
 PROJECT NUMBER: 03-18-2013

Love's
Travel Stop & Country Stores

COMMONWEALTH OF VIRGINIA
 DANIEL RYAN GILL
 Lic. No. 54699
 PROFESSIONAL ENGINEER
 from 03/18/2013 to 03/18/2018

ISSUE BLOCK

DESCRIPTION	DATE
O1P	10-25-18
ADD-1	1-11-19

STORE NO. 613
 DOCUMENT DATE: 10/25/2018
 CHECKED BY: DRG
 DRAWN BY: SAB
 PROTO CYCLE:

UTILITY PLAN

SHEET: YCV-2.1