


LIGHTING SCHEDULE			
CODE	DESCRIPTION	MANUFACTURER	PRODUCT
INTERIOR			
A	WALL-WASH FIXTURE TO BE USED AT ACCENT WALL	CONTECH	RL20SA3-3SK-12-D/CTR2002CLR-P (NOTE 7)
B	PROVIDED BY WALK-IN BOX MANUF.	VARIABLES	VARIABLES
C	TRACK LIGHT & HEAD IN 2', 4' & 8' LENGTHS	JUNO	R600L-3SK-BL
LED-4	LED 2X2 RECESSED FIXTURE	CREE	VL22-32J5-SP1 (NOTE 7)
LED-6	2X4 REC. LED FLAT PANEL	LSI	ELFP24-LED-35-UE
LED-7	2X2 REC. LED FLAT PANEL	LSI	ELFP22-LED-35-UE
P1	8' SUSPENDED LINEAR LIGHT FIXTURE	TFC	SES-FR-96L-S62W6200L-DMV-35K-BK (NOTE 7)
P2	4' SUSPENDED LINEAR LIGHT FIXTURE	TFC	SES-FR-48L-S62W3100L-DMV-35K-BK (NOTE 7)
P3	PENDANT CHANDELIER	TECH LIGHTING	7001D-ALVPMW-BB-LED90
R1	6" 2000LM 0-10V LED DOWNLIGHT	HALO	PD620-ED010-B/PDM668J5/61VCMF
R1A	6" 1000LM 0-10V LED DOWNLIGHT	HALO	PD610-ED010-B/PDM668J5/61VCMF (NOTE 7)
R4	ORANGE LINEAR LED SUSPENDED/SURFACE FIXTURE	Pinnacle	EX33A-35HO-XX-AC48J8-120-1C-CC-PM5165
BL	BATHROOM WALL SCONCE (OPTIONAL)	SEAGULL	49170
OC	WALL MOUNTED OCCUPANCY SENSOR - WHITE	WATT STOPPER	WS-250-W
EBU-B	2-HEAD EMERGENCY BATTERY PACK	EXITORNX	EBU-BL-LED-51-52
EBU-W	2-HEAD EMERGENCY BATTERY PACK	EXITORNX	EBU-W-LED-51-52
X	LED EXIT W/ BATTERY	EXITORNX	VEX-U-BP-W6-WH
COMBO	COMBO LED EXIT / (2) HEAD EBU	EXITORNX	VEX-U-BP-W6-WH-EL90
EXTERIOR			
LED-2	EXTERIOR RECESSED DOWNLIGHT	DMF LTD.	DRDH-R-4/DRD2M-10-9-40/DRD2T-R-4-S-W
LED-11	LED UP LIGHT FIXTURE	SOLUTIONS FOR LIGHTING	SSL-LSSL-5135-250 LUMENS
LED-12	LED UP LIGHT FIXTURE	SOLUTIONS FOR LIGHTING	SSL-LSSL-5165-400 LUMENS
C	WALL PACK - REAR DOOR	COOPER	XTOR1A
WSCX-2	GOOSENECK LIGHT FIXTURE	HI-LITE MFG. INC.	H-HDMR16/18-1-119/MR16AD1C2930T-10-S
WSR	WALL PACK - BUILDING	COOPER	XTOR3A

LIGHTING SCHEDULE NOTES

1. PROVIDE ALL FIXTURES COMPLETE WITH LAMPS. REFER TO NATIONAL ACCOUNT SOURCE INFO FOR LAMP SPECS & VILLA LIGHTING RE-LAMPING PROGRAM.
2. ALL BALLASTS SHALL BE HIGH POWER FACTOR.
3. PROVIDE HOLD-DOWN CLIPS FOR EACH CORNER OF LED GRID TROFFERS.
4. COORDINATE AND VERIFY ALL FIXTURE INFORMATION, TYPE AND FINAL LOCATIONS WITH THE REFLECTED CEILING PLAN.
5. LAMPS SHALL BE AS MANUFACTURED BY SYLVANIA, WESTINGHOUSE, GENERAL ELECTRIC OR APPROVED EQUAL.
6. PROVIDE ALL REQUIRED MOUNTING OR HANGING HARDWARE.
7. ALL SUSPENDED FIXTURES AND SURFACE OR RECESSED FIXTURES IN SOFFITS PAINTED [PT-02] SHALL HAVE BLACK TRIM IN LIEU OF WHITE.

- LIGHTING PLAN GENERAL NOTES**
- A. SEE SHEET A-2 FOR LIGHT FIXTURE SCHEDULE, MOUNTING AND FIXTURE LOCATIONS.
 - B. CONTRACTOR IS ADVISED THAT ADJUSTMENTS TO EMERGENCY AND EXIT LIGHT FIXTURE LOCATIONS/QUANTITIES MAY BE REQUIRED BY AHJ UPON FINAL INSPECTION.
 - C. ALL NIGHT LIGHT, EMERGENCY AND EXIT LIGHT FIXTURES SHALL BE CONNECTED AHEAD OF SWITCHED LIGHTING CIRCUIT.
 - D. EXISTING FIXTURES, DENOTED AS 'EX', SHALL BE CLEANED AND RE-LAMPED AS REQUIRED.

- FLOOR PLAN - LIGHTING NOTES**
1. LIGHTING CONTROL RELAY PANEL (CIRCUIT A-20) AS SPECIFIED BY THE LIGHTING VENDOR PROVIDED AND INSTALL DIGITAL SWITCH(ES) AS REQUIRED. LOCATION OF SWITCHES BY ARCHITECT OR OWNER. SEE SCHEDULE ON SHEET E-1A.
 2. WALL MOUNTED OCC SENSOR EQUAL TO HUBBELL LHRS10.
 3. LIGHTING FIXTURES IN KITCHEN AND FOOD HANDLING AREAS SHALL HAVE WATERPROOF LENSES.
 4. LIGHT FIXTURES FURNISHED BY WALK-IN BOX VENDOR. ELECTRICAL CONTRACTOR TO INSTALL AND CONNECT FIXTURES. SEE SHEET E-1A.
 5. EXHAUST FAN FOR RESTROOMS SHALL BE CONTROLLED ON/OFF WITH RESTROOM LIGHTS.
 6. CIRCUIT SHALL BE CONTROLLED BY LIGHTING CONTROL RELAY PANEL. SEE SCHEDULE ON SHEET E-1A.
 7. LINE VOLTAGE LOW TEMP WALL MOUNT OCC SENSOR EQUAL TO WATSON 1901A. PROVIDE UNSWITCHED POWER.

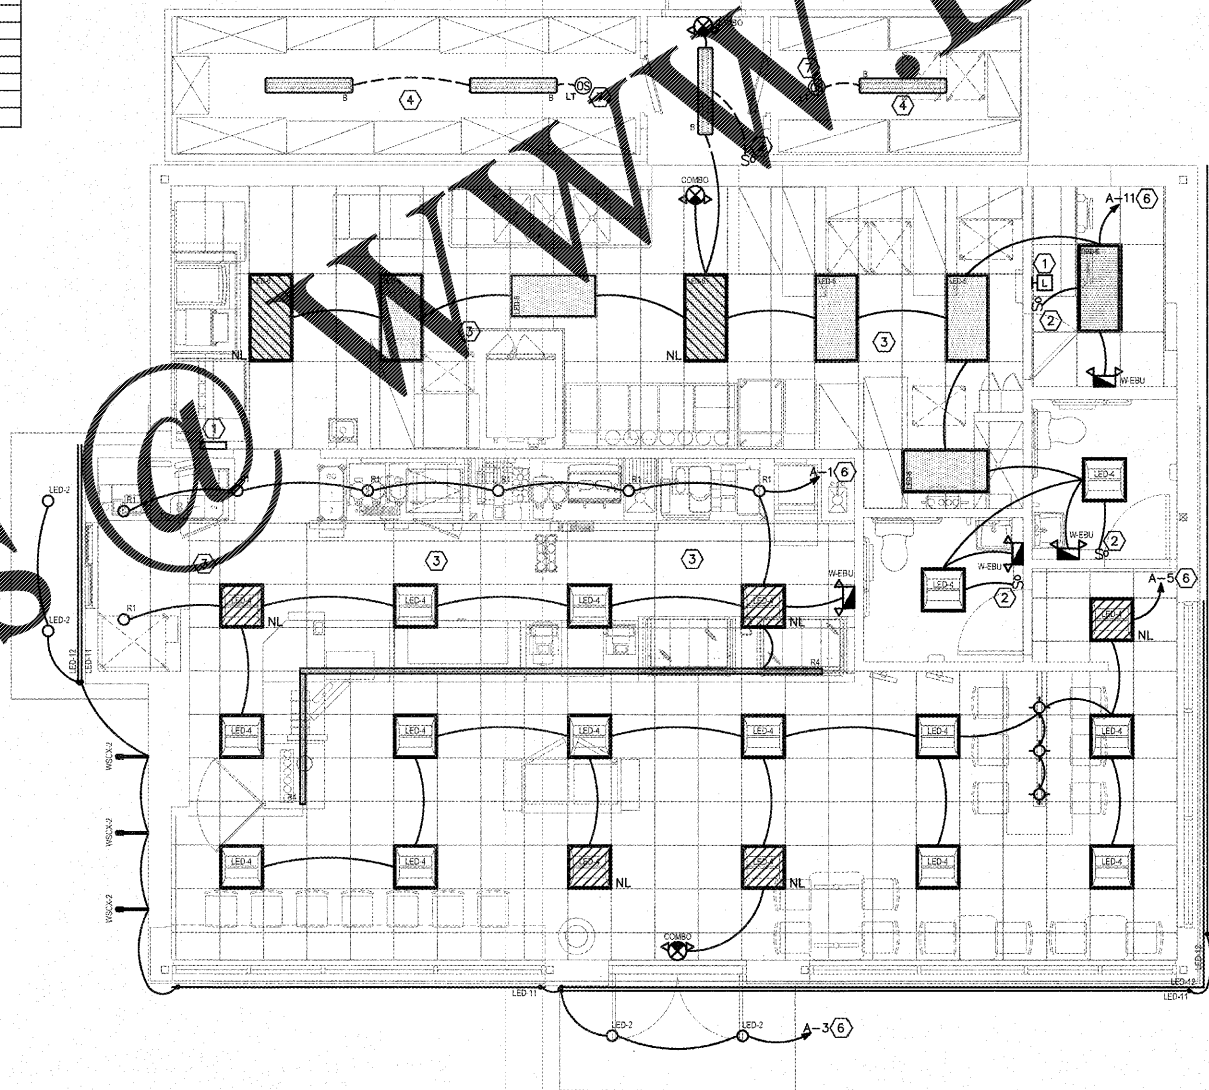

LIGHTING PLAN
 SCALE: 1/4"=1'-0"

Order Plans @ www.lldi.com

Harold Hart, P.E.
 CONSULTING ENGINEER
 9828 W LINEBAUGH AVE • STE 101
 TAMPA, FLORIDA 33626
 Telephone: (813) 287-2719
 Fax: (813) 961-1885
 © 2015 - All Rights Reserved



dunkin'

brand.

STORE #3358032
 US-11W
 BRISTOL, TN

REVISION		
No.	DATE	DESCRIPTION

DWG DATE: 2-1-2019
 DRAWN BY: SC/JAM
 PROJECT No.: 19005
 DWG TITLE:

LIGHTING PLAN