



**ROOF PLAN KEYED NOTES**

- EXISTING ROOF TOP UNIT SHALL REMAIN. ROOF TOP UNIT SHALL BE CONTROLLED VIA HVAC CONTROL PANEL. E.C. SHALL PROVIDE ALL INTERCONNECTION WIRING REQUIRED. COORDINATE INSTALLATION AND WIRING REQUIREMENTS WITH MECHANICAL CONTRACTOR.
- COORDINATE EXACT LOCATION OF HVAC EQUIPMENT ON ROOF WITH MECHANICAL CONTRACTOR.
- SEE POWER PLAN AND LIGHTING PLAN FOR WIRING AND CONTROL OF EXHAUST FANS.

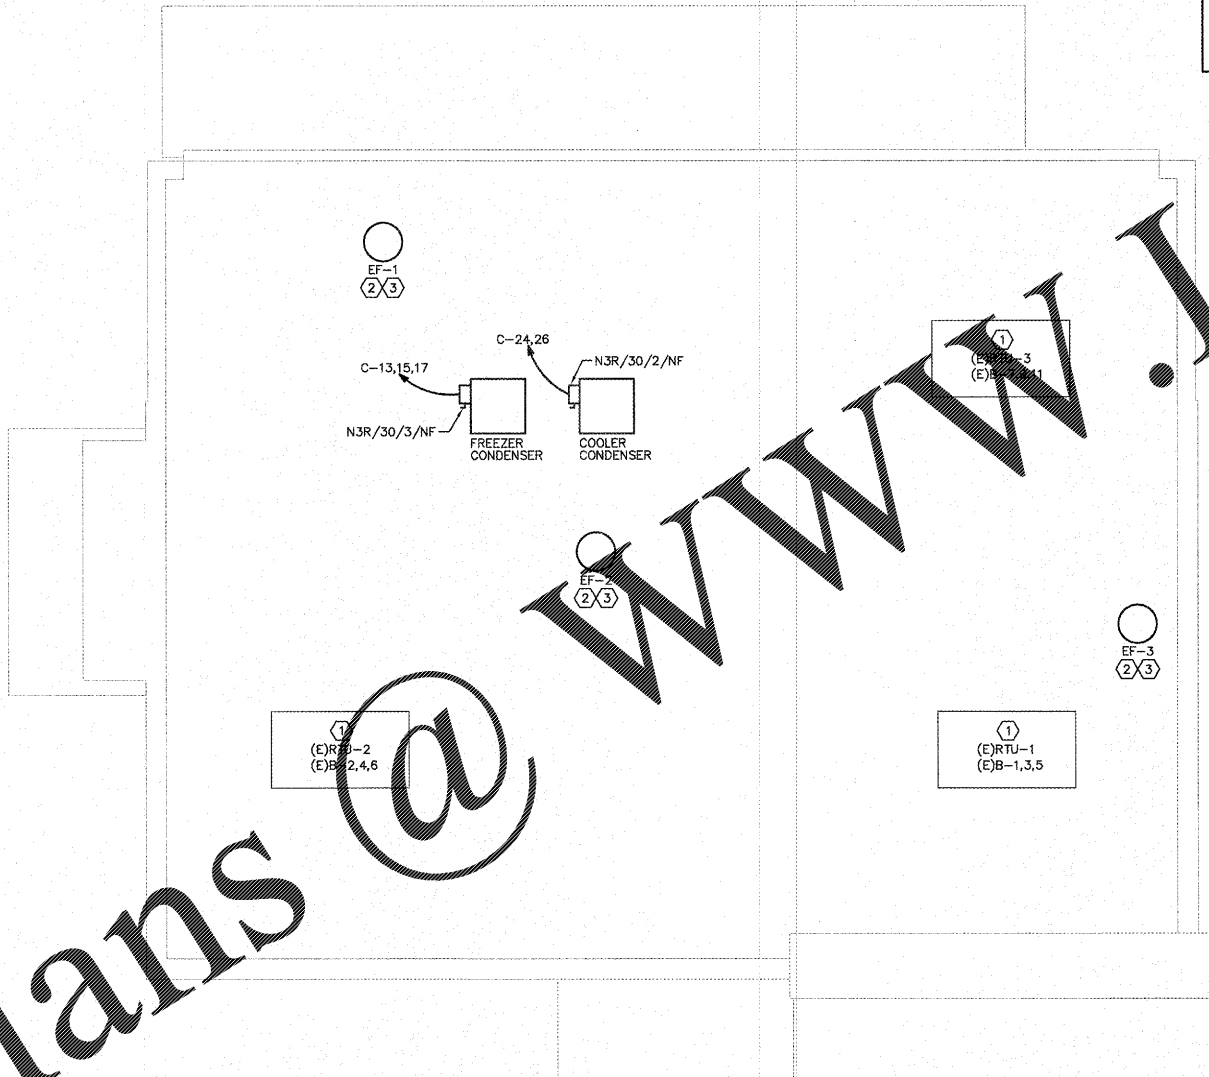

**ROOF PLAN - POWER**  
 SCALE: 1/4"=1'-0"

Harold Hart, P.E.  
 CONSULTING ENGINEER  
 8928 W. LINEBAUGH AVE. • STE. 101  
 TAMPA, FLORIDA 33625  
 Telephone: (813) 287-2719  
 Fax: (813) 287-1565  
 © 2019 - All Rights Reserved

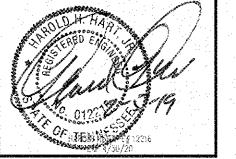

**dunkin'**  
 brands  
 STORE #3358032  
 US-11W  
 BRISTOL, TN

REVISION		
No.	DATE	DESCRIPTION

DWG DATE: 2-1-2019  
 DRAWN BY: SC/AM  
 PROJECT No.: 19035  
 DWG TITLE:

**ROOF PLAN - POWER**

SHEET No.  
**E-4**

Order Plans @ [www.LDILine.com](http://www.LDILine.com)