


NO	REVISION / SUBMISSIONS	DATE

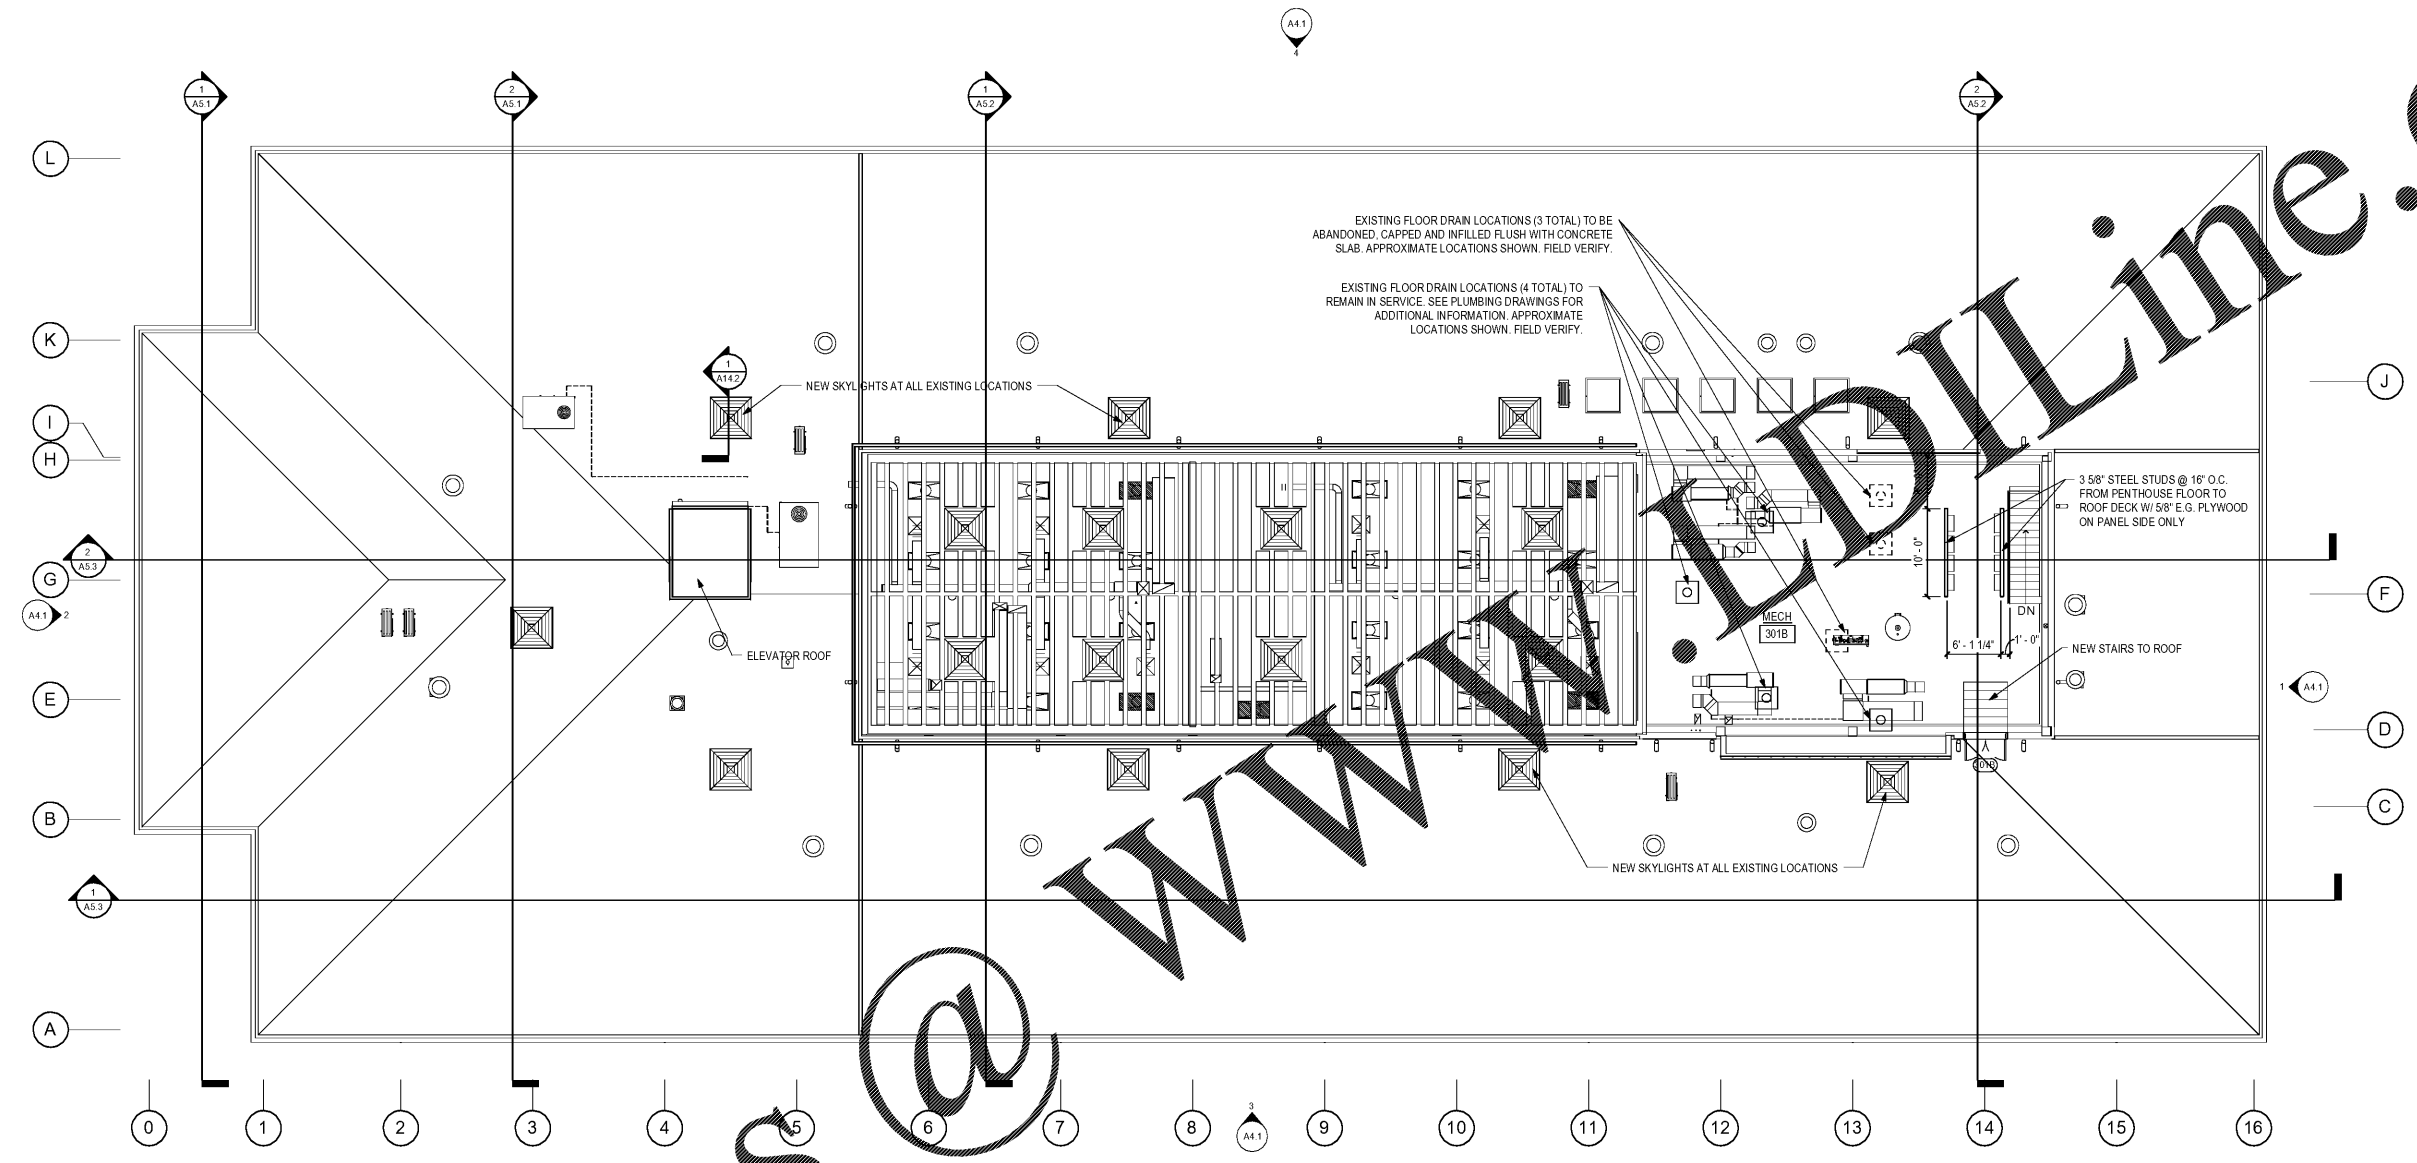

**1 PENTHOUSE FLOOR PLAN - RENOVATION**  
 A2.3 SCALE: 1/8" = 1'-0"

JOHN A. TUTEN & ASSOCIATES  
 ARCHITECTS  
 4680 U.S. HIGHWAY 17  
 BRUNSWICK, GEORGIA 31525  
 www.jatuten.com

GLYNN ACADEMY HIGH SCHOOL  
 SCIENCE BLDG. (5015) MODERNIZATION  
 1001 MANSFIELD ST. BRUNSWICK GA, 31520  
 GLYNN COUNTY BOARD OF EDUCATION

CAPITAL OUTLAY  
 PROJECT # TRD  
 SYSTEM CODE: 663  
 SCHOOL CODE: 4752  
 FTE: 1796

PENTHOUSE FLOOR PLAN - RENOVATION



ISSUED FOR:  
 BID SET

DRAWN BY:  
 CHECKED BY:  
 APPROVED BY:  
 01/19/19  
 PROJECT DATE:  
 1802  
 PROJECT NUMBER

SHEET  
 NUMBER:  
**A2.3**

Copyright (c) 2019  
 All Rights Reserved

1/18/2019 11:22:44 AM C:\Users\jmt\Documents\Projects\Local\1802\_GA\_Science Building\1802\_Science Building.gm1.rvt

Order Plans @ WWW.DownloadLine.com