



NO	REVISION / SUBMISSIONS	DATE

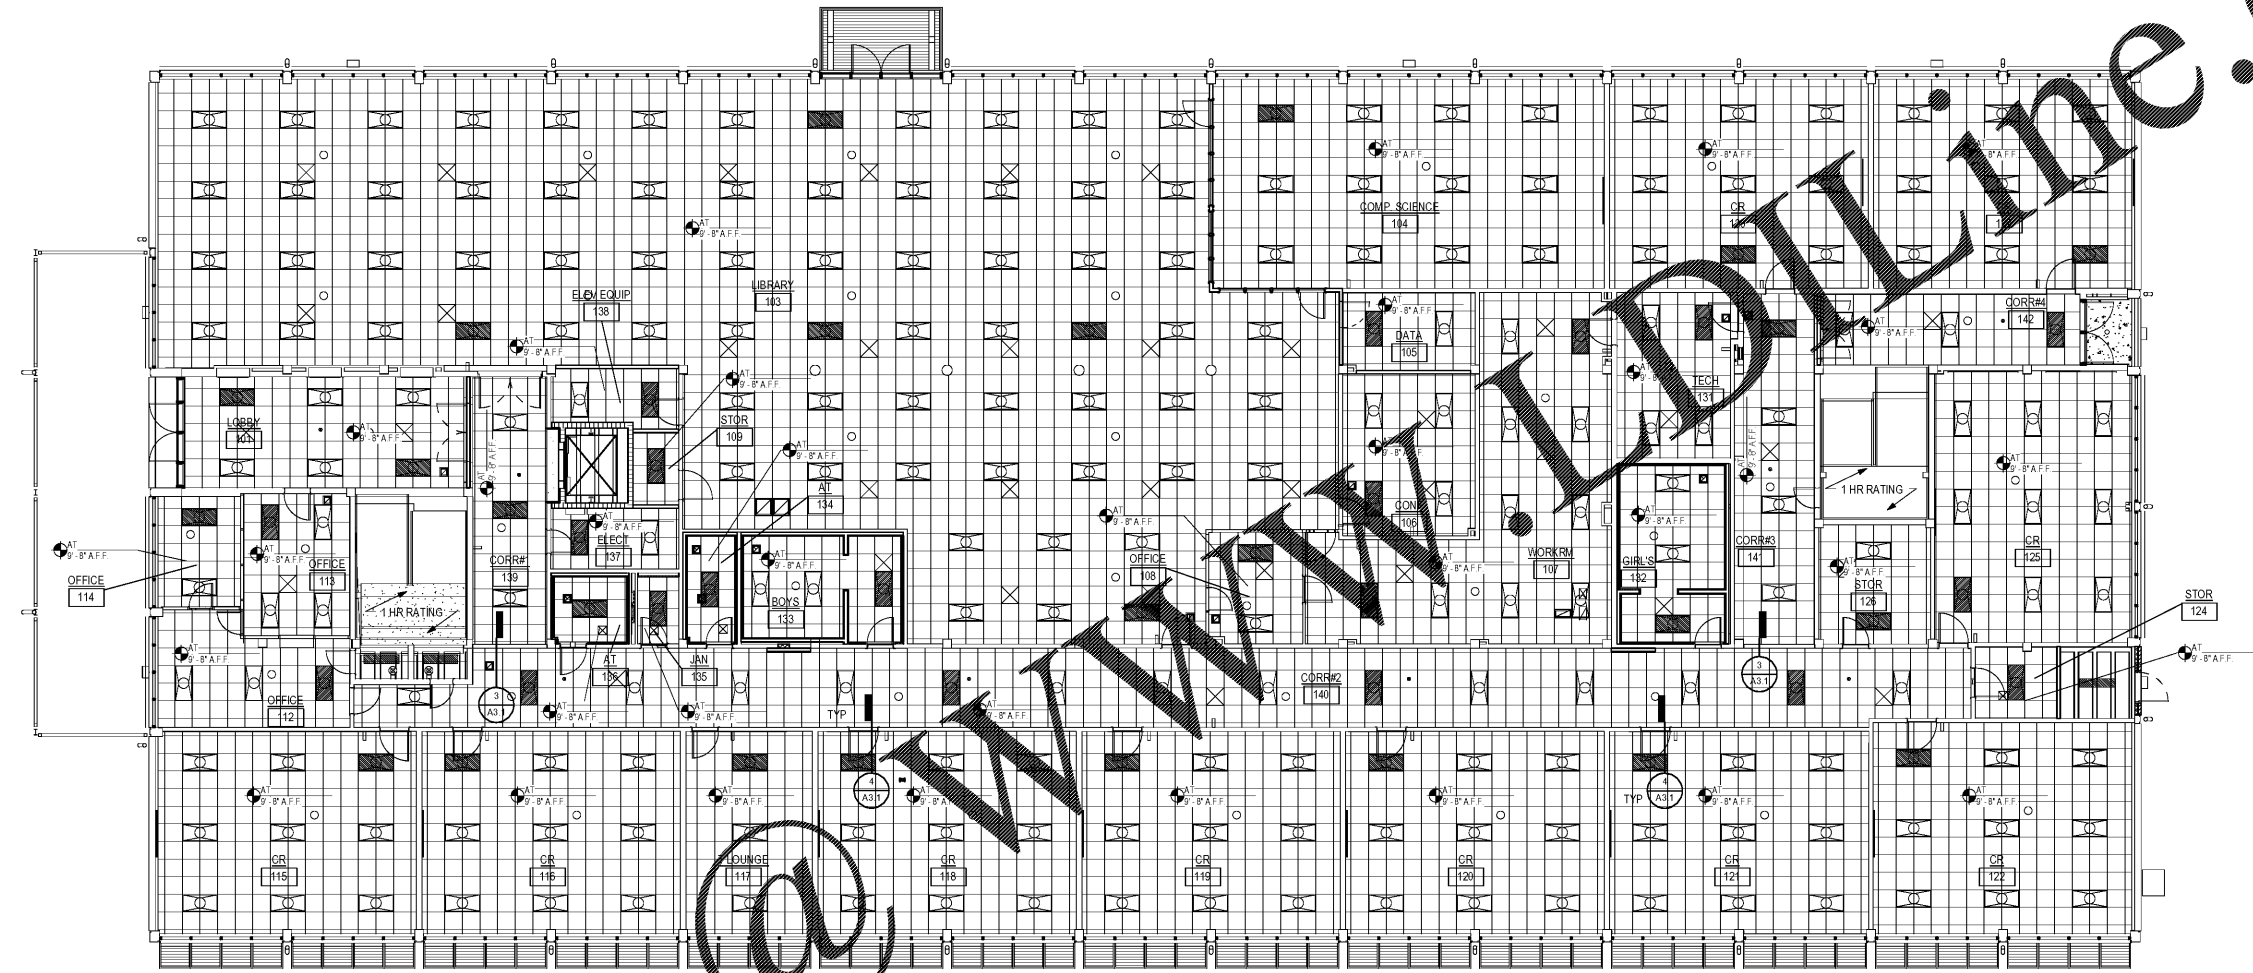

1 FIRST FLOOR REFLECTED CEILING PLAN  
 A2.4 SCALE: 1/8" = 1'-0"

Order Plans

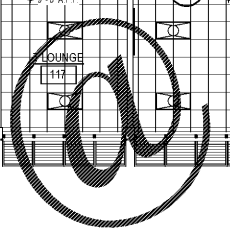

www.orderplans.com

JOHN A. TUTEN & ASSOCIATES  
 ARCHITECTS  
 4680 U.S. HIGHWAY 17  
 BRUNSWICK, GEORGIA 31525  
 www.jatuten.com

GLYNN ACADEMY HIGH SCHOOL  
 SCIENCE BLDG. (5015) MODERNIZATION  
 1001 MANSFIELD ST. BRUNSWICK GA, 31520  
 GLYNN COUNTY BOARD OF EDUCATION

CAPITAL OUTLAY  
 PROJECT # TBD  
 SYSTEM CODE: 663  
 SCHOOL CODE: 0752  
 FTE: 1796

FIRST FLOOR REFLECTED CEILING PLAN



ISSUED FOR:  
 BID SET

DRAWN BY:  
 CHECKED BY:  
 APPROVED BY:  
 01/19/19  
 PROJECT DATE:  
 1802  
 PROJECT NUMBER

SHEET  
 NUMBER:  
 A2.4

Copyright (c) 2019  
 All Rights Reserved