

NO	REVISION / SUBMISSIONS	DATE

PLUMBING REFERENCE NOTES

- REFER TO SHEET P6.01-P6.03 FOR PLUMBING DETAILS.
- REFER TO SHEET P6.01 FOR PLUMBING NOTES, SYMBOLS, AND SCHEDULES.
- REFER TO SHEET P7.01 FOR PLUMBING RISER DIAGRAMS.

NOTES BY SYMBOL


- REFER TO SHEET P1.01 FOR CONTINUATION.
- 1" CW AND 3/4" GAS PIPING UP TO ABOVE. REFER TO SHEET P2.02 FOR CONTINUATION.
- 1-1/4" CW UP TO EMERGENCY EYE WASH. REFER TO SHEET P2.02 FOR CONTINUATION.
- SOLENOID VALVES FOR WATER/GAS INTERLOCKED WITH EMERGENCY EYE WASH PUSHBUTTON. REFER TO SHEET P2.02 FOR MORE INFORMATION. COORDINATE ALL REQUIREMENTS WITH ELECTRICAL CONTRACTOR.
- 4" FIRE WATER SERVICE FROM BACKFLOW PREVENTION REQUIRED BY LOCAL AUTHORITY AND PROVIDE ENCLOSURE AND VALVES AS REQUIRED. REFER TO CIVIL DRAWINGS FOR CONSULTATION.
- 1" CW FROM MECH FLOOR TO ABOVE.
- FIRE PROTECTION SYSTEM RISER AREA.
- 2-1/2" DOMESTIC WATER SERVICE ENTRY. REFER TO CIVIL DRAWINGS FOR CONSULTATION.
- NEW FIRE PROTECTION WATER LINE TO REMOTE FDC LOCATION.

JOHN A. TUTEN & ASSOCIATES
ARCHITECTS
4680 U.S. HIGHWAY 17 NORTH
BRUNSWICK, GEORGIA 31525
www.planters.com

GLYNN ACADEMY HIGH SCHOOL
SCIENCE BLDG. (5015) MODERNIZATION
1001 MANSFIELD ST. BRUNSWICK GA, 31520
GLYNN COUNTY BOARD OF EDUCATION

CAPITAL OUTLAY
PROJECT # TBD
SYSTEM CODE: 668
SCHOOL CODE: 4752
FTE: 1793

PLUMBING PLAN - LEVEL 1

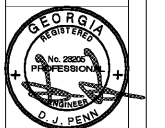


ISSUED FOR:
BID SET

JV, MP
DRAWN BY
DPCE
CHECKED BY
DJP
APPROVED BY
01/19/19
PROJECT NO.
1802
PROJECT NUMBER

SHEET NUMBER:
P2.01

dpce DON PENN CONSULTING ENGINEER
1301 BELLANA BLVD.
SUITE 11 SUITE 1400
WEBB LAKE, TX 75280
© 817-412-2588 | F 817-251-8411

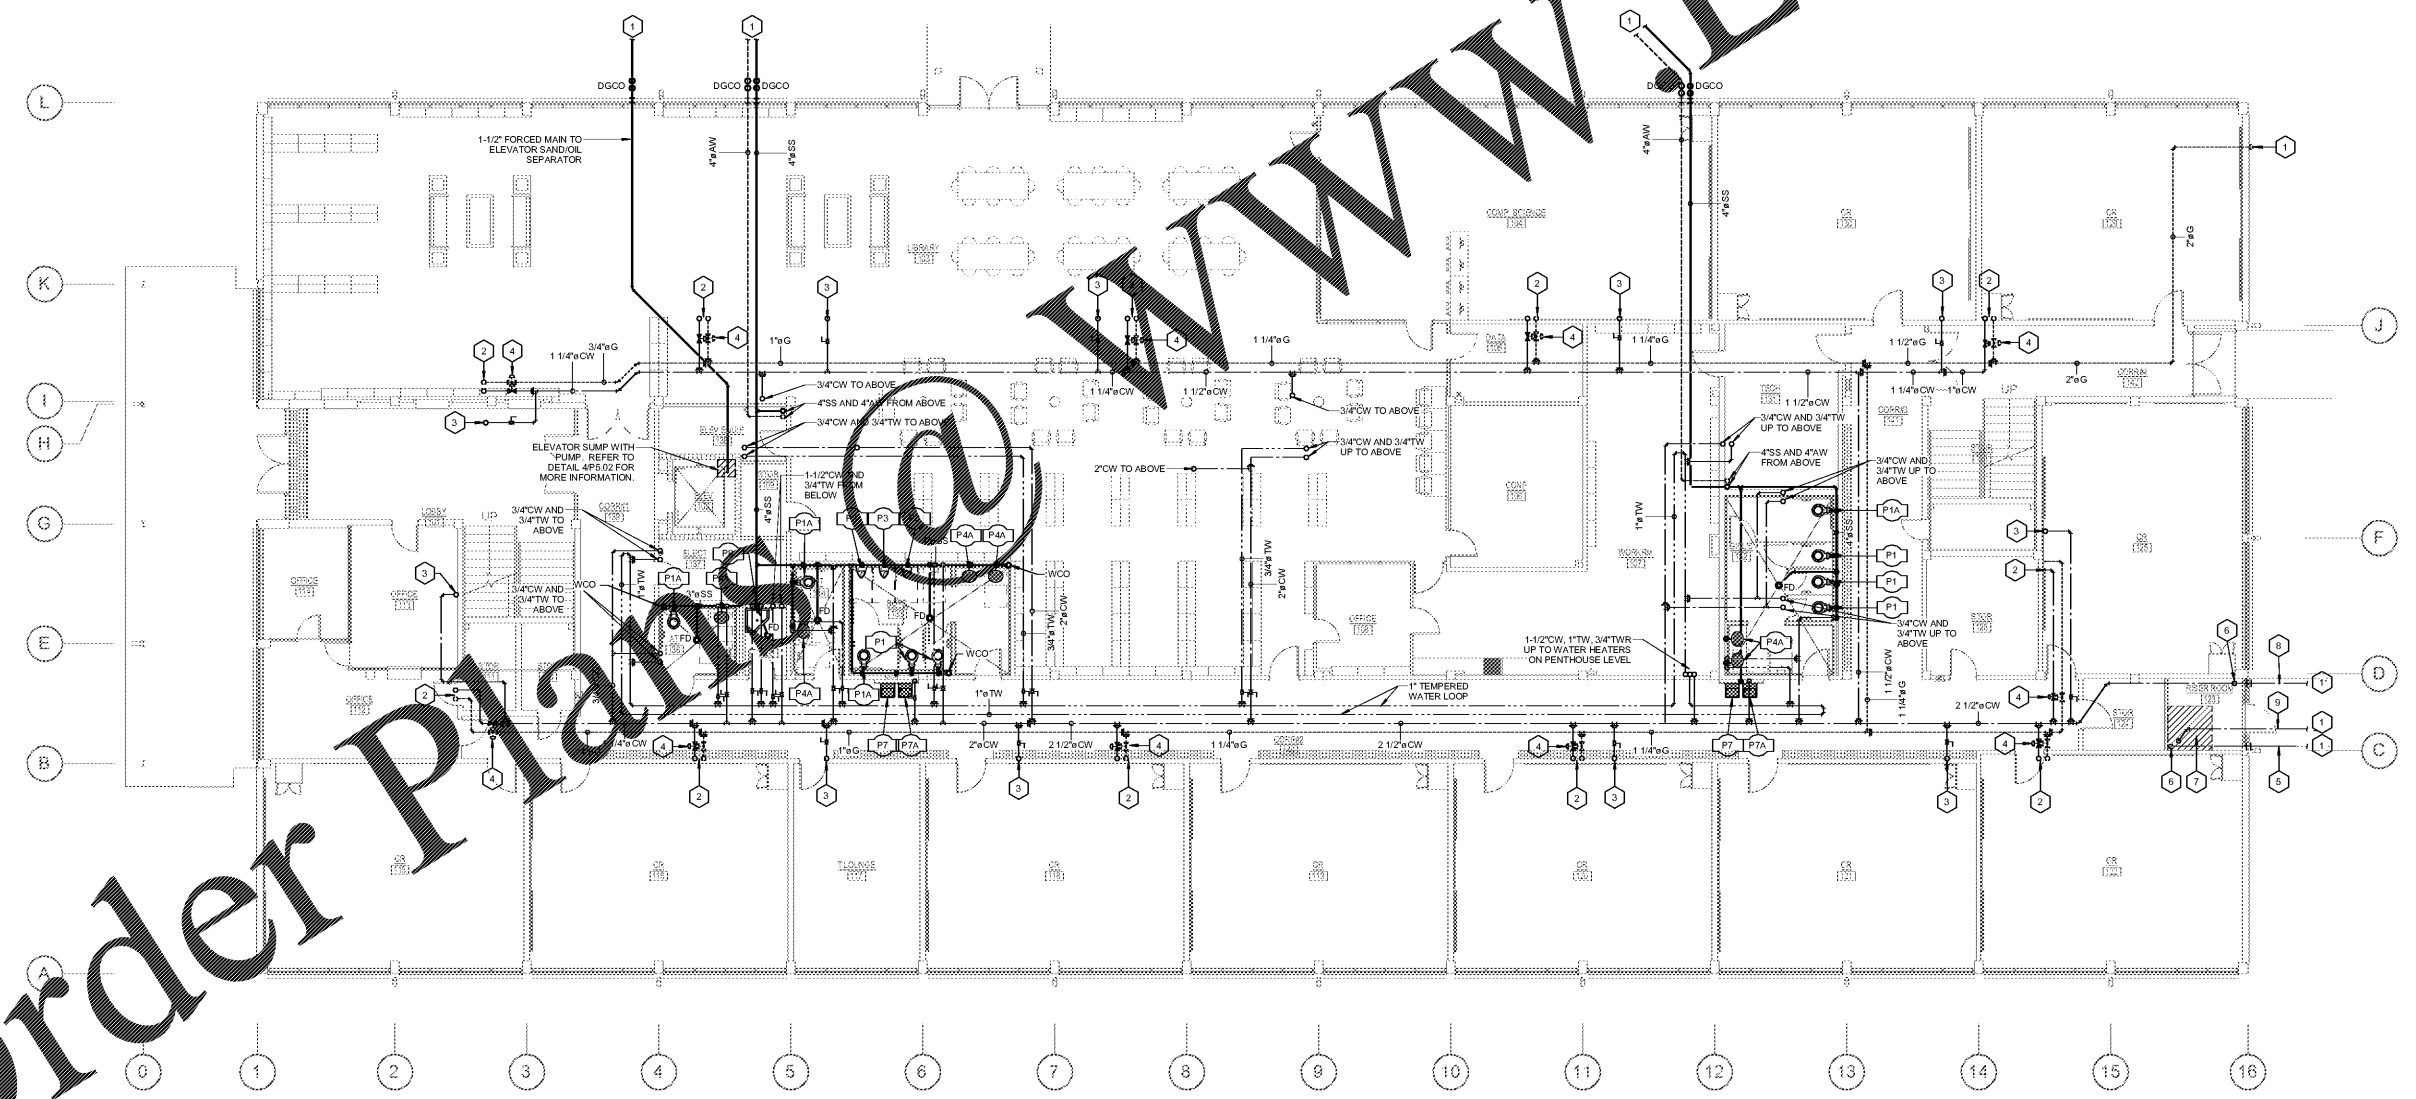

1 PLUMBING PLAN - LEVEL 1
P2.01 SCALE: 1/8" = 1'-0"

1/17/2019 3:07:23 PM C:\Users\jrtutent\Documents\17-2016 GA SCIENCE BUILDING MEP\2016 mplanhd.ESD