

NO	REVISION / SUBMISSIONS	DATE

PLUMBING REFERENCE NOTES

- REFER TO SHEET P6.01-P6.03 FOR PLUMBING DETAILS.
- REFER TO SHEET P6.01 FOR PLUMBING NOTES, SYMBOLS, AND SCHEDULES.
- REFER TO SHEET P7.01 FOR PLUMBING RISER DIAGRAMS.

JOHN A. TUTEN & ASSOCIATES
 ARCHITECTS
 4680 U.S. HIGHWAY 17 NORTH
 BRUNSWICK, GEORGIA 31525
 www.jatuten.com

GLYNN ACADEMY HIGH SCHOOL
 SCIENCE BLDG. (5015) MODERNIZATION
 1001 MANSFIELD ST. BRUNSWICK GA, 31520
 GLYNN COUNTY BOARD OF EDUCATION

CAPITAL OUTLAY
 PROJECT # TBD
 SYSTEM CODE: 668
 SCHOOL CODE: 4752
 FTE: 1793

PLUMBING PLAN - PENTHOUSE




ISSUED FOR:
 BID SET

JV, MP
 DRAWN BY
 DPCE
 CHECKED BY
 DJP
 APPROVED BY
 01/19/19
 PROJECT DATE
 1802
 PROJECT NUMBER

SHEET NUMBER:
P2.03

Copyright (c) 2019
 All Rights Reserved.

dpce
 DON PENN CONSULTING ENGINEER
 1001 BELLANA BLVD.
 SUITE 110
 WEB LAKE, TX 75982
 P 409.412.2588 F 409.412.2581

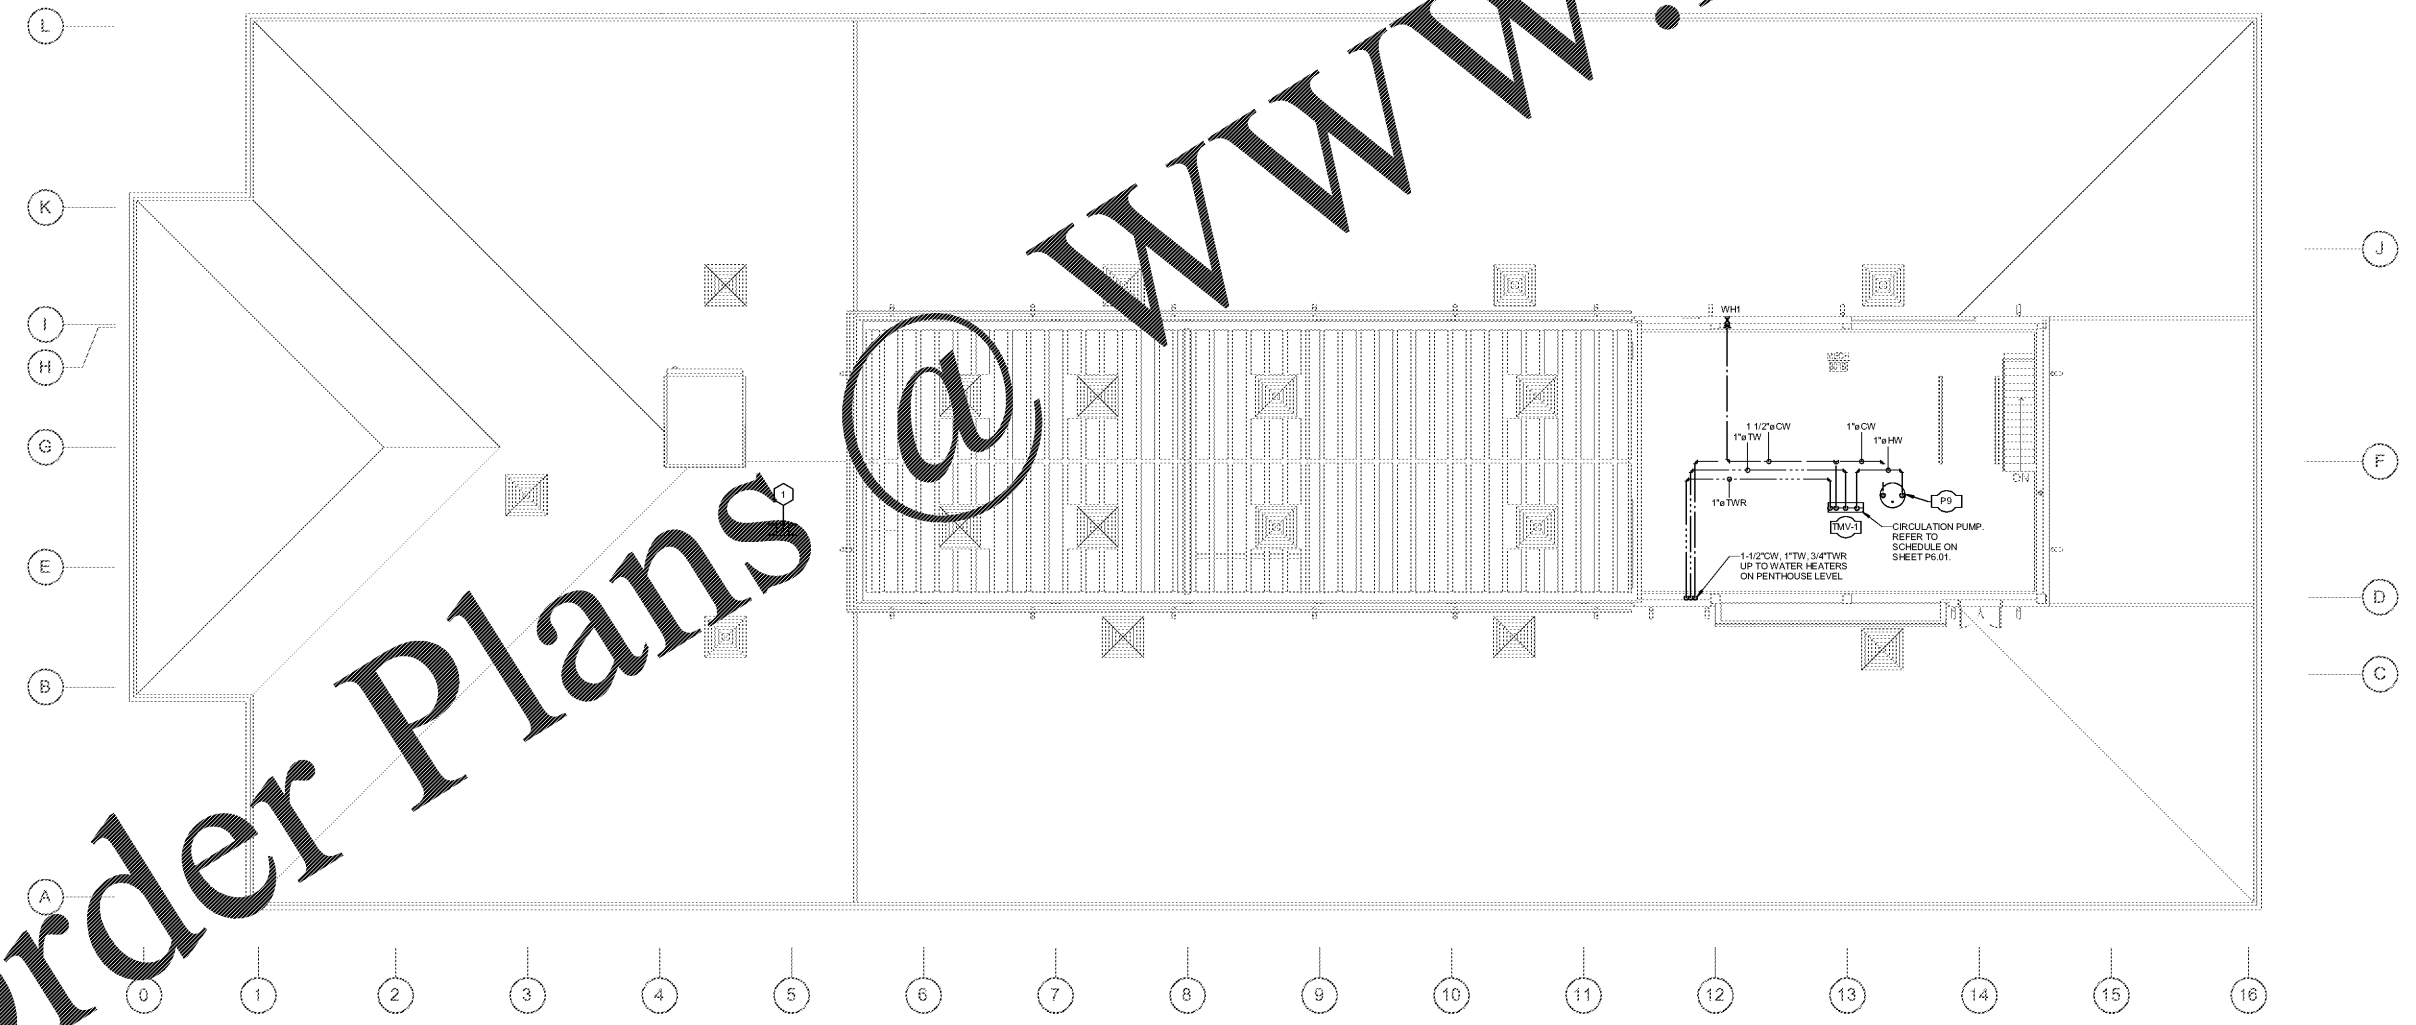

1 PLUMBING PLAN - PENTHOUSE
 P2.03 SCALE: 1/8" = 1'-0"

1/15/2019 4:15:40 PM C:\Users\jvatute\Documents\17-2015_GA SCIENCE BUILDING MEP\2016_jvatute.dwg

Order Plans @ www.LDILine.com