

NO	REVISION / SUBMISSIONS	DATE

JOHN A. TUTTEN & ASSOCIATES  
 ARCHITECTS  
 4680 U.S. HIGHWAY 17 NORTH  
 BRUNSWICK, GEORGIA 31525  
 www.jatuten.com

GLYNN ACADEMY HIGH SCHOOL  
 SCIENCE BLDG. (5015) MODERNIZATION  
 1001 MANSFIELD ST. BRUNSWICK GA, 31520  
 GLYNN COUNTY BOARD OF EDUCATION

CAPITAL OUTLAY  
 PROJECT # TBD  
 SYSTEM CODE: 663  
 SCHOOL CODE: 4752  
 FTE: 1793

PLUMBING DETAILS




ISSUED FOR:  
 BID SET


JV, MP  
 DRAWN BY  
 DPCE  
 CHECKED BY  
 DJP  
 APPROVED BY  
 01/18/19  
 PROJECT NO.  
 1802  
 PROJECT NUMBER

SHEET NUMBER:  
**P5.01**


Copyright (c) 2019  
 All Rights Reserved.

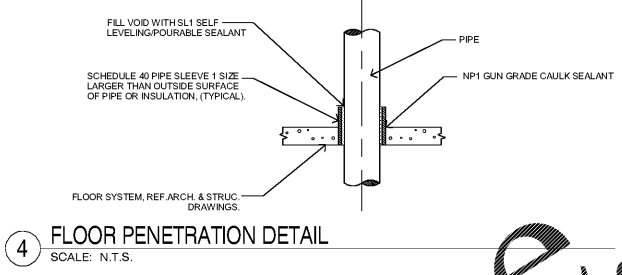


4 FLOOR PENETRATION DETAIL  
 SCALE: N.T.S.

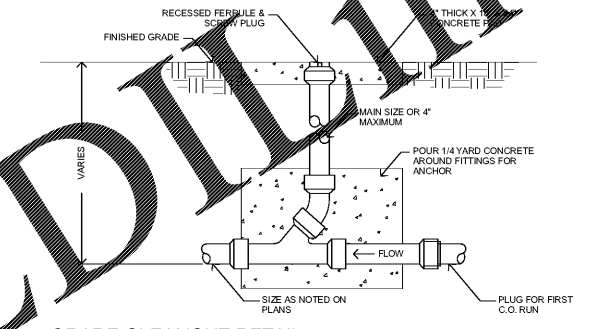


3 GRADE CLEANOUT DETAIL  
 SCALE: N.T.S.

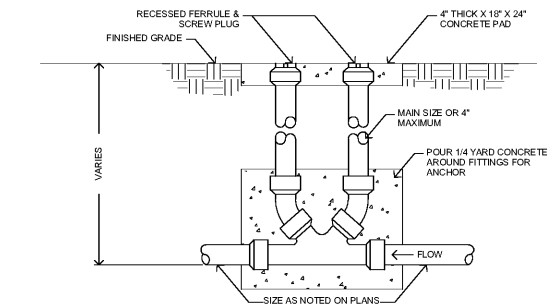


2 TWO-WAY GRADE CLEANOUT DETAIL  
 SCALE: N.T.S.

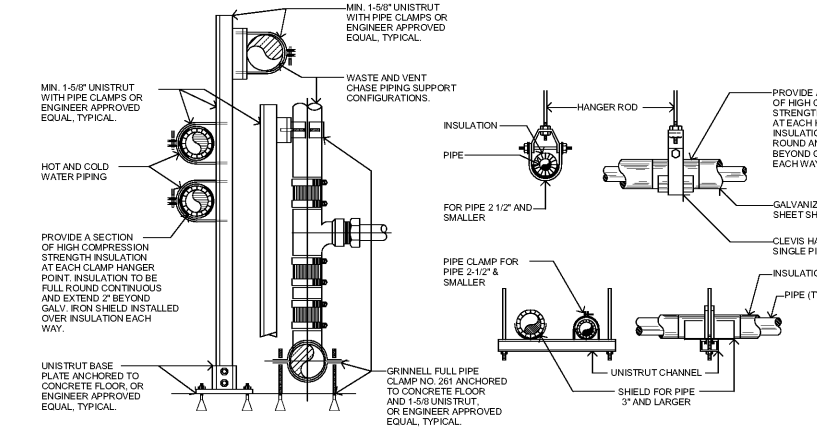


1 WATER, WASTE AND VENT PIPING HANGERS & SUPPORTS DETAIL  
 SCALE: N.T.S.

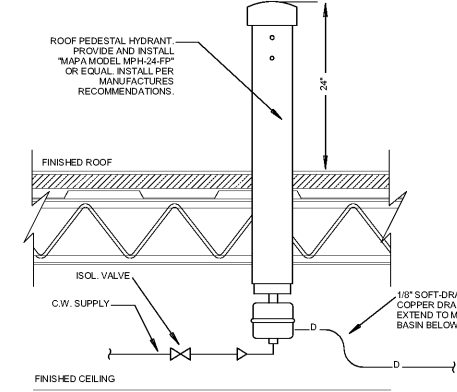


10 NON FREEZE ROOF HYDRANT  
 SCALE: N.T.S.

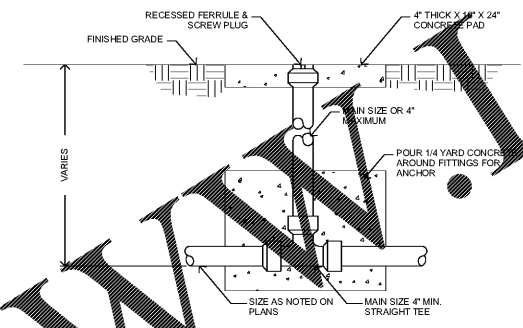


8 SAMPLE TEE DETAIL  
 SCALE: N.T.S.

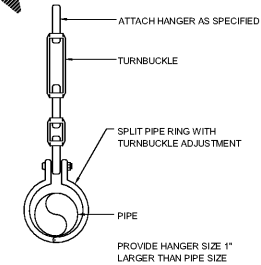


6 PIPE HANGER DETAIL  
 SCALE: N.T.S.

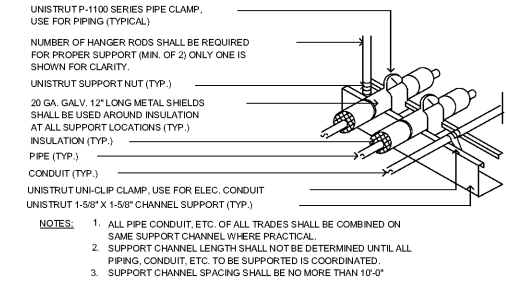


11 PIPING SUPPORT ABOVE CEILING DETAIL  
 SCALE: N.T.S.

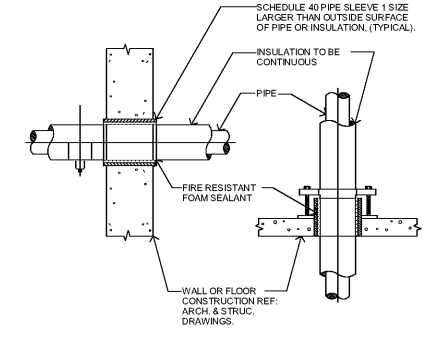

9 PIPE SLEEVE DETAILS  
 SCALE: N.T.S.

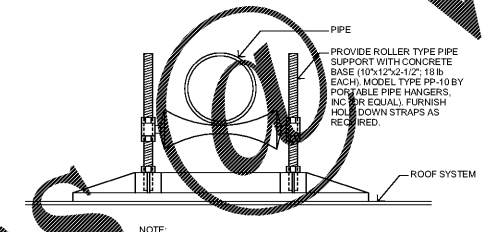


7 ROOF PIPE SUPPORT DETAIL  
 SCALE: N.T.S.

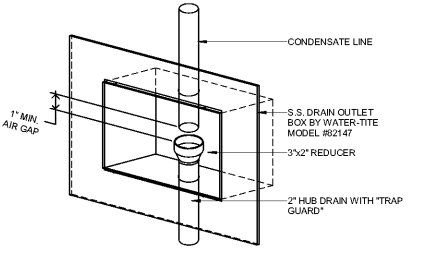


13 CONDENSATE HUB DRAIN DETAIL  
 SCALE: N.T.S.

NOTES BY SYMBOL

1	THERMOSTATIC MIXING VALVE. REFER TO SPECIFICATION SECTION 22 1000.
2	TEMPERED WATER CIRCULATOR. REFER TO SPECIFICATION SECTION 22 1000. COORDINATE POWER REQUIREMENTS WITH ELECTRICAL CONTRACTOR. PROVIDE WITH 24 HOUR (ASTRONOMICAL) TIMER FOR CONTROL.

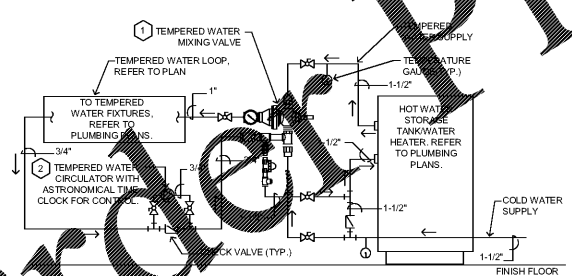

12 HOT / TEMPERED WATER PIPING DETAIL (RADA 40R)  
 SCALE: N.T.S.

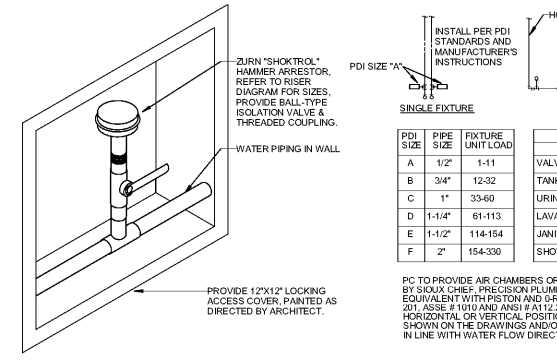

5 WATER HAMMER ARRESTOR DETAIL WITH SIZING CHART  
 SCALE: N.T.S.

1/15/2019 4:15:55 PM C:\Users\jacob.c...m17-2015\_GA SCIENCE BUILDING MEPV2016\_jacob.ied.rvt

Order Plans

WWW.LDOnline.com