

NO	REVISION / SUBMISSIONS	DATE

JOHN A. TUTEN & ASSOCIATES
 ARCHITECTS
 4680 U.S. HIGHWAY 17 NORTH
 BRUNSWICK, GEORGIA 31525
 www.jatuten.com

GLYNN ACADEMY HIGH SCHOOL
 SCIENCE BLDG. (5015) MODERNIZATION
 1001 MANSFIELD ST. BRUNSWICK GA, 31520
 GLYNN COUNTY BOARD OF EDUCATION

CAPITAL OUTLAY
 PROJECT # TBD
 SYSTEM CODE: 668
 SCHOOL CODE: 4752
 FTE: 1793

PLUMBING DETAILS




ISSUED FOR:
 BID SET


J.V. MP
 DRAWN BY
 DPCE
 CHECKED BY
 DJP
 APPROVED BY
 01/19/19
 PROJECT DATE
 1802
 PROJECT NUMBER

SHEET NUMBER:
P5.03


Copyright (c) 2019
 All Rights Reserved.

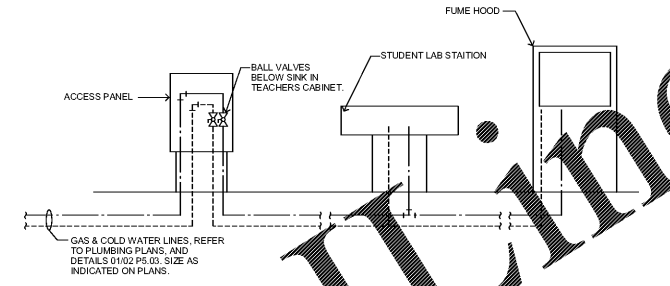


3 SCIENCE LAB VALVE DETAIL
 SCALE: N.T.S.

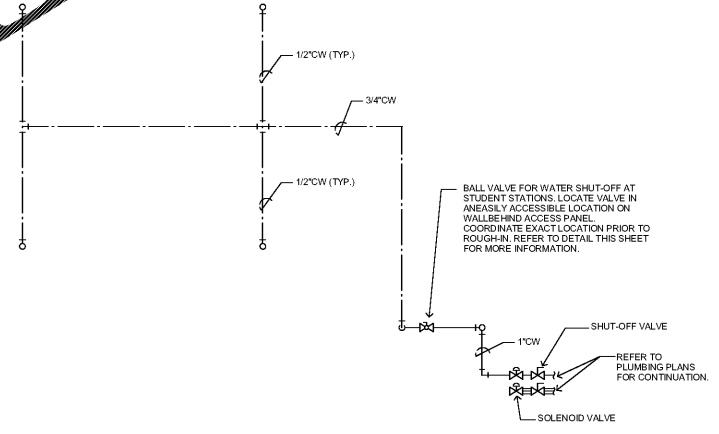

2 SCIENCE LAB WATER SUPPLY - SCHEMATIC DIAGRAM
 SCALE: N.T.S.

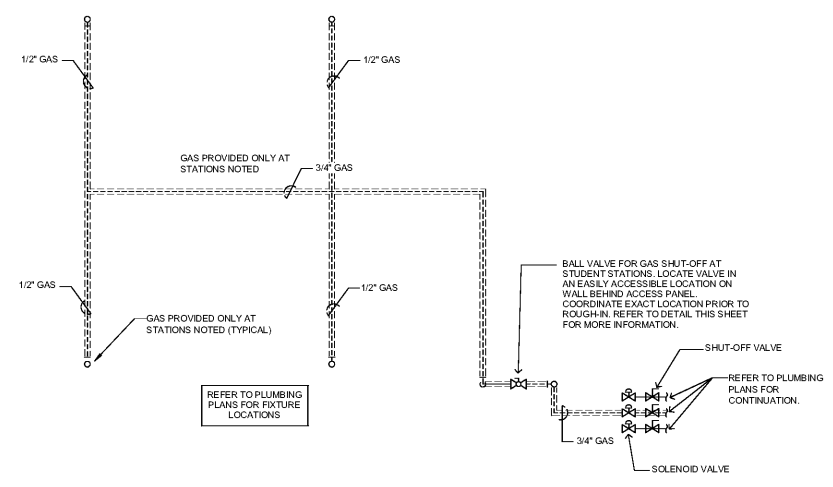

1 SCIENCE LAB GAS SUPPLY - SCHEMATIC DIAGRAM
 SCALE: N.T.S.

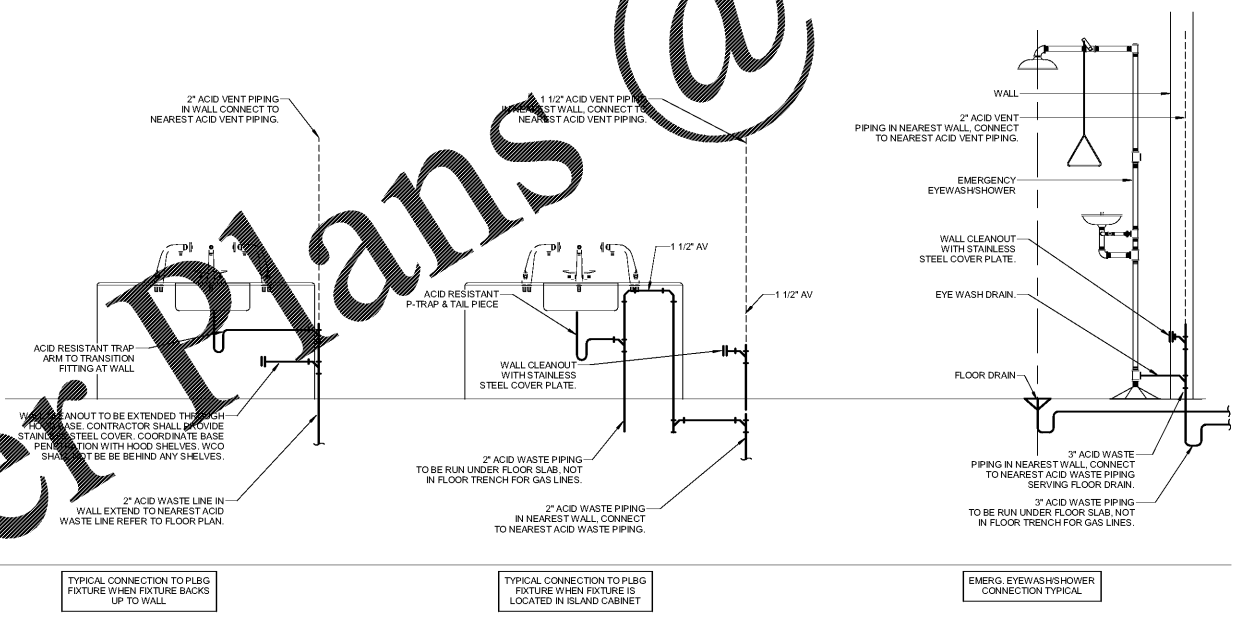

4 SCIENCE CLASSROOM WASTE AND VENT SERVICE DIAGRAMS
 SCALE: N.T.S.

1/15/2019 4:16:02 PM C:\Users\jvallen\OneDrive\Documents\17-2015_GA_SCIENCE BUILDING MEPV2016_jvallen.EDW

Order Plans @ www.LDOnline.com