 



NO	REVISION / SUBMISSIONS	DATE

  
**JOHN A. TUTTEN & ASSOCIATES**  
 ARCHITECTS  
 4680 U.S. HIGHWAY 17 NORTH  
 BRUNSWICK, GEORGIA 31525  
 www.jatutten.com

**GLYNN ACADEMY HIGH SCHOOL**  
**SCIENCE BLDG. (5015) MODERNIZATION**  
 1001 MANSFIELD ST. BRUNSWICK GA, 31520  
 GLYNN COUNTY BOARD OF EDUCATION

CAPITAL OUTLAY  
 PROJECT # TBD  
 SYSTEM CODE: 668  
 SCHOOL CODE: 4752  
 FTE: 1793


FIRE PROTECTION PLAN

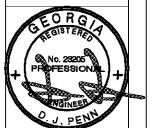


ISSUED FOR:  
BID SET

J.V. MP  
 DRAWN BY  
 DPCE  
 CHECKED BY  
 APPROVED BY  
 D.J.P.  
 01/19/19  
 PROJECT DATE  
 1802  
 PROJECT NUMBER

**SHEET NUMBER:**  
**FP2.01**  
 Copyright (c) 2019  
 All Rights Reserved.

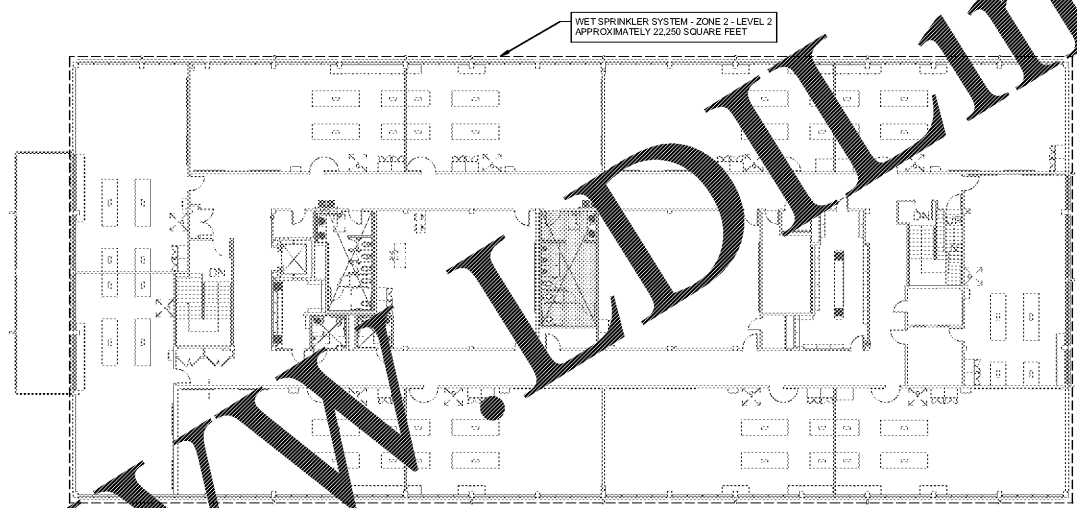

**2 FIRE PROTECTION PLAN - LEVEL 2**  
 FP2.01 SCALE: 1/16" = 1'-0"

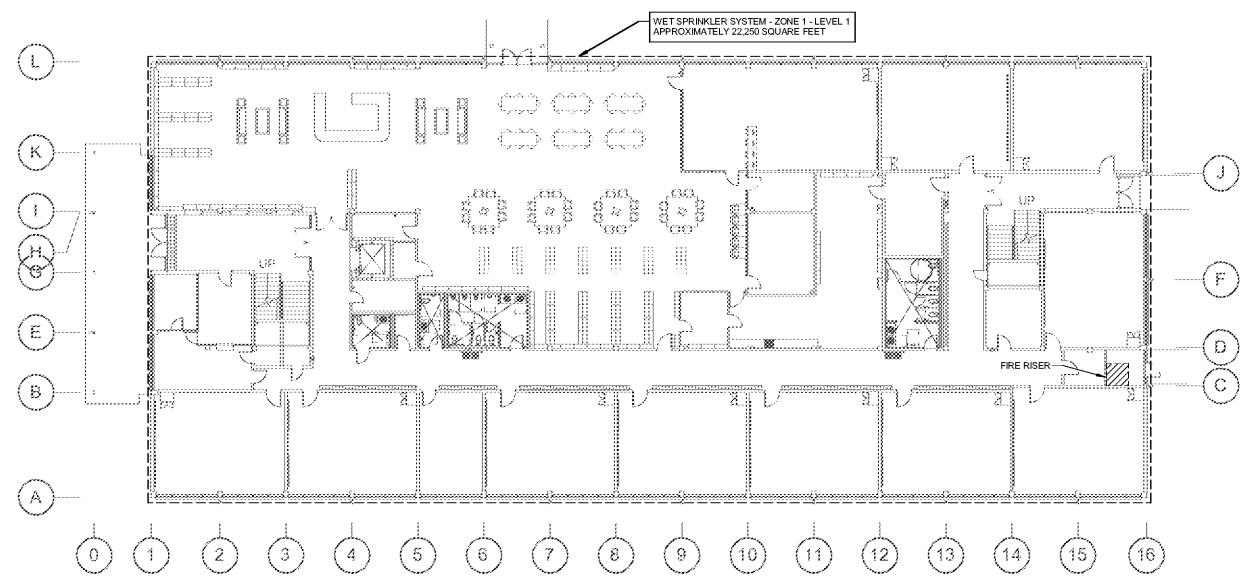

**1 FIRE PROTECTION PLAN - LEVEL 1**  
 FP2.01 SCALE: 1/16" = 1'-0"

Order Plans @ [www.LDLine.com](http://www.LDLine.com)

1/15/2019 4:14:38 PM C:\Users\jvalde...mms17-2015\_GA SCIENCE BUILDING MEPV2016\_includes\ED.m