

NO	REVISION / SUBMISSIONS	DATE

MECHANICAL REFERENCE NOTES

1. REFER TO SHEET M5-01-M5-02 FOR MECHANICAL DETAILS.
 2. REFER TO SHEET M5-01 FOR MECHANICAL NOTES, SYMBOLS, AND SCHEDULES.

TYPICAL GRILLES (U.O.N.)

24"x24" 24"x12" 12"x12"

NOTES BY SYMBOL

1. MOUNT DUCTLESS SPLIT SYSTEM AIR HANDLING UNIT ON WALL AT 8'-0" F.F. COORDINATE EXACT MOUNTING LOCATION IN FIELD WITH EQUIPMENT IN ROOM. DO NOT MOUNT OVER ELECTRICAL EQUIPMENT. ROUTE CONDENSATE AS INDICATED.

2. DUCTWORK FROM LEVEL BELOW TO LEVEL ABOVE FOR CONTINUATION.

3. UNIT VENTILATOR, MAKEUP AIR UNIT/F SERIES OR EQUIV. COORDINATE ALL MOUNTING REQUIREMENTS WITH MANUFACTURER PRIOR TO INSTALLATION. PROVIDE STRUCTURAL SUPPORT FOR OUTSIDE AIR FLOWER. COORDINATE EXACT LOCATION WITH ARCHITECT.

JOHN A. TUTEN & ASSOCIATES
 ARCHITECTS
 4680 U.S. HIGHWAY 17 NORTH
 BRUNSWICK, GEORGIA 31525
 www.plattner.com

GLYNN ACADEMY HIGH SCHOOL
 SCIENCE BLDG. (5015) MODERNIZATION
 1001 MANSFIELD ST. BRUNSWICK GA, 31520
 GLYNN COUNTY BOARD OF EDUCATION

CAPITAL OUTLAY
 PROJECT # TBD
 SYSTEM CODE: 663
 SCHOOL CODE: 4752
 FTE: 1793

MECHANICAL PLAN - LEVEL 1




ISSUED FOR:
 BID SET

JV, MP
 DRAWN BY
 DPCE
 CHECKED BY
 DJP
 APPROVED BY
 01/19/19
 PROJECT NO.
 1802
 PROJECT NUMBER

SHEET NUMBER:
M2.01

Copyright (c) 2019
 All Rights Reserved.

dpce DON PENN CONSULTING ENGINEER
 100 ISLAMA BLVD.
 SUITE 11 SUITE 1400
 WESTLAKE, TX 76080
 P 817.412.2558 | F 817.251.8411

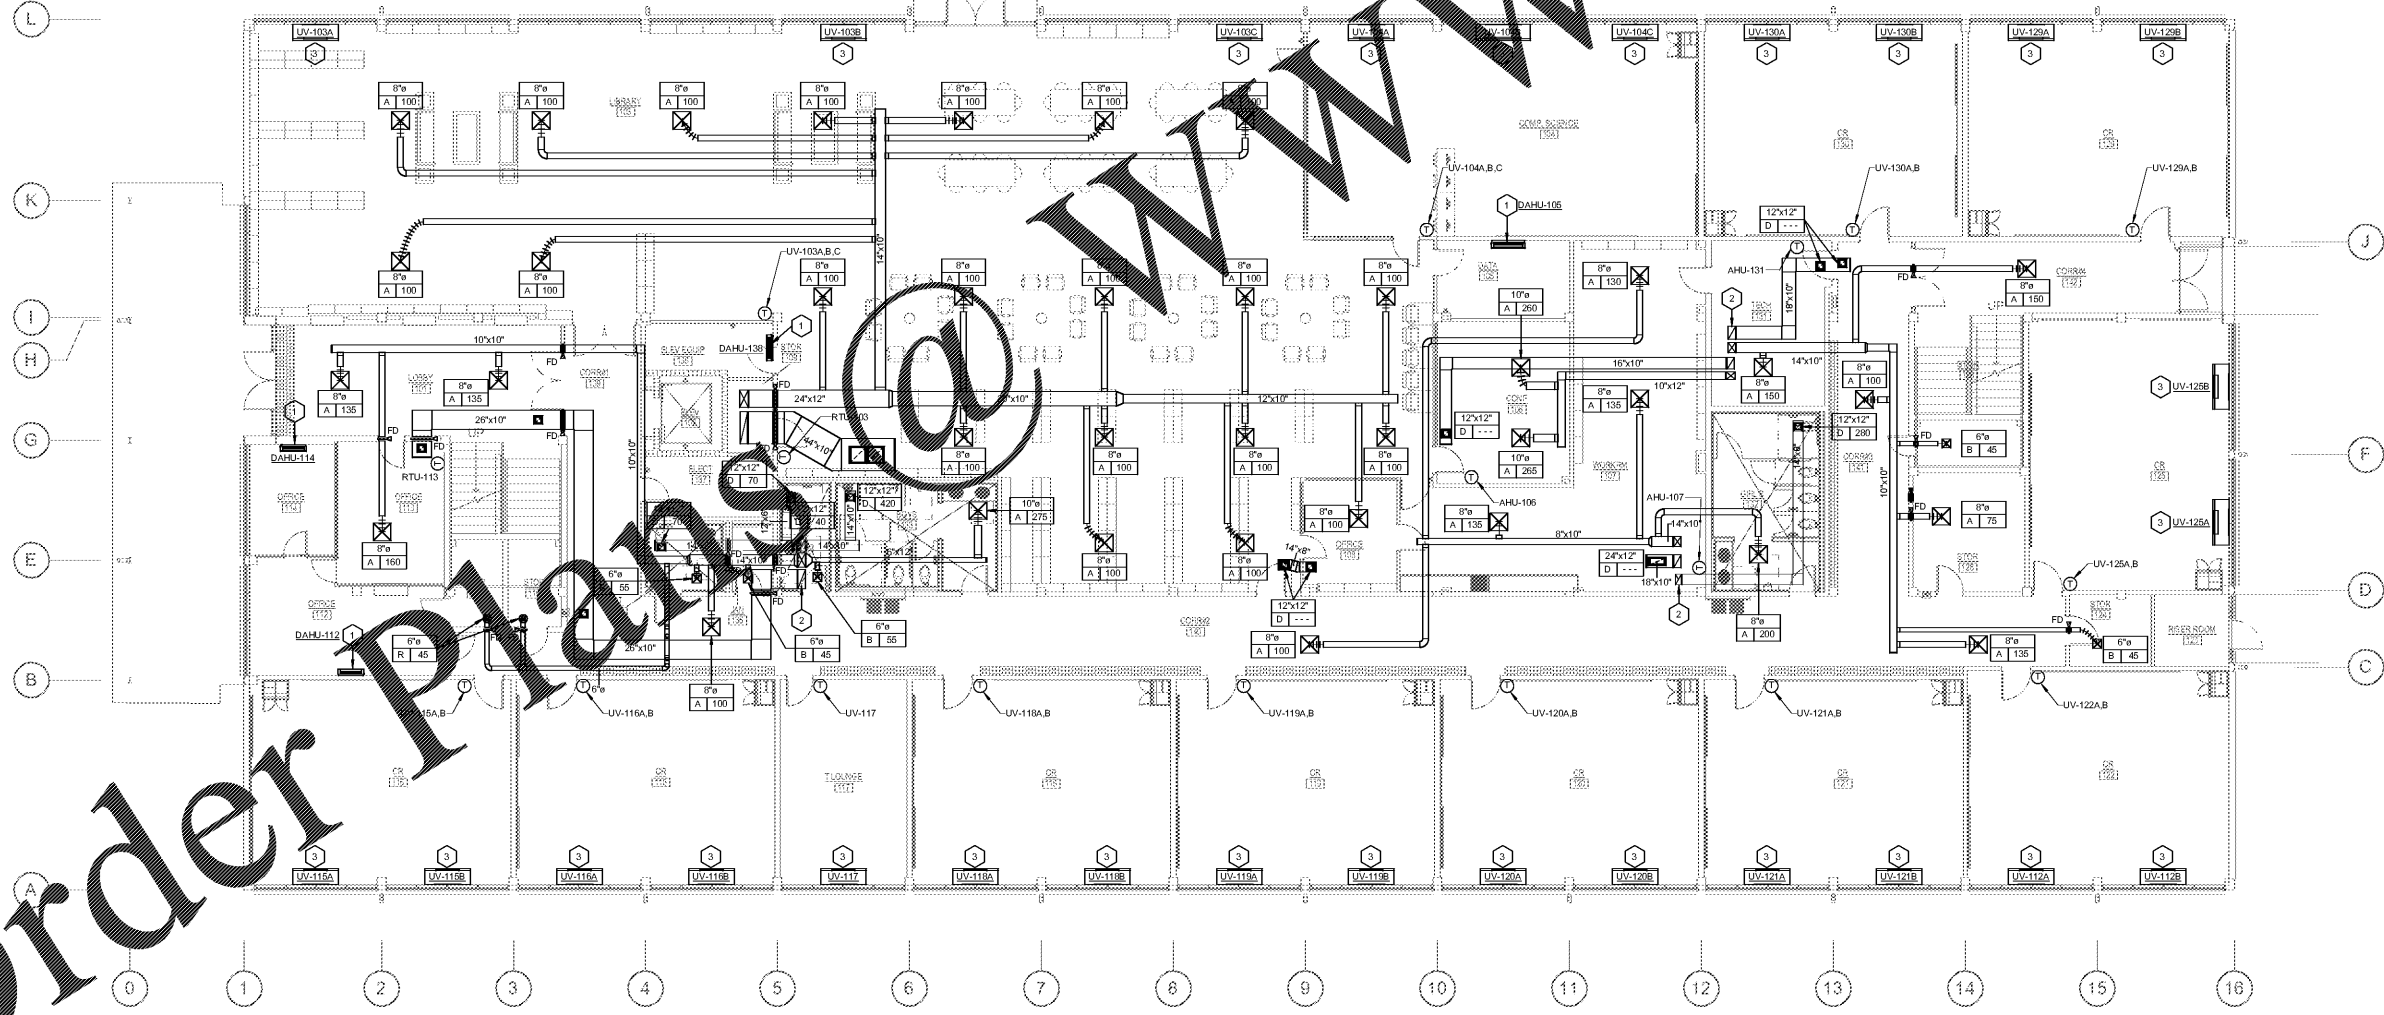

1 MECHANICAL PLAN - LEVEL 1
 M2.01 SCALE: 1/8" = 1'-0"

1/17/2019 9:25:49 AM C:\Users\jacob.d... \Documents\17-2015_GA SCIENCE BUILDING MEP\2016_jacob.dwg

Order Plans @ www.LDILine.com