

NO	REVISION / SUBMISSIONS	DATE

MECHANICAL REFERENCE NOTES

- REFER TO SHEET M5-01-M5-02 FOR MECHANICAL DETAILS.
- REFER TO SHEET M5-01 FOR MECHANICAL NOTES, SYMBOLS, AND SCHEDULES.

TYPICAL GRILLES (U.O.N.)

24x24	24x12	12x12

NOTES BY SYMBOL


- 3/4" CONDENSATE PIPING DOWN IN WALLCHASE TO TAIL PIECE.
- CONDENSATE PIPING DOWN IN WALLCHASE TO SINK TRAP.
- CONDENSATE PIPING FROM ...
- CONDENSATE PIPING FROM ... ADJACENT DOWN ... AS INDICATED ON PLANS. EXTEND CONDENSATE PIPING WITHIN BASE CABINET WHERE INDICATED TO MAINTAIN SLOPE AS DIRECTED BY CODE. CONDENSATE CONNECTION TO DOWN ... AT 45 DEGREE ANGLE THROUGH GROMMETTED OPENING.
- CONDENSATE PIPING ABOVE ...

JOHN A. TUTEN & ASSOCIATES
 ARCHITECTS
 4680 U.S. HIGHWAY 17 NORTH
 BRUNSWICK, GEORGIA 31525
 www.jatuten.com

GLYNN ACADEMY HIGH SCHOOL
 SCIENCE BLDG. (5015) MODERNIZATION
 1001 MANSFIELD ST. BRUNSWICK GA, 31520
 GLYNN COUNTY BOARD OF EDUCATION

CAPITAL OUTLAY
 PROJECT # TBD
 SYSTEM CODE: 668
 SCHOOL CODE: 4752
 FTE: 1798

CONDENSATE PLAN - LEVEL 2

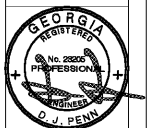


ISSUED FOR:
 BID SET

Author
 DRAWN BY
 Checker
 CHECKED BY
 Approver
 APPROVED BY
 01/18/19
 PROJECT NO.
 1802
 PROJECT NUMBER

SHEET
 NUMBER:
M3.02

Copyright (c) 2019
 All Rights Reserved.

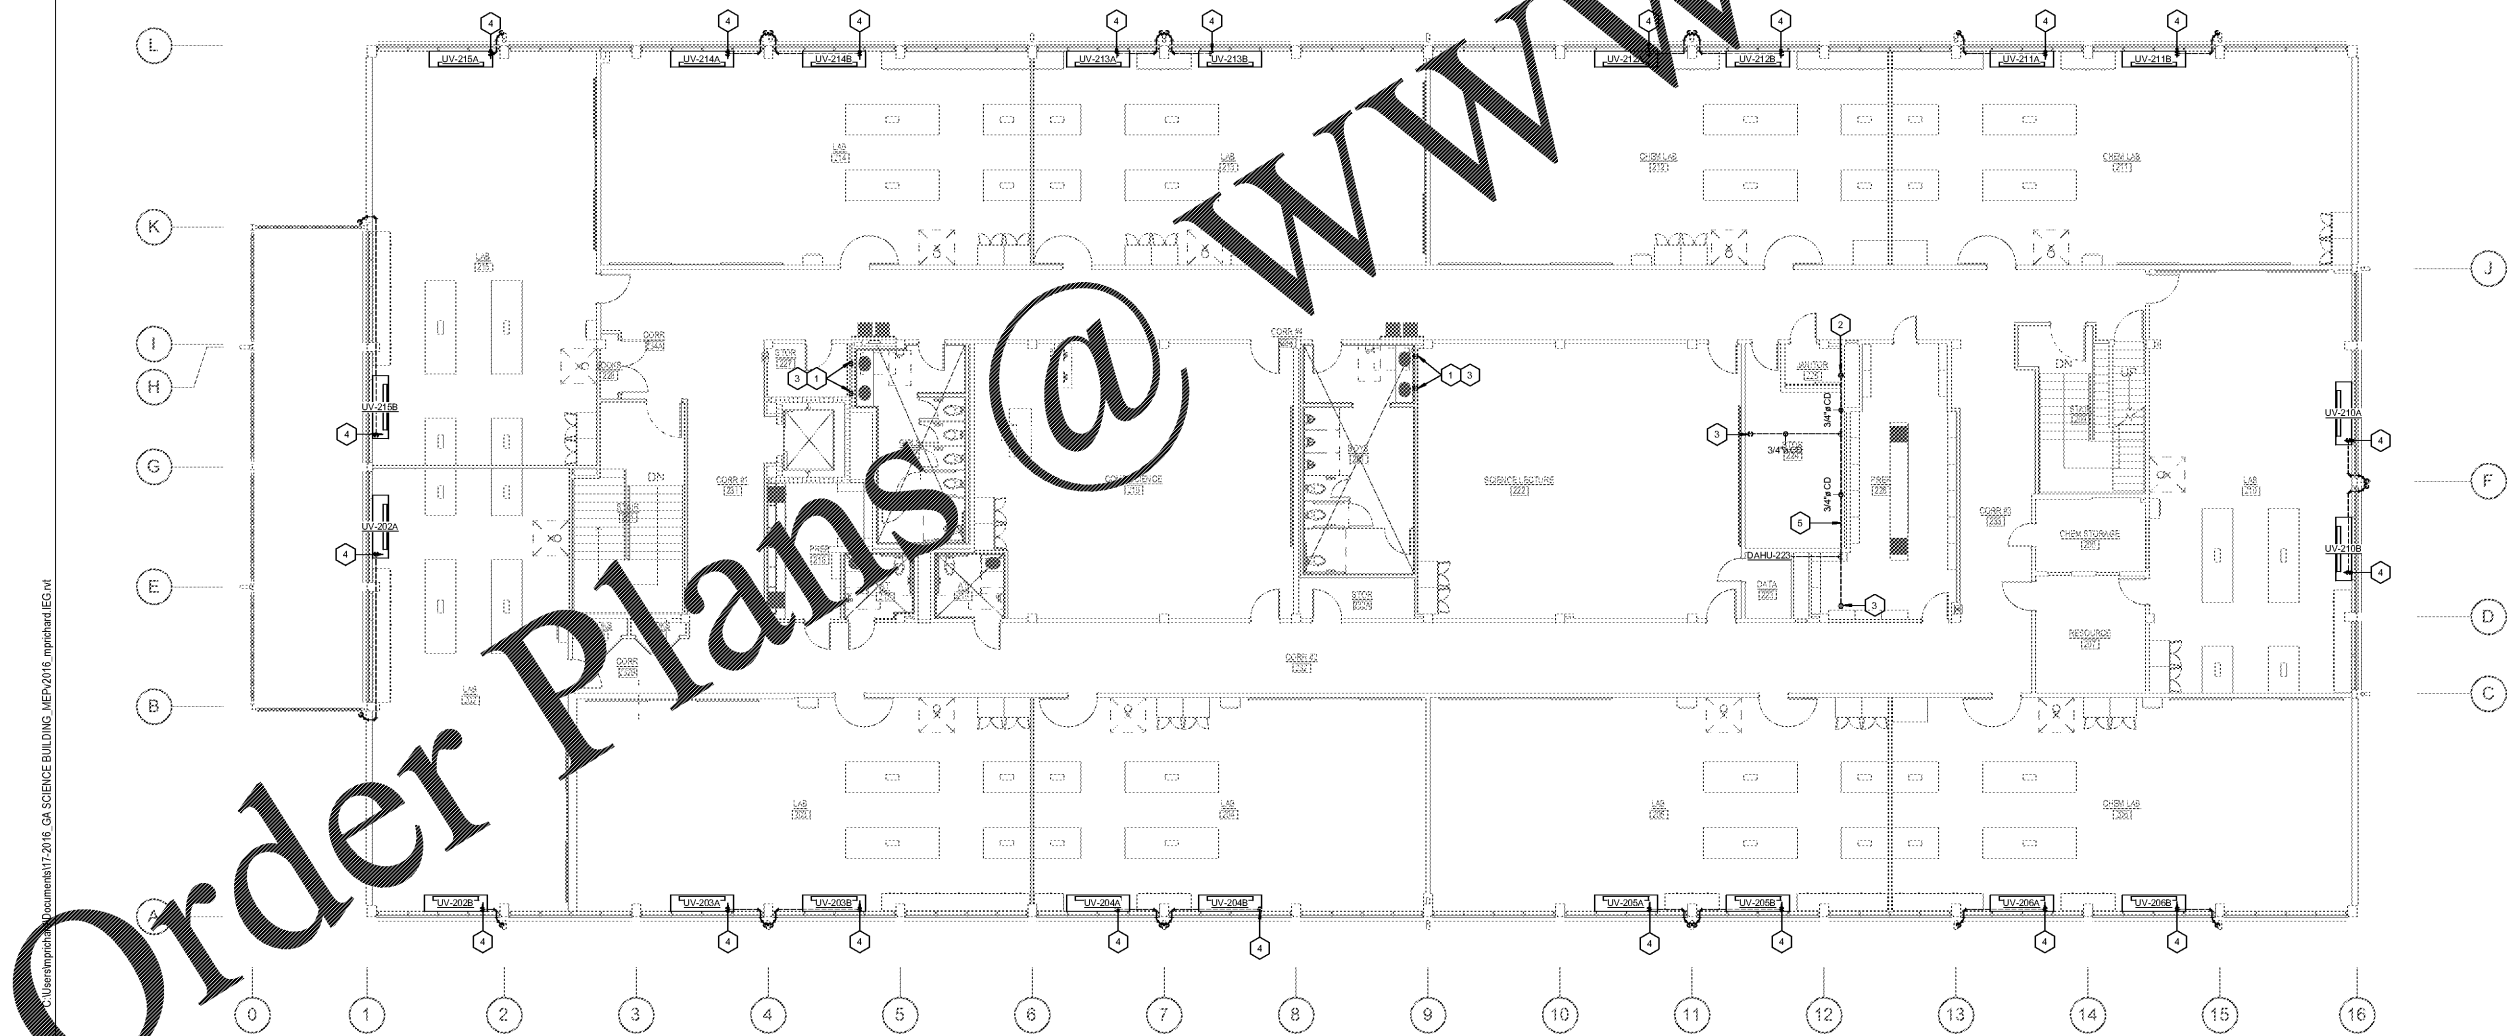

1/17/2019 3:07:22 PM C:\Users\jpenne\Documents\17-2016 GA SCIENCE BUILDING MEP\2016 mpechad.1EG.mxd
 M3.02 SCALE: 1/8" = 1'-0"

Order Plans @ www.LDILine.com