

NO	REVISION / SUBMISSIONS	DATE


- NOTES BY SYMBOL**
- APPROXIMATE LOCATION OF EXISTING 200V/3P UTILITY COMPANY TRANSFORMER LOCATION. COORDINATE LANDING OF NEW CONDUCTORS WITH GEORGIA POWER. EXISTING PAD MOUNTED TRANSFORMER TO REMAIN IN SERVICE THROUGHOUT CONSTRUCTION.
 - ROUTING OF SECONDARY ELECTRICAL SERVICE ENTRANCE CONDUIT AND CONDUCTORS. REFER TO ELECTRICAL RISER DIAGRAM E7.1 FOR MORE INFORMATION.
 - MAIN ELECTRICAL DISTRIBUTION EQUIPMENT LOCATION. REFER TO ELECTRICAL RISER DIAGRAM E7.1 FOR MORE INFORMATION.

JOHN A. TUTEN & ASSOCIATES
 ARCHITECTS
 4680 U.S. HIGHWAY 17 NORTH
 BRUNSWICK, GEORGIA 31525
 www.jatuten.com

GLYNN ACADEMY HIGH SCHOOL
 SCIENCE BLDG. (5015) MODERNIZATION
 1001 MANSFIELD ST. BRUNSWICK GA, 31520
 GLYNN COUNTY BOARD OF EDUCATION

CAPITAL OUTLAY
 PROJECT # TBD
 SYSTEM CODE: 668
 SCHOOL CODE: 4752
 FTE: 1793

ELECTRICAL SITE PLAN

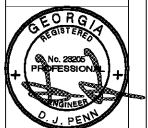


ISSUED FOR:
 BID SET

JV, MP
 DRAWN BY
 DPCE
 CHECKED BY
 DJP
 APPROVED BY
 01/18/19
 PROJECT DATE
 1802
 PROJECT NUMBER

SHEET NUMBER:
E1.01

dpce
 DON PENN CONSULTING ENGINEER
 100 BELLA BLVD.
 SUITE 1100, SUITE 1400
 WESTLAKE, TX 79082
 P 817.412.2588 | F 817.251.8411

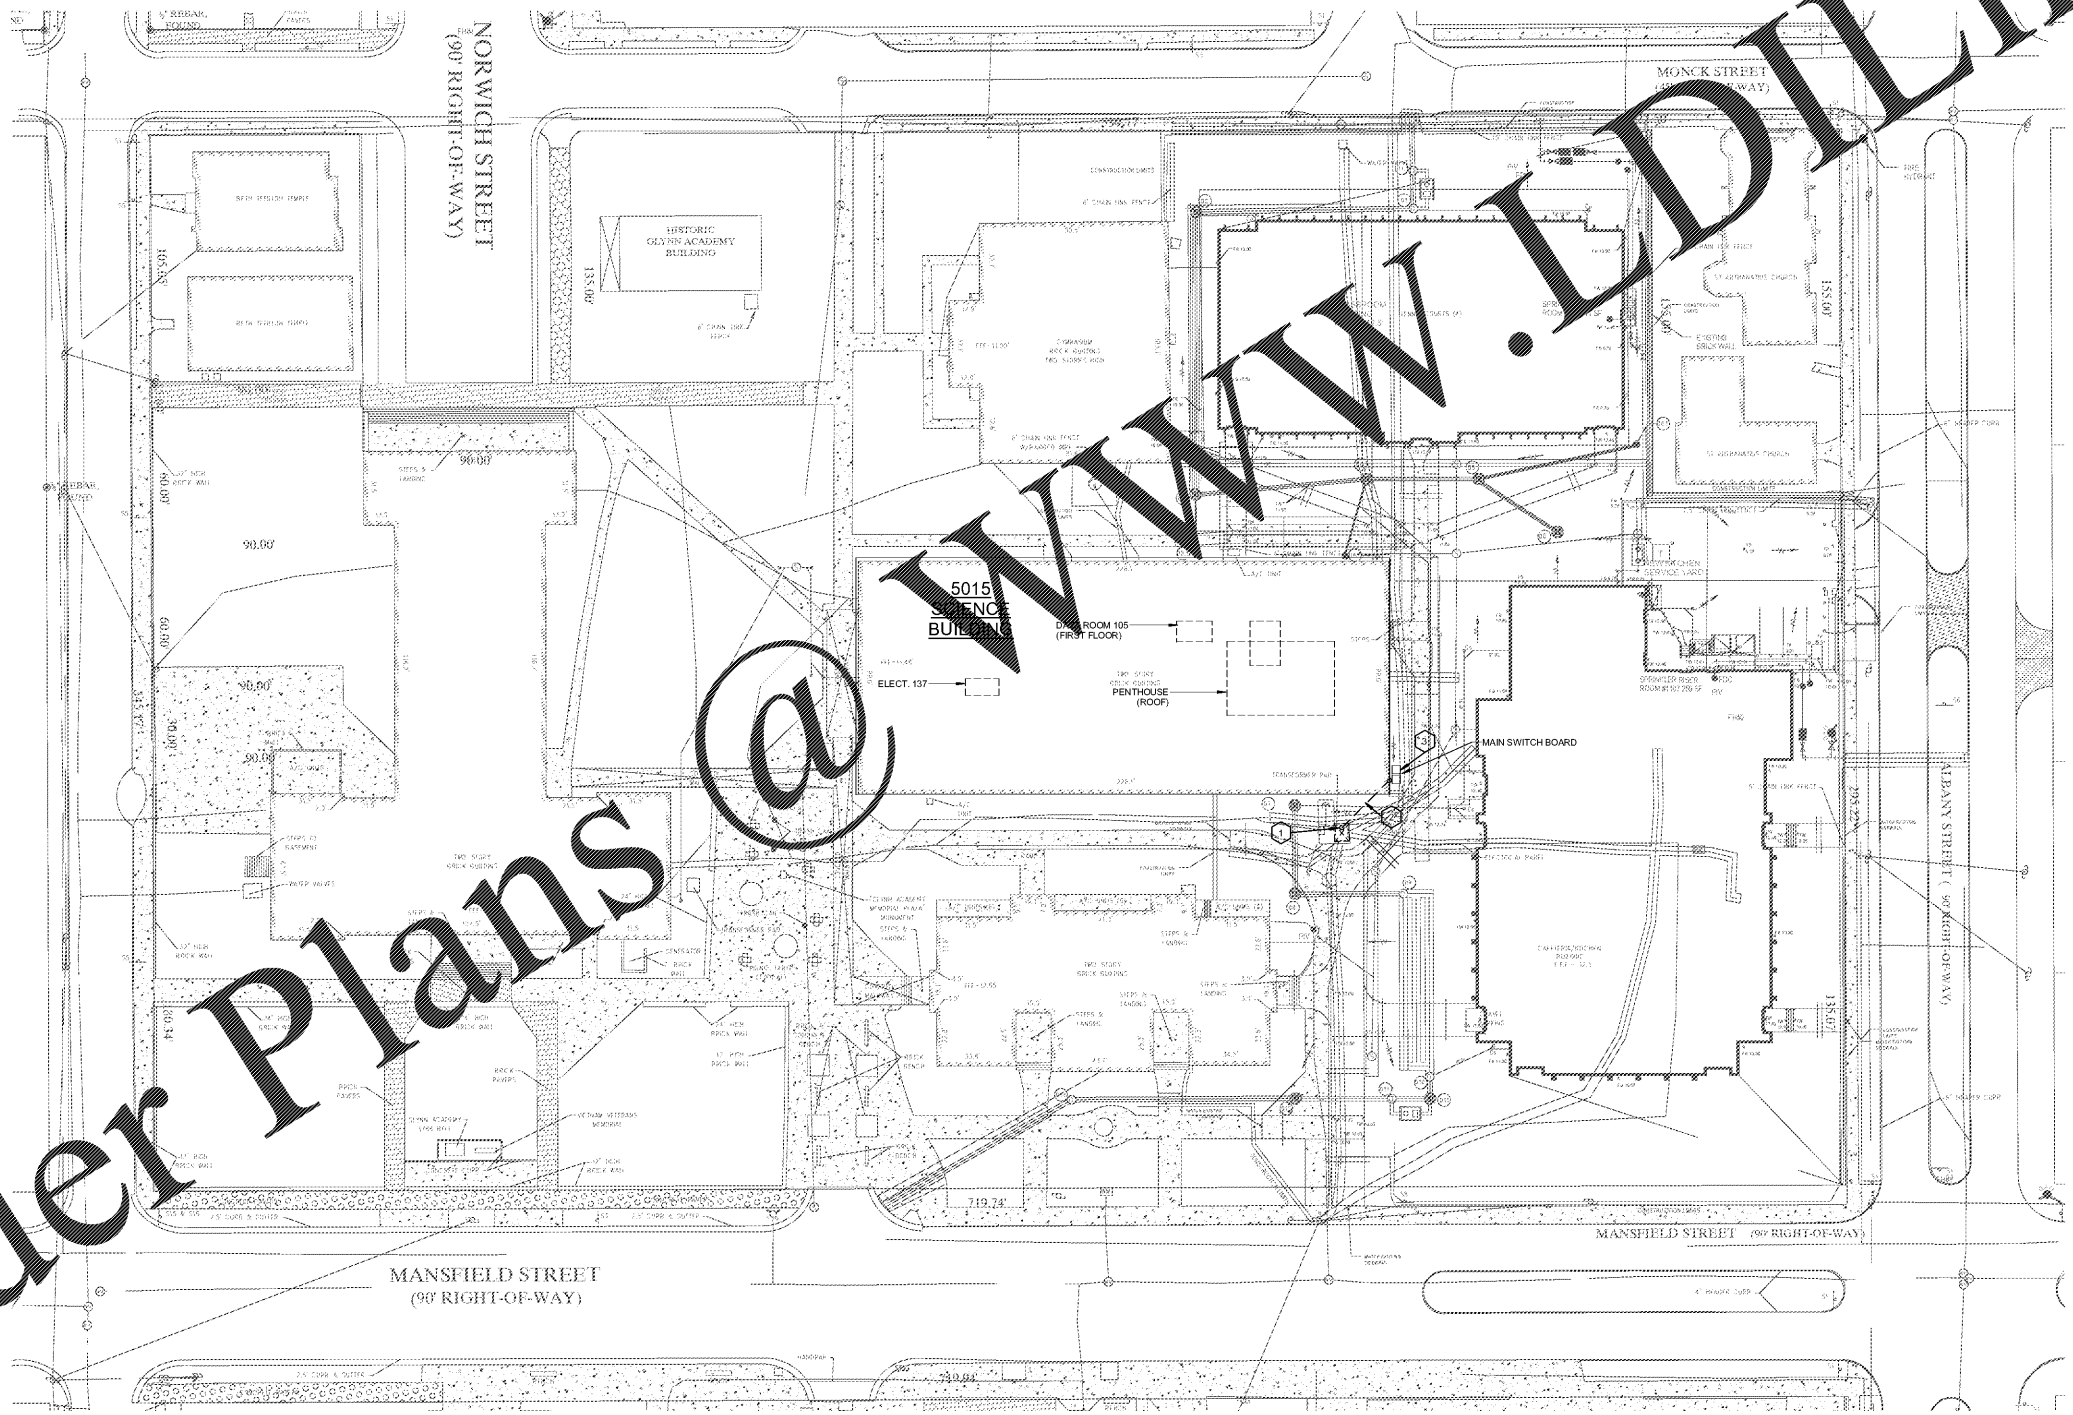

1 ELECTRICAL SITE PLAN
 E101 SCALE: 1" = 30'-0"

1/15/2019 4:13:16 PM C:\Users\jacob.d...m17-2015_GA SCIENCE BUILDING MEPV2016_jatden.EDW

Order Plans @ www.IDLine.com