

NO	REVISION / SUBMISSIONS	DATE

LIGHTING REFERENCE NOTES

- REFER TO SHEET ES-01-ES-03 FOR ELECTRICAL DETAILS.
- REFER TO SHEET ES-01 FOR ELECTRICAL NOTES, SYMBOLS, AND SCHEDULES.
- REFER TO SHEET ET-01 FOR ELECTRICAL RISER DIAGRAMS.
- REFER TO SHEET ET-02 FOR ELECTRICAL PANEL SCHEDULES.

GENERAL LIGHTING NOTES

NOTES:

- ALL EXIT LIGHTS TO BE CIRCUITED ON LOCAL AREA EMERGENCY LIGHT CIRCUIT ON UN-SWITCHED LEG.

OCCUPANCY/VACANCY SENSOR TABLE


SENSOR TYPE	LOCATION
OCCUPANCY SENSOR	CORRIDOR, RESTROOM, STORAGE, UTILITY SPACES
VACANCY SENSOR	CLASSROOM, OFFICE, BREAK ROOM, CONFERENCE, MULTI-PURPOSE

NOTES AND SYMBOL


NIGHT LIGHT FIXTURES TO UN-SWITCHED LEG.

CEILING MOUNTED OCCUPANCY SENSOR FOR CONTROL OF CORRIDOR LIGHTING. REFER TO SPECIFICATIONS FOR ADDITIONAL INFORMATION.

3. [Symbol] BOX FOR CONNECTION TO EXISTING CANOPY LIGHT FIXTURES. FIELD VERIFY EXACT LOCATION.

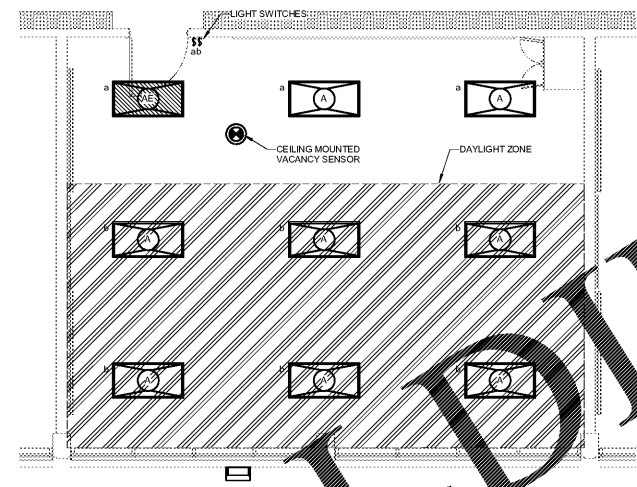

2 LIGHTING CONTROL PLAN - TYPICAL CLASSROOM
 E2-01 SCALE: 1/4" = 1'-0"

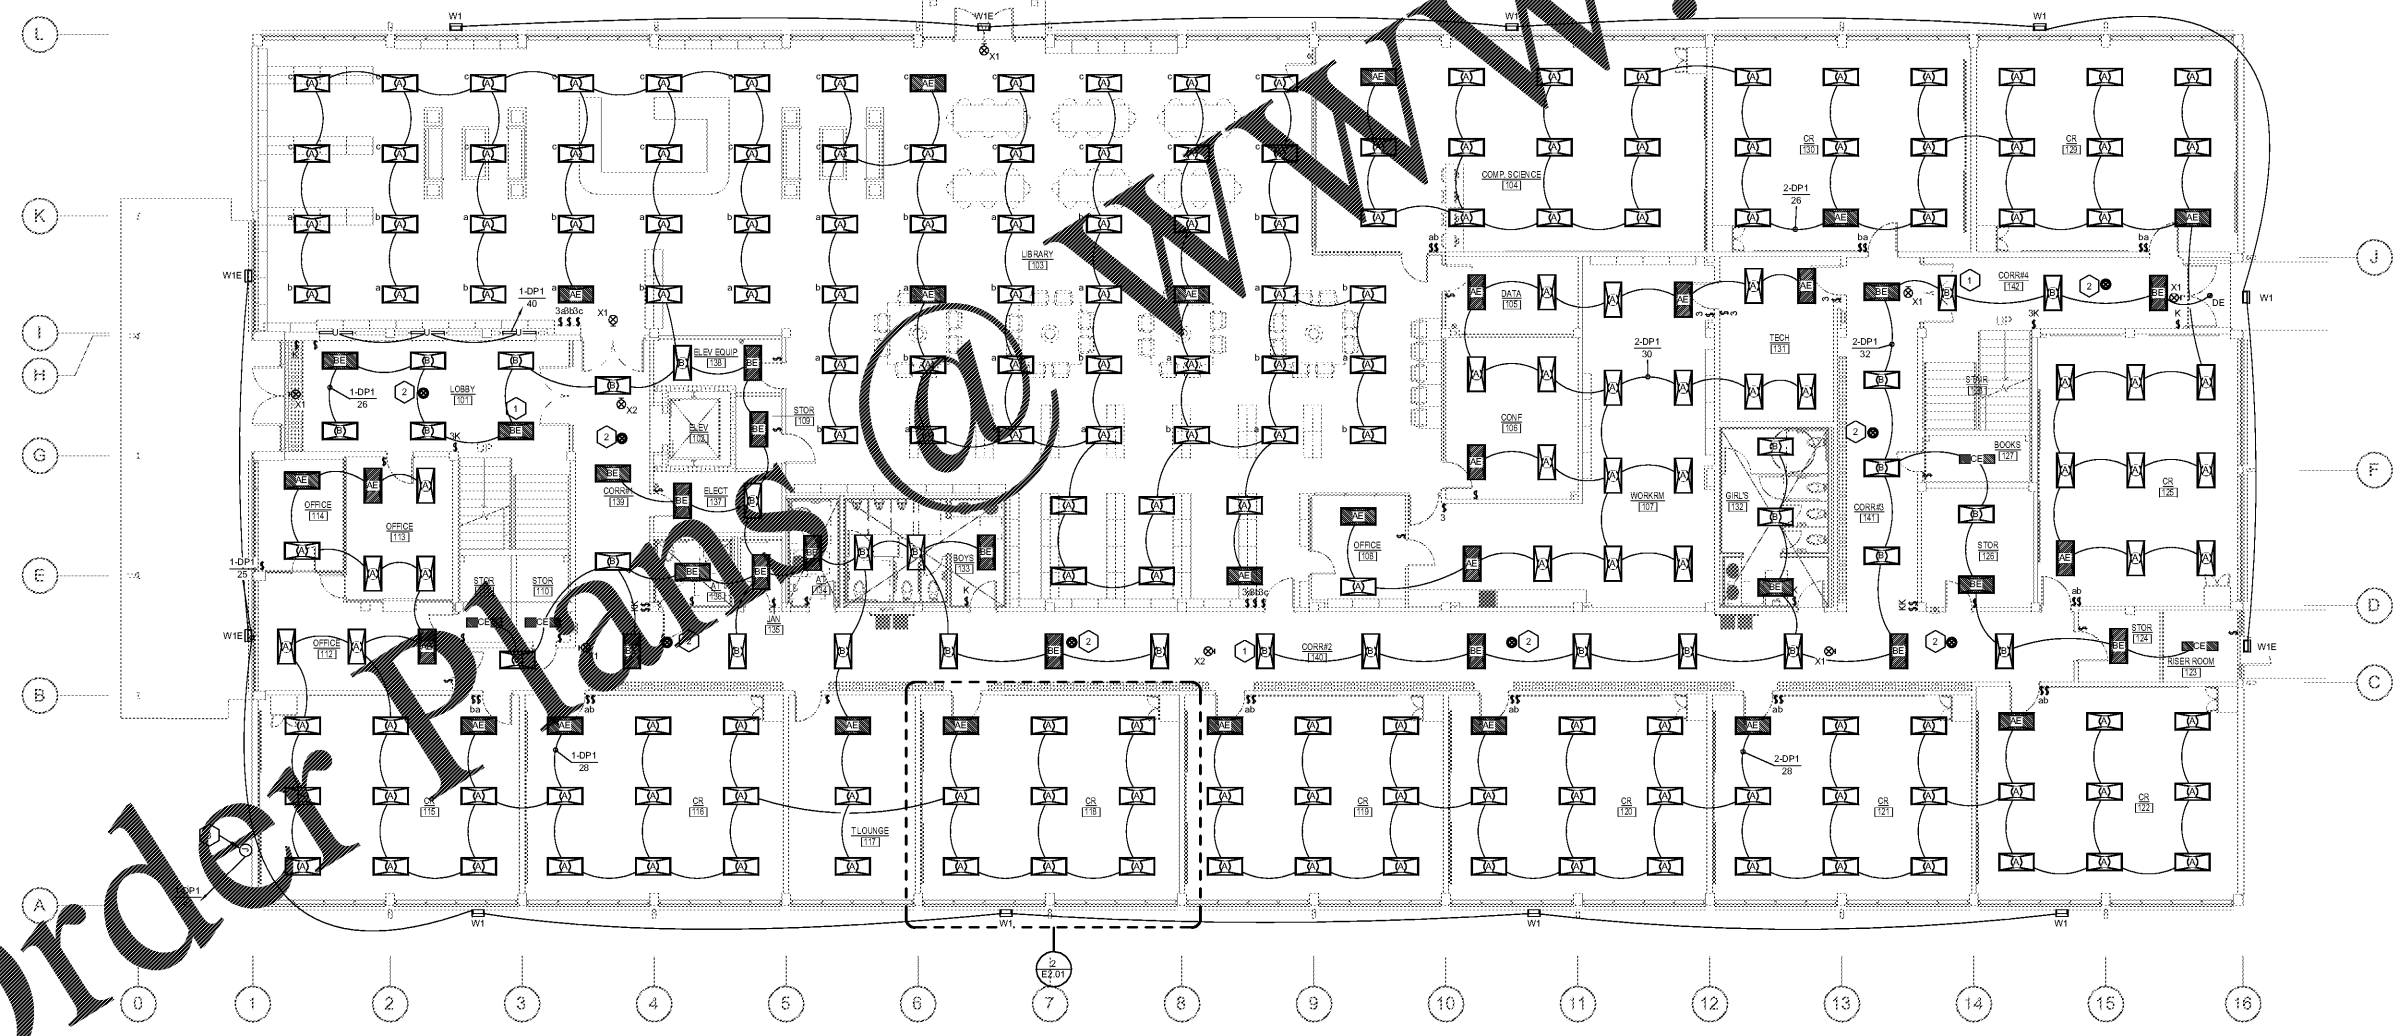


1 LIGHTING PLAN - LEVEL 1
 E2-01 SCALE: 1/8" = 1'-0"

JOHN A. TUTTEN & ASSOCIATES
 ARCHITECTS
 4680 U.S. HIGHWAY 17 NORTH
 BRUNSWICK, GEORGIA 31525
 www.jatutten.com

GLYNN ACADEMY HIGH SCHOOL
 SCIENCE BLDG. (5015) MODERNIZATION
 1001 MANSFIELD ST. BRUNSWICK GA, 31520
 GLYNN COUNTY BOARD OF EDUCATION

CAPITAL OUTLAY
 PROJECT # TBD
 SYSTEM CODE: 668
 SCHOOL CODE: 4752
 FTE: 1793

LIGHTING PLAN - LEVEL 1

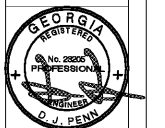

ISSUED FOR:
 BID SET

JV, MP
 DRAWN BY
 DPCE
 CHECKED BY
 DJP
 APPROVED BY
 01/18/19
 PROJECT DATE
 1802
 PROJECT NUMBER

**SHEET NUMBER:
 E2.01**

dpce DON PENN CONSULTING ENGINEER
 1001 BRUNNANA BLVD.
 SUITE 201 SUITE 1400
 WESTLAKE, TX 75086
 P 972.412.2588 F 972.251.8411

1/15/2019 4:13:19 PM C:\Users\jvalde\Documents\17-2015_GA_SCIENCE BUILDING MEP\2016_166\level1_E2.dwg