

NO	REVISION / SUBMISSIONS	DATE

POWER REFERENCE NOTES

- REFER TO SHEET E3.01-E3.03 FOR ELECTRICAL DETAILS.
- REFER TO SHEET E3.01 FOR ELECTRICAL NOTES, SYMBOLS, AND SCHEDULES.
- REFER TO SHEET E7.01 FOR ELECTRICAL RISER DIAGRAMS.
- REFER TO SHEET E7.02 FOR ELECTRICAL PANEL SCHEDULES.

POWER NOTES

- REFER TO ELECTRICAL DISCONNECT SCHEDULE SHEET E6.01 FOR MECHANICAL EQUIPMENT CIRCUIT AND DISCONNECT INFORMATION. CONDUIT MUST BE RUN CONCEALED INSIDE THE BUILDING.

NOTES BY SYMBOL


- WIRED J-BOX FOR CONNECTION TO WATER HEATER. COORDINATE WELL LOCATION PRIOR TO RUGH-IN.
- 120V RECEPTACLE FOR CONNECTION TO WATER CIRCULATION PUMP. COORDINATE ELECTRICAL REQUIREMENTS WITH EQUIPMENT USED. COORDINATE ELECTRICAL LOCATION PRIOR TO RUGH-IN.

JOHN A. TUTTEN & ASSOCIATES
 ARCHITECTS
 4680 U.S. HIGHWAY 17 NORTH
 BRUNSWICK, GEORGIA 31525
 www.jatuten.com

GLYNN ACADEMY HIGH SCHOOL
 SCIENCE BLDG. (5015) MODERNIZATION
 1001 MANSFIELD ST. BRUNSWICK GA, 31520
 GLYNN COUNTY BOARD OF EDUCATION

CAPITAL OUTLAY
 PROJECT # TBD
 SYSTEM CODE: 668
 SCHOOL CODE: 4752
 FTB: 1793

POWER PLAN - PENTHOUSE

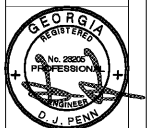


ISSUED FOR:
 BID SET

J.V. MP
 DRAWN BY
 DPCE
 CHECKED BY
 DJP
 APPROVED BY
 01/19/19
 PROJECT DATE
 1802
 PROJECT NUMBER

SHEET
 NUMBER:
E3.03

Copyright (c) 2019
 All Rights Reserved.

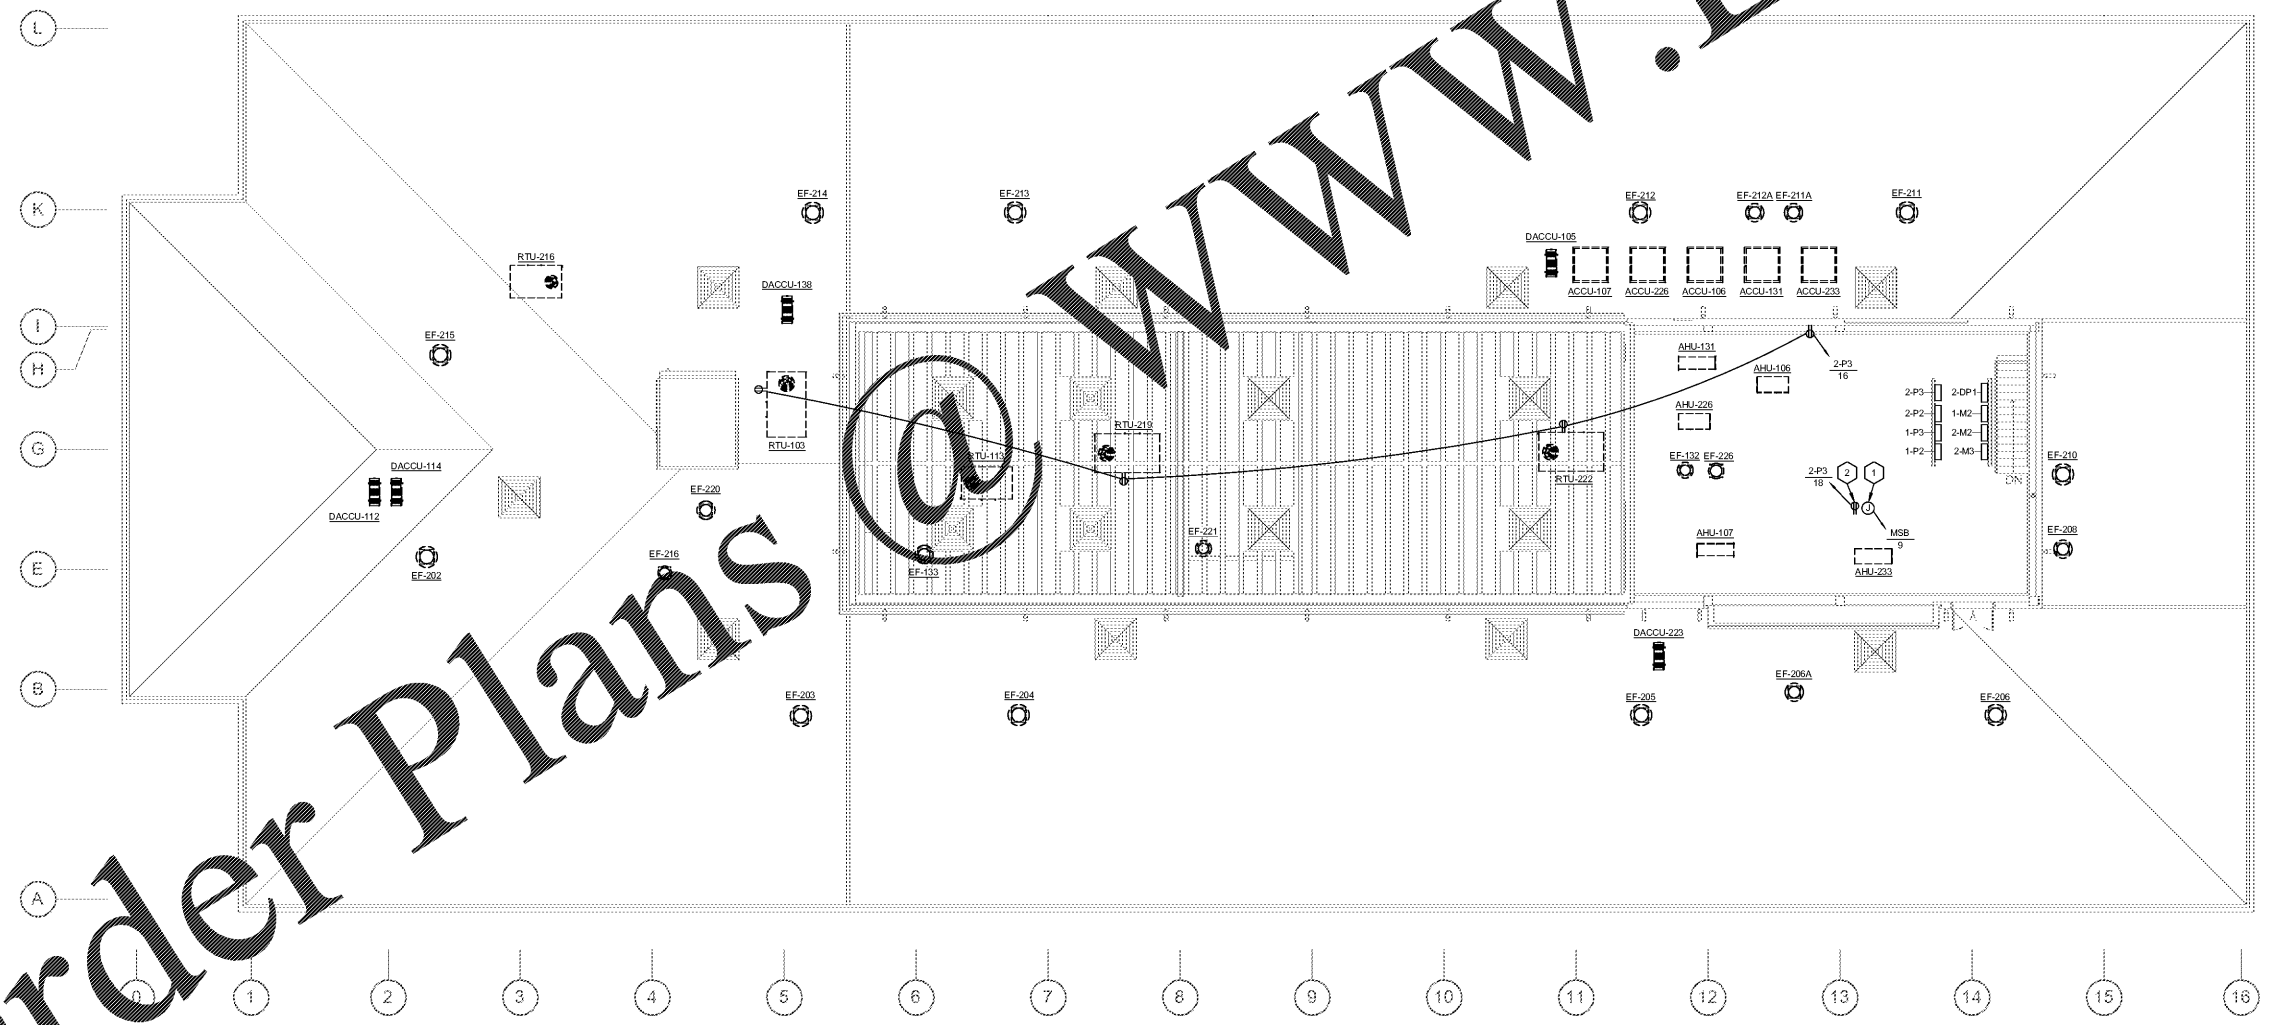

POWER PLAN - PENTHOUSE
 E3.03 SCALE: 1/8" = 1'-0"

C:\Users\jvalde\Documents\17-2015_GA SCIENCE BUILDING MEP\2016_jvalde_E3.03.dwg
 1/15/2019 4:13:42 PM

Order Plans

WWW.LDILine.com