



NO	REVISION / SUBMISSIONS	DATE

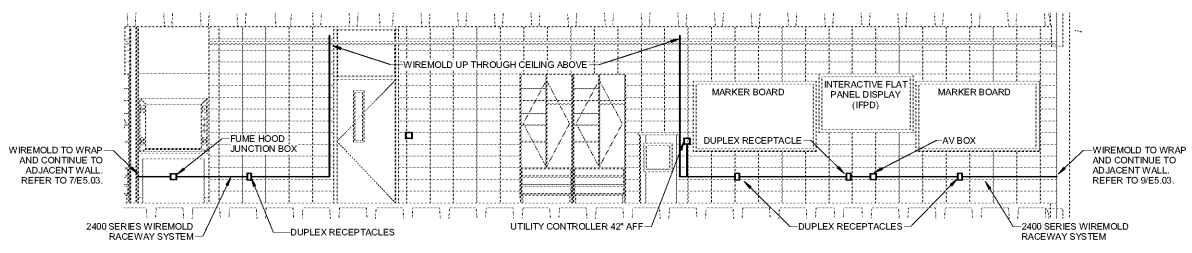


10 TYPICAL LAB TEACHING WALL
SCALE: 1/4" = 1'-0"

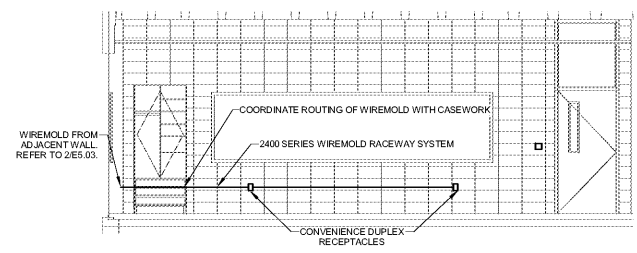


5 TYPICAL CLASSROOM WALL
SCALE: 1/4" = 1'-0"


- NOTES BY SYMBOL**
- 120V RECEPTACLE, DATA, AND AV BOX FOR INTERACTIVE FLAT PANEL DISPLAY. COORDINATE EXACT LOCATION OF ROUGH-IN WITH ARCHITECT PRIOR TO INSTALLATION.
 - TEACHERS WORK STATION LOCATION. REFER TO ELEVATION DETAILS ON SHEET E5.03 FOR MORE INFORMATION. VERIFY EXACT LOCATION PRIOR TO ROUGH IN.
 - RECEPTACLE(S) TO BE LOCATED IN WIREMOLD RACEWAY. REFER TO ELEVATION DETAILS ON E5.03.
 - J-BOX FOR CONNECTION TO MASTER UTILITY CONTROLLER. VERIFY EXACT LOCATION OF MASTER UTILITY CONTROLLER PUSHBUTTON SWITCH AND OWNER PRIOR TO INSTALLATION.
 - WIRED J-BOX FOR CONNECTION TO FUME HOOD. VERIFY FUMEHOOD TYPE PRIOR TO INSTALLATION. VERIFY ALL ELECTRICAL REQUIREMENTS WITH EQUIPMENT USED.
 - QUADRECEPTACLES MOUNTED ON TABLES/CASEWORK. COORDINATE ROUGH FLOOR BELOW. COORDINATE CASING PATHING AND RECEPTACLE CONNECTION WITH SPECIFIC CASEWORK USED.

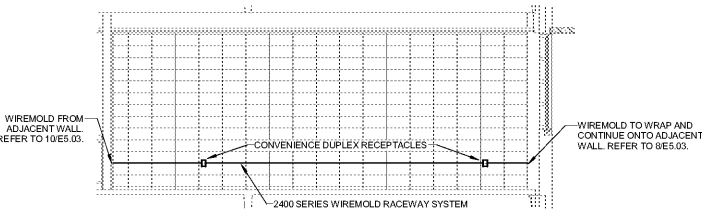


9 TYPICAL LAB WALL
SCALE: 1/4" = 1'-0"

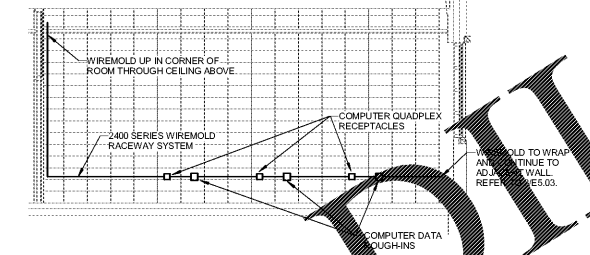


4 TYPICAL CLASSROOM COMPUTER WALL
SCALE: 1/4" = 1'-0"

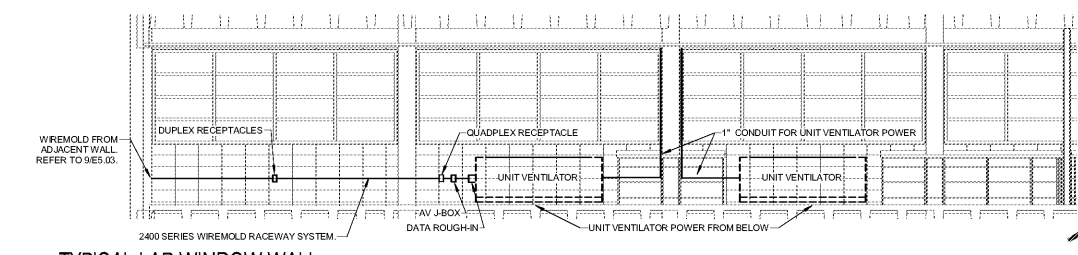


8 TYPICAL LAB WINDOW WALL
SCALE: 1/4" = 1'-0"

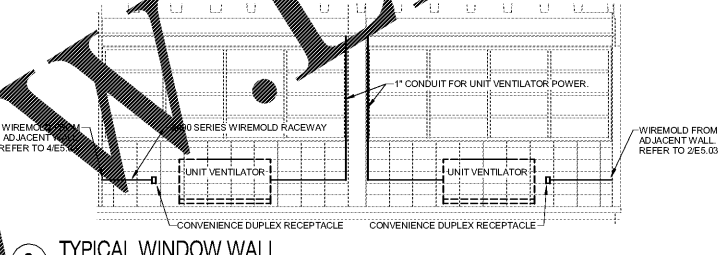


3 TYPICAL WINDOW WALL
SCALE: 1/4" = 1'-0"

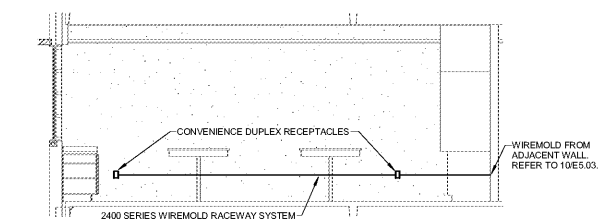


7 TYPICAL LAB WORKSTATION WALL
SCALE: 1/4" = 1'-0"

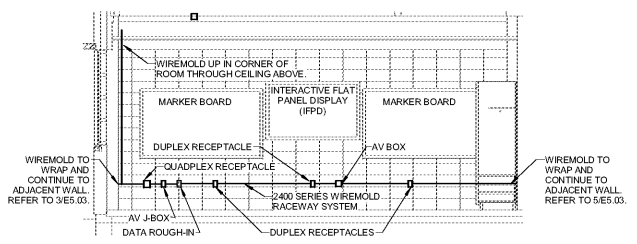

2 TYPICAL TEACHING WALL
SCALE: 1/4" = 1'-0"

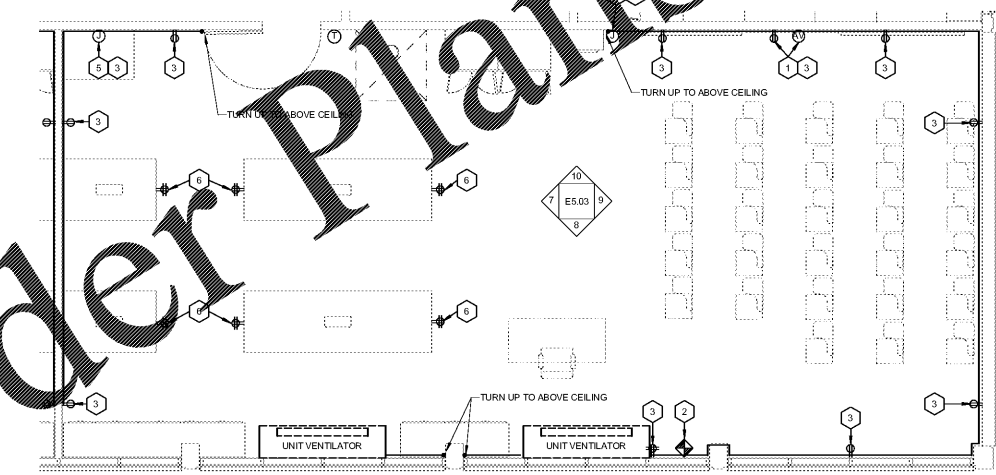

6 POWER PLAN - TYPICAL LAB LAYOUT
SCALE: 1/4" = 1'-0"

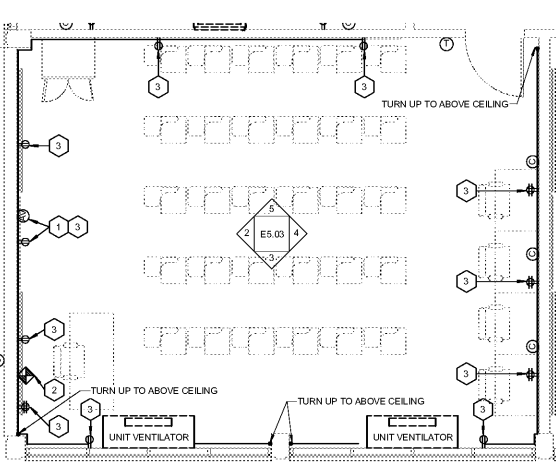

1 POWER PLAN - TYPICAL CLASSROOM LAYOUT
SCALE: 1/4" = 1'-0"


Order Plans @ WWW.IDLine.com

JOHN A. TUTTEN & ASSOCIATES
ARCHITECTS
4680 U.S. HIGHWAY 17 NORTH
BRUNSWICK, GEORGIA 31525
www.jatuten.com

GLYNN ACADEMY HIGH SCHOOL
SCIENCE BLDG. (5015) MODERNIZATION
1001 MANSFIELD ST. BRUNSWICK GA, 31520
GLYNN COUNTY BOARD OF EDUCATION

CAPITAL OUTLAY
PROJECT # TBD
SYSTEM CODE: 668
SCHOOL CODE: 4752
FTE: 1793

ELECTRICAL DETAILS

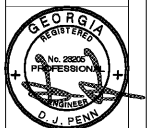

ISSUED FOR:
BID SET

Author
DRAWN BY
Checker
CHECKED BY
Approver
APPROVED BY
01/19/19
PROJECT DATE
1802
PROJECT NUMBER

SHEET NUMBER:
E5.03

Copyright (c) 2019
All Rights Reserved.



1/15/2019 4:14:04 PM C:\Users\jacob.tuten\Documents\17-2015_GA SCIENCE BUILDING MEP\2016_17.mxd EED.mw