


- NOTES:
1. ALL EXPOSED WALL TILE EDGES MUST BE FINISHED TO MATCH TILE SURFACE. EASE TILE EDGE AS ALLOWABLE.
 2. BLINDS SHALL BE PROVIDED BY OWNER AND INSTALLED BY VENDOR. COORDINATE WITH PANDA PROJECT MANAGER PRIOR TO INSTALLATION.
 3. PROVIDE 1/2" CLEAR PLASTIC CORNER GUARD FOR ALL INTERIOR PAINTED SURFACE W/ CLEAR GLUE.
 4. ALL TILES INSTALLED NOT TO BE CUT LESS THAN 1/2 THE TILE WIDTH.
 5. REFERENCE SHEET A-103 FOR WALL PANEL SCHEDULE.
 6. REFERENCE SHEET A-103 FOR SPECIAL SURFACE SCHEDULE.
 7. REFERENCE SHEET A-103 FOR INTERIOR PAINT SCHEDULE.
 8. REFERENCE SHEET A-104 FOR TILE SCHEDULE.
 9. REFERENCE SHEET A-104 FOR EXTENT OF COVE TRIM AT BASE.


GENERAL DECOR NOTE:
ALL WALL DECORATIONS, PRINT LOCATIONS, ETC., TO BE VERIFIED WITH PANDA EXPRESS BY G.C.

G.C. SHALL PROVIDE/INSTALL ANY CONCEALED BACKING, MISC. HARDWARE NOT PROVIDED BY OWNER, ETC., AS REQUIRED.


COORDINATE LOCATION OF ALARM DEVICES WITH ARTWORK (IF REQUIRED).

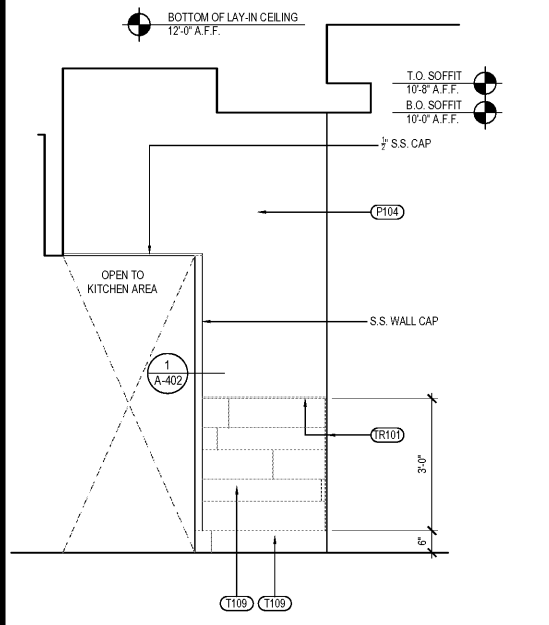


DINING ROOM ELEVATION 4
Scale= 1/2" = 1'-0" A-500

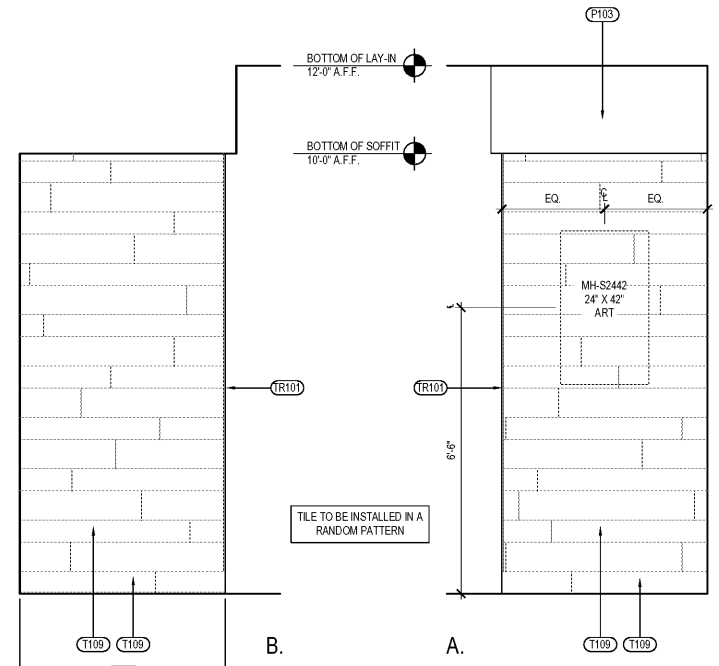

DINING ROOM ELEVATIONS BY DRINK STATION 3
Scale= 1/2" = 1'-0" A-500

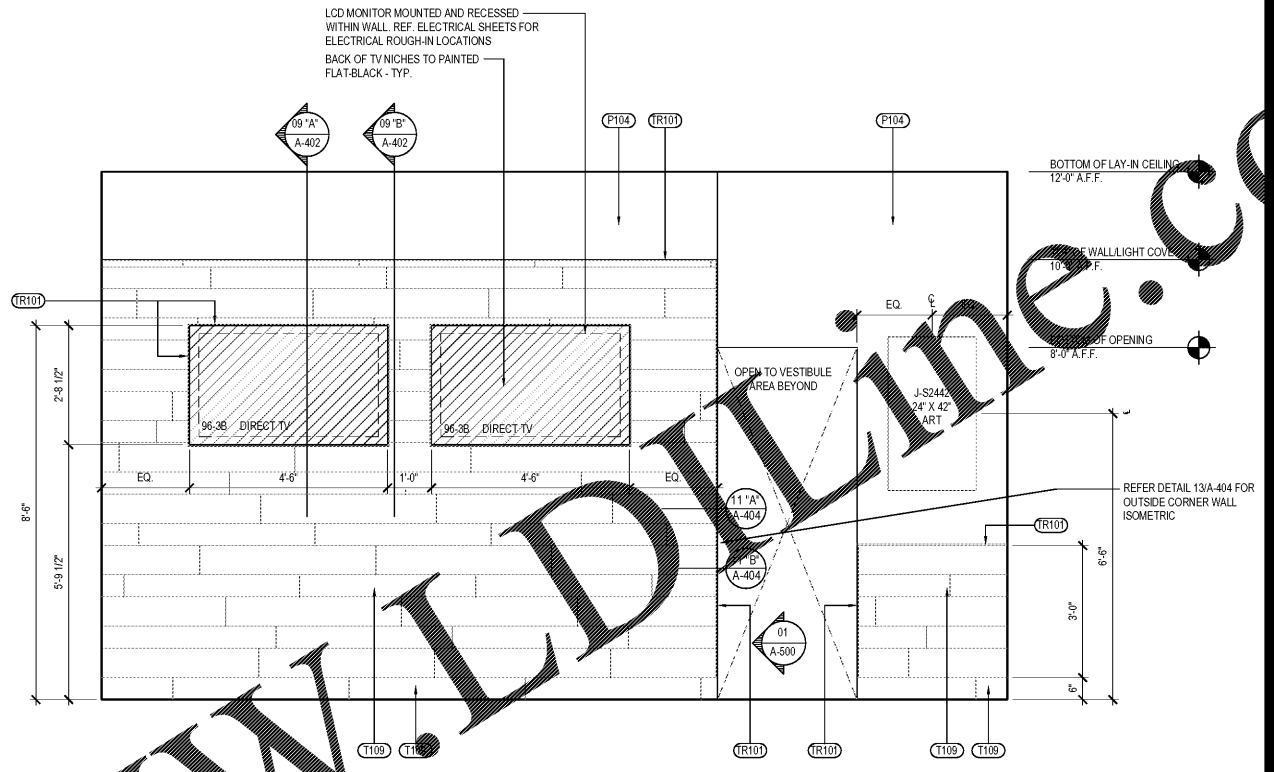

DINING ROOM ELEVATION 2
Scale= 1/2" = 1'-0" A-500

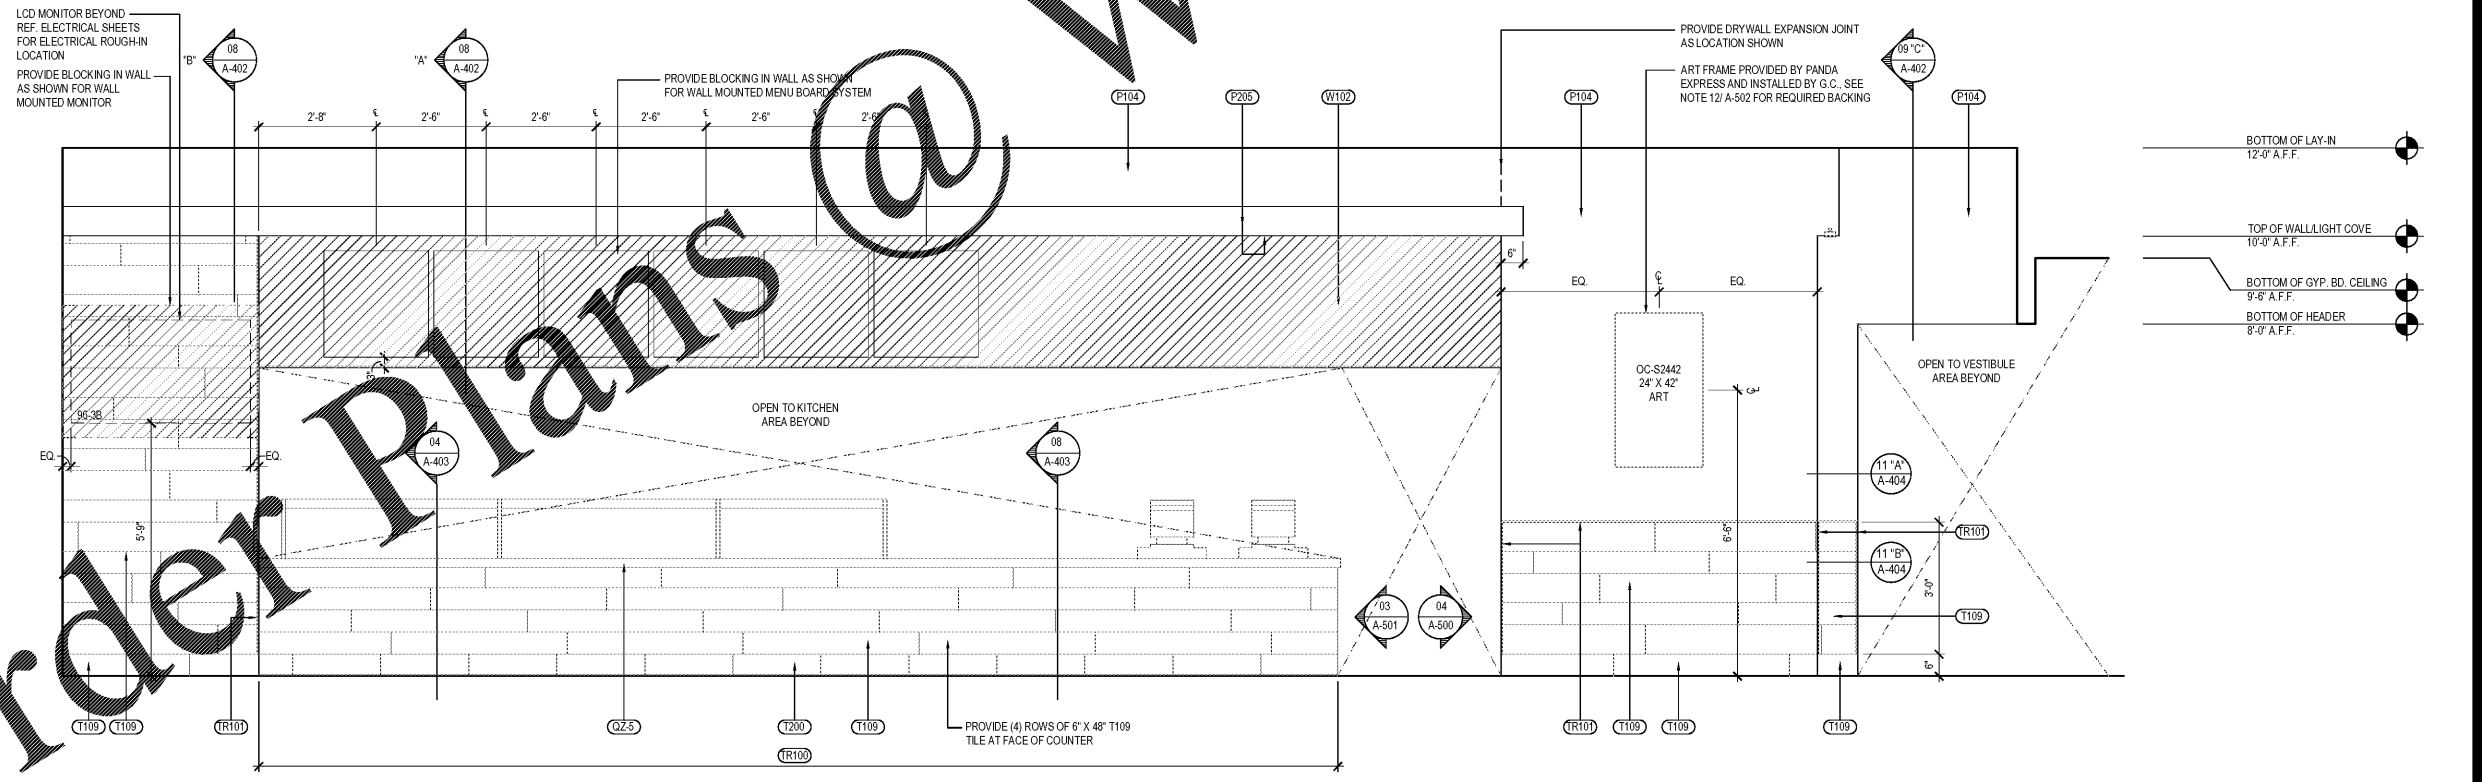

DINING ROOM ELEVATION 1
Scale= 1/2" = 1'-0" A-500



PANDA RESTAURANT GROUP INC.
1683 Walnut Grove Ave.
Rosemead, California
91770
Telephone: 626.799.9898
Facsimile: 626.372.8288



All ideas, designs, arrangement and plans indicated or represented by this drawing are the property of Panda Express Inc. and were created for use on this specific project. None of these ideas, designs, arrangements or plans may be used by or disclosed to any person, firm, or corporation without the written permission of Panda Express Inc.

REVISIONS:

ISSUE DATE:

1	ISSUED FOR BID & PERMIT	12-11-18
2	BID SET	01-30-19

DRAWN BY: JO
PANDA PROJECT # S8-19-D6573
ARCH PROJECT # P7336

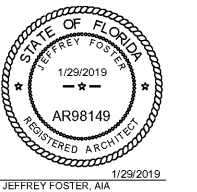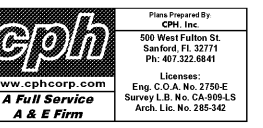

PANDA EXPRESS
WARM & WELCOME 2200
ATLANTIC BLVD & MARKETPLACE DR
JACKSONVILLE, FL 32225

A-500
INTERIOR ELEVATIONS

TRUE WARM & WELCOME 2200

Order Plans @ WWW.LDLine.com

This item has been electronically signed and sealed by Jeffrey Foster, A.I.A. on January 29, 2019 using a digital signature. Printed copies of this document are not considered signed and sealed and the signature must be verified on any electronic copies.