



PANDA RESTAURANT GROUP INC.
1683 Walnut Grove Ave.
Rosemead, California
91770
Telephone: 626.799.9898
Facsimile: 626.372.8288

All ideas, designs, arrangement and plans indicated or represented by this drawing are the property of Panda Express Inc. and were created for use on this specific project. None of these ideas, designs, arrangements or plans may be used by or disclosed to any person, firm, or corporation without the written permission of Panda Express Inc.

REVISIONS:

| NO. | DESCRIPTION | DATE |
|-----|-------------|------|
| | | |
| | | |
| | | |
| | | |
| | | |

ISSUE DATE:

| | | |
|---|-------------------------|----------|
| 1 | ISSUED FOR BID & PERMIT | 12-11-18 |
| 2 | BID SET | 01-30-19 |

DRAWN BY: EJP

PANDA PROJECT # S8-19-D6573
ARCH PROJECT # P7336

cph Corp.
www.cphcorp.com
A Full Service A & E Firm

Plans Prepared by
CPI, Inc.
500 West Fulton St.
Sanford, FL 32771
Ph: 407-322-8841

Licenses:
Eng. C.O.A. No. 2750-E
Survey L.B. No. CA-509-LS
Arch. Lic. No. 285-342




PANDA EXPRESS
WARM & WELCOME 2200
ATLANTIC BLVD & MARKETPLACE DR
JACKSONVILLE, FL 32225

E-100

POWER FLOOR PLAN

TRUE WARM & WELCOME 2200

NO UNDER SLAB ELECTRICAL WORK ALLOWED UNLESS OTHERWISE NOTED ON PLAN.

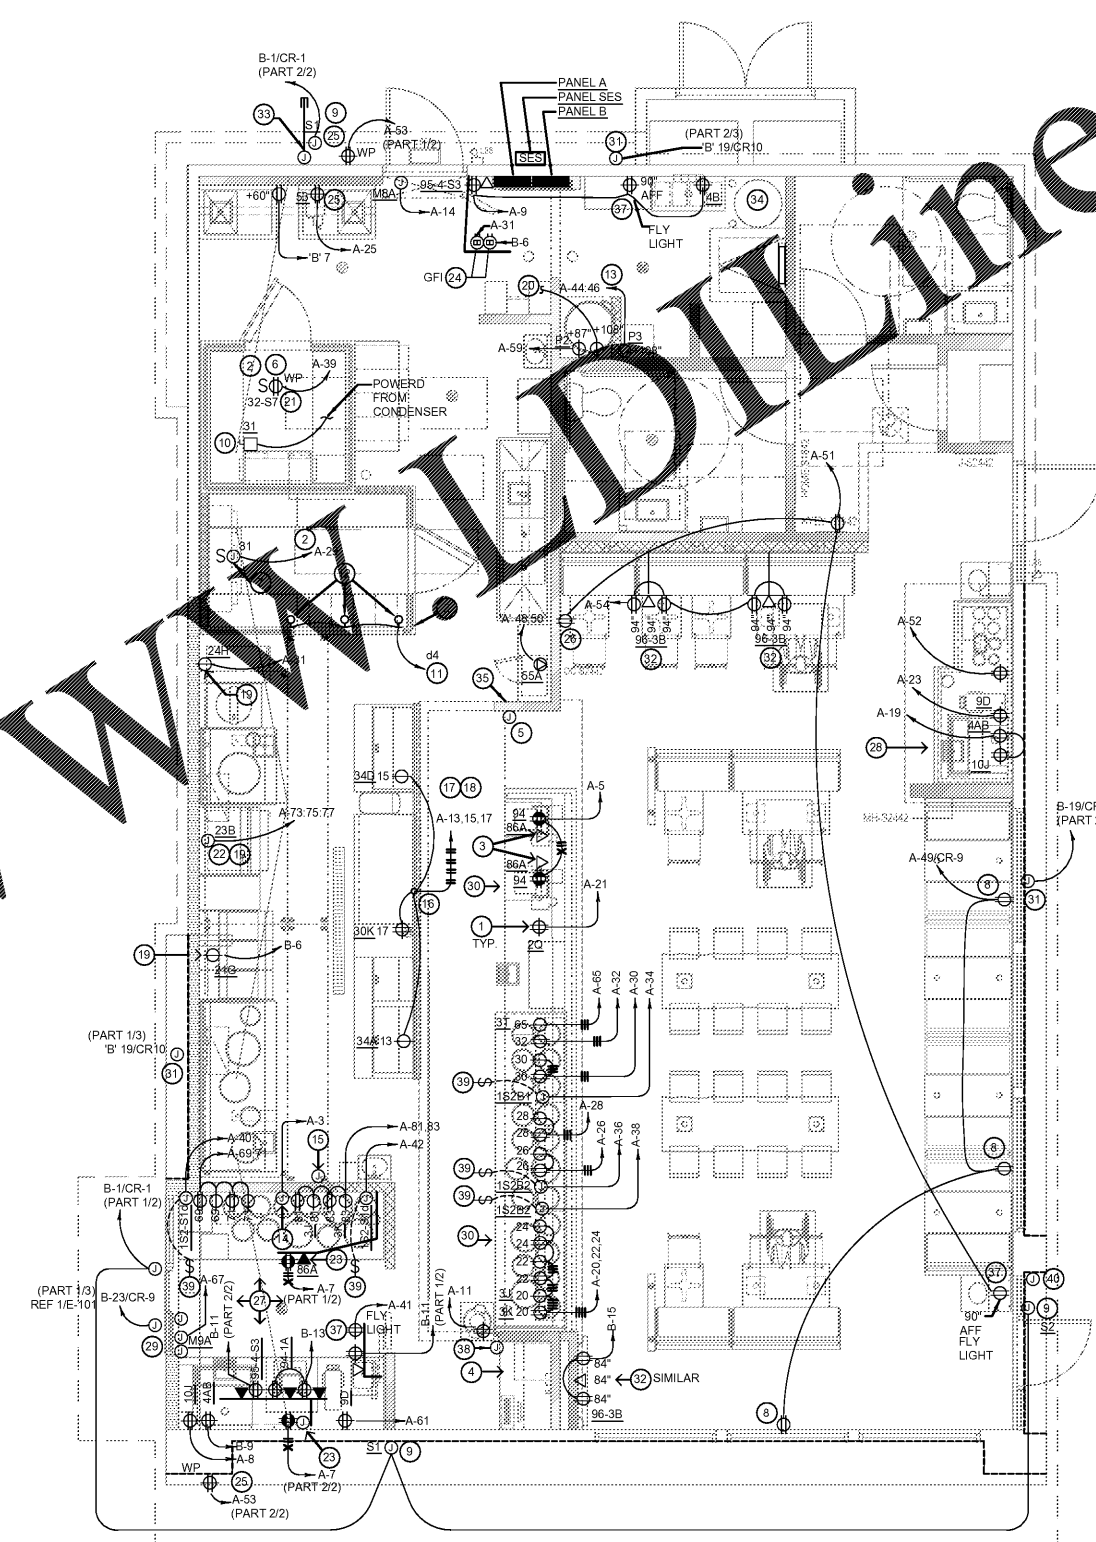

ALL 120 VOLT, 20 AMP RECEPTACLES LOCATED UNDER COUNTERS WITHIN SERVING AREA 101, DRIVE-THRU 102, AND KITCHEN 103 TO BE SERVED FROM GFCI-TYPE CIRCUIT BREAKERS PER NEC 210.8 (B) (2).

1. VERIFY ALL HVAC & KITCHEN EQUIPMENT PRIOR TO ROUGH IN.
2. ALL TELEPHONE/DATA/TV CABLES AND WIRES, TERMINATIONS, AND ALL REQUIRED CABLE AND JACKS WILL BE INSTALLED BY THIRD PARTY.
3. POWER SUPPLY FOR COMPUTER, CASH REGISTER (86A & 94) SHALL BE ON THE SAME CIRCUIT BREAKER, W/ISOLATED GROUND & ORANGE RECEPTACLE.
4. ALL CIRCUITRY SHOWN WITHOUT TICKS SHALL HAVE (2) WIRES PLUS EQUIPMENT GROUNDING CONDUCTOR.
5. ALL MULTI-WIRE BRANCH CIRCUITS SHALL HAVE SEPARATE NEUTRALS TO MEET THE REQUIREMENTS OF NEC 210.4(B).
6. TRANSFORMERS SHALL BE MOUNTED ABOVE CEILING BELOW TRUSSES WITH LOW VOLTAGE WIRING FEEDING TO ALL EXTERIOR LIGHTS.

POWER PLAN GENERAL NOTES 2

NOT TO SCALE E-100

1. ALL CIRCUITRY/CONDUIT FOR FRONT LINE EQUIPMENT TO BE ROUTED IN CASEWORK TO J-BOX IN WALL AND CONCEAL IN WALL.
2. PROVIDE SEALS AND EXPANSION COUPLINGS ON ALL CONDUITS ENTERING / LEAVING AREA OF TEMPERATURE DIFFERENCE.
3. PROVIDE (2) 1-1/2" CONDUITS WITH PULL STRINGS FROM CASH REGISTER TO MANAGER STATION.
4. SEE 'MANAGER STATION ELEVATION' 1 / E-200 FOR ADDITIONAL OUTLETS AND J-BOXES.
5. ANSUL PULL STATION REFER TO DETAIL, SHEET 2 / E-400.
6. REFER TO 'LTS AND DOOR HEATER' WIRING DIAGRAM, SHEET 10 / E-400.
7. REFER TO 'COOLER EVAPORATOR COIL' WIRING DIAGRAM, SHEET 8 / E-400.
8. SHOW WINDOW RECEPTACLE SHALL BE CONTROLLED VIA SWITCH "C" REFER TO LIGHTING SWITCHBANK SCHEDULE, SHEET 4 / E-101. RECEPTACLE SHALL BE MOUNTED IN WALL AS CLOSE TO TOP OF STRUCTURAL HEADER AS POSSIBLE.
9. W.P. J-BOX FOR SIGNAGE. COORDINATE LOCATION WITH ARCHITECT / OWNER / SIGN PACKAGE. SIGN DISCONNECT PROVIDED BY SIGN CONTRACTOR.
10. REFER TO 'FREEZER EVAPORATOR COIL' WIRING DIAGRAM, SHEET 9 / E-400. CONNECTION FOR HEAT TRACE TAPE INCLUDED IN FREEZER EVAPORATOR COIL. HEAT TAPE PROVIDED AND INSTALLED BY ELECTRICIAN.
11. ROUTE HOMERUN THROUGH LIGHTING SWITCHBANK A-(SWITCH AS NOTED IN LOWER CASE). REFER TO SCHEDULE, SHEET 4 / E-101, FOR MORE INFORMATION.
12. CONNECT TO VEGETABLE DISPLAY LIGHTING PROVIDED WITH WALK-IN COOLER.
13. WATER HEATER. FEED RECEPTACLE WITH 2 #8, 1 #10 GROUND, 3/4" CONDUIT. FURNISH AND INSTALL RECEPTACLE AND CORD AND PLUG. COORDINATE THE EXACT CONFIGURATION WITH THE WATER HEATER SUPPLIER.
14. HOOD CONTROL PANEL / ANSUL SYSTEM CABINET. MOUNT CABINET DIRECTLY BELOW T-BAR CEILING.
15. PROVIDE 2-GANG J-BOX @ 48" AFF FOR HOOD CONTROL SWITCHES. REFER TO M-400, M-401 AND M-402.
16. CONDUIT STUB UP LOCATION IN STAINLESS STEEL POWER PANEL FOR ISLAND KITCHEN EQUIPMENT CONNECTION. REFER TO DETAIL 2 / A-109. COORDINATE LOCATION WITH ARCHITECT / OWNER.
17. ROUTE CABLING / CIRCUITRY THROUGH CONDUIT IN SLAB (KEYED NOTE #16).
18. UTILIZE SEAL TIGHT CONDUIT FOR ALL WIRING INCLUDED ALONG LOW WALL PANEL.
19. ALL DEVICES UNDER HOOD TO BE PROVIDED AND INSTALLED WITH SHUNT TRIP CIRCUIT BREAKER AND WATERPROOFING BOX (RED DOT #CKSVU). REFER TO COOKLINE ELECTRICAL ELEVATIONS, SHEET 6 / E-200.
20. SIMPLEX RECEPTACLE TO BE CONNECTED TO BACK-OF-HOUSE LIGHTING CIRCUITRY/CONTROL CONTRACTOR TO PROVIDE PIGTAIL FROM CIRCULATION PUMP.
21. PROVIDE WEATHERPROOF GFI RECEPTACLE FOR HEAT TAPE. COORDINATE FINAL LOCATION WITH REFRIGERATION INSTALLER.
22. ELECTRIC GRILL '23B', FEED WITH 3 #8, 1 #10 GROUND, 3/4" CONDUIT. REFER TO DETAIL, SHEET 4 / E-200.
23. SEE DRIVE THRU ELEVATION 2/E-200 FOR CONDUIT SIZES AND CONFIGURATIONS.
24. FURNISH AND INSTALL (2) HUBBELL GFSTB20 FACELESS GFCI (OR EQUIVALENT) (1) FOR EACH CIRCUIT FEEDING EQUIPMENT BENEATH THE KITCHEN HOOD WHICH UTILIZE SIMPLEX RECEPTACLES KITCHEN HOOD. INSTALL IN AN ACCESSIBLE LOCATION IN THE GENERAL AREA OR AS DIRECTED BY THE OWNER, ARCHITECT OR ENGINEER. PROVIDE ADDITIONAL OUTLETS AS REQUIRED TO FEED ALL SUCH LOADS BENEATH HOOD. FASTEN A PLASTIC LABEL IDENTIFYING CIRCUIT AND EQUIPMENT SERVED FOR EACH OUTLET.
25. PROVIDE WP, IN-USE RED DOT (#CKSVU).
26. CONTRACTOR TO ENSURE THAT ELECTRICAL OUTLET SHALL FALLS BENEATH TABLE TOP. REFER TO ARCHITECTURAL FURNITURE PLAN FOR EXACT LOCATION.
27. SEE FOR DRIVE-THRU ELEVATIONS, SHEET 2 / E-200.
28. DRINK STATION ELEVATIONS, SHEET 5 / E-200.
29. CONTRACTOR TO FURNISH J-BOX FOR WIRING LIGHT FIXTURES. COORDINATE IN FIELD FOR EXACT LOCATION FOR J-BOX AND ANY ADDITIONAL REQUIREMENTS PRIOR TO STARTING ANY WORK AND INCLUDE ALL ASSOCIATED COSTS IN THE BID.
SEE P.O. AND SERVICE LINE ELEVATIONS, SHEET 3 / E-200.
31. CONTRACTOR TO FURNISH (1) J-BOX (WITH PULL-WIRE) AT THIS LOCATION FOR SET OF EXTERIOR VERTICAL LIGHT FINIS. THE 'SET OF FINIS' ARE POWERED FROM CEILING MOUNTED TRANSFORMERS THAT ARE TO BE LOCATED ABOVE THE CEILING OF THE INTERIOR. UTILIZE CIRCUIT B-19 FROM PANELBOARD B. PROVIDE SEAL TIGHT PENETRATIONS AS REQUIRED. COORDINATE IN FIELD FOR EXACT LOCATIONS FOR J-BOX AND ANY ADDITIONAL REQUIREMENTS PRIOR TO START OF ANY WORK AND INCLUDE ALL ASSOCIATED COSTS IN THE BID.
32. SEE DINING ROOM MONITOR ELEVATION, SHEET 8 / E-200.
33. PROVIDE AND INSTALL 3/4" CONDUIT AND PULL STRING FROM CLOSEST LANDSCAPE AREA, THROUGH WALL UP TO EMPTY FLUSH MOUNTED JUNCTION BOX @ 60" A.F.F. (FOR IRRIGATION CONTROLS). CLOSE OFF CONDUIT IN LANDSCAPE AREA WITH REMOVABLE CAP. UTILIZE CIRCUIT 'B'-7.
34. REFER TO SHEET 9 / E-200 FOR INSTALLATION OF CO2 MONITOR.
35. SEE SWITCH BANK ELEVATION, SHEET 7 / E-200.
36. NOT USED.
37. FLY LIGHT RECEPTACLE SHALL BE INSTALLED WITH A RECESSED CLOCK OUTLET. TYP. OF 3 LOCATIONS.
38. SEE SECURITY KEY PAD ELEVATION 1 / E-200.
39. CONNECT HEAT LAMPS TO COUNTER-MOUNTED SWITCH PROVIDED AND INSTALLED BY CONTRACTOR. REFER TO PLAN FOR LOCATIONS AND QUANTITIES.
40. KNOX BOX LOCATION. MOUNT 72" AFG. PROVIDE 1" C BACK TO FIRE ALARM PANEL.

POWER PLAN KEYED NOTES 3

NOT TO SCALE E-100

POWER FLOOR PLAN 1

Scale: 1/4"=1'-0" E-100

Order Plans @

WWW.DIline.com