

- COORDINATE SERVICE ENTRANCE SECTION, TRANSFORMER, PRIMARY SERVICE, SECONDARY SERVICE, AND SWITCHING CABINET OR POWER POLE LOCATIONS WITH SERVING UTILITY COMPANY AND COMPLY AS REQUIRED.
- CONTRACTOR TO BE RESPONSIBLE FOR COORDINATING AND PROVIDING REQUIRED WORK FOR SUPPLYING ELECTRICAL POWER AND TELEPHONE UTILITIES TO THE BUILDING.
- CONTRACTOR TO PROVIDE ALL TRENCHING, BACKFILL, CONDUIT, PAD, ETC. PER THE SERVING UTILITY COMPANY SHOP DRAWINGS AND SPECIFICATIONS.
- NOT USED.
- MINIMUM CIRCUITRY THIS SHEET TO BE #10, 3/4" CONDUIT.


SITE PLAN GENERAL NOTES 2

E-105

- FEED THROUGH LIGHTING CONTROL PANEL. REF: 5 / E-101.
- NOT USED.
- STUB UP LOCATION FOR (3) 3/4" CONDUITS & PULL STRINGS, TO ENTER BUILDING & UP TO 6" ABOVE CEILING. REFER TO SHEET 1/E-401.
- STUB-UP LOCATION FOR MENU BOARD. SIGN DISCONNECT PROVIDED BY SIGN CONTRACTOR. COORDINATE PRECISE LOCATION WITH ARCHITECT / OWNER.
- NOT USED.
- NOT USED.
- DRIVE-THRU SENSOR LOOP. COORDINATE LOCATION. REFER TO DETAIL 1 / E-401.
- STUB-UP FOR DRIVE-THRU ORDER CONFIRMATION MONITOR. COORDINATE LOCATION WITH ARCHITECT / OWNER.
- STUB UP LOCATION FOR PYLON SIGN OR MONUMENT SIGN. ELECTRICAL CONTRACTOR TO PROVIDE DISCONNECT AT BASE OF SIGN. COORDINATE EXACT LOCATION WITH ARCHITECT/OWNER. CONNECT TO LIGHTING CONTROL PANEL. REFER TO DETAIL 5 / E-101.
- CIRCUIT SHALL BE TURNED OFF FROM 12AM TO 6AM (MINIMUM) TO MEET FBC 2017 ENERGY CODE C405.2.5 EXTERIOR LIGHTING CONTROLS REQUIREMENTS.

SITE PLAN KEYED NOTES 3


E-105

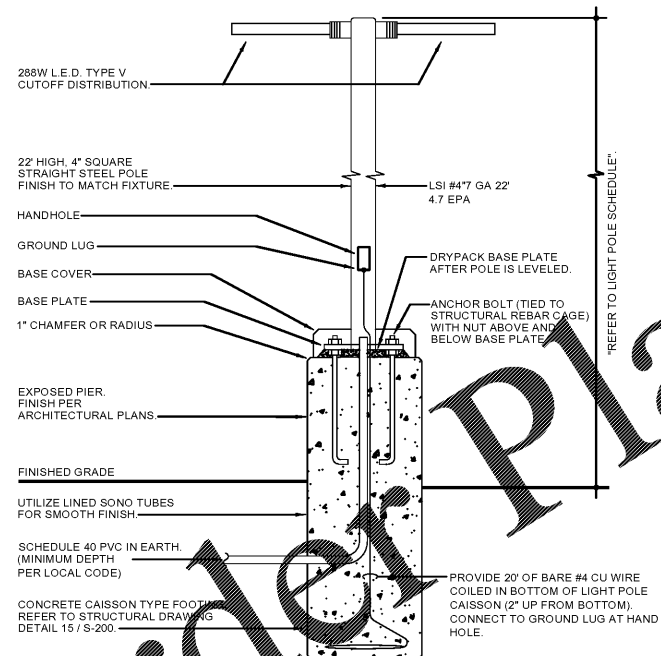

NOTE: POLE AND LIGHTING FIXTURES MEET 150 M.P.H. WIND SPEEDS.

POLE MOUNTING DETAILS 4

NO SCALE E-106

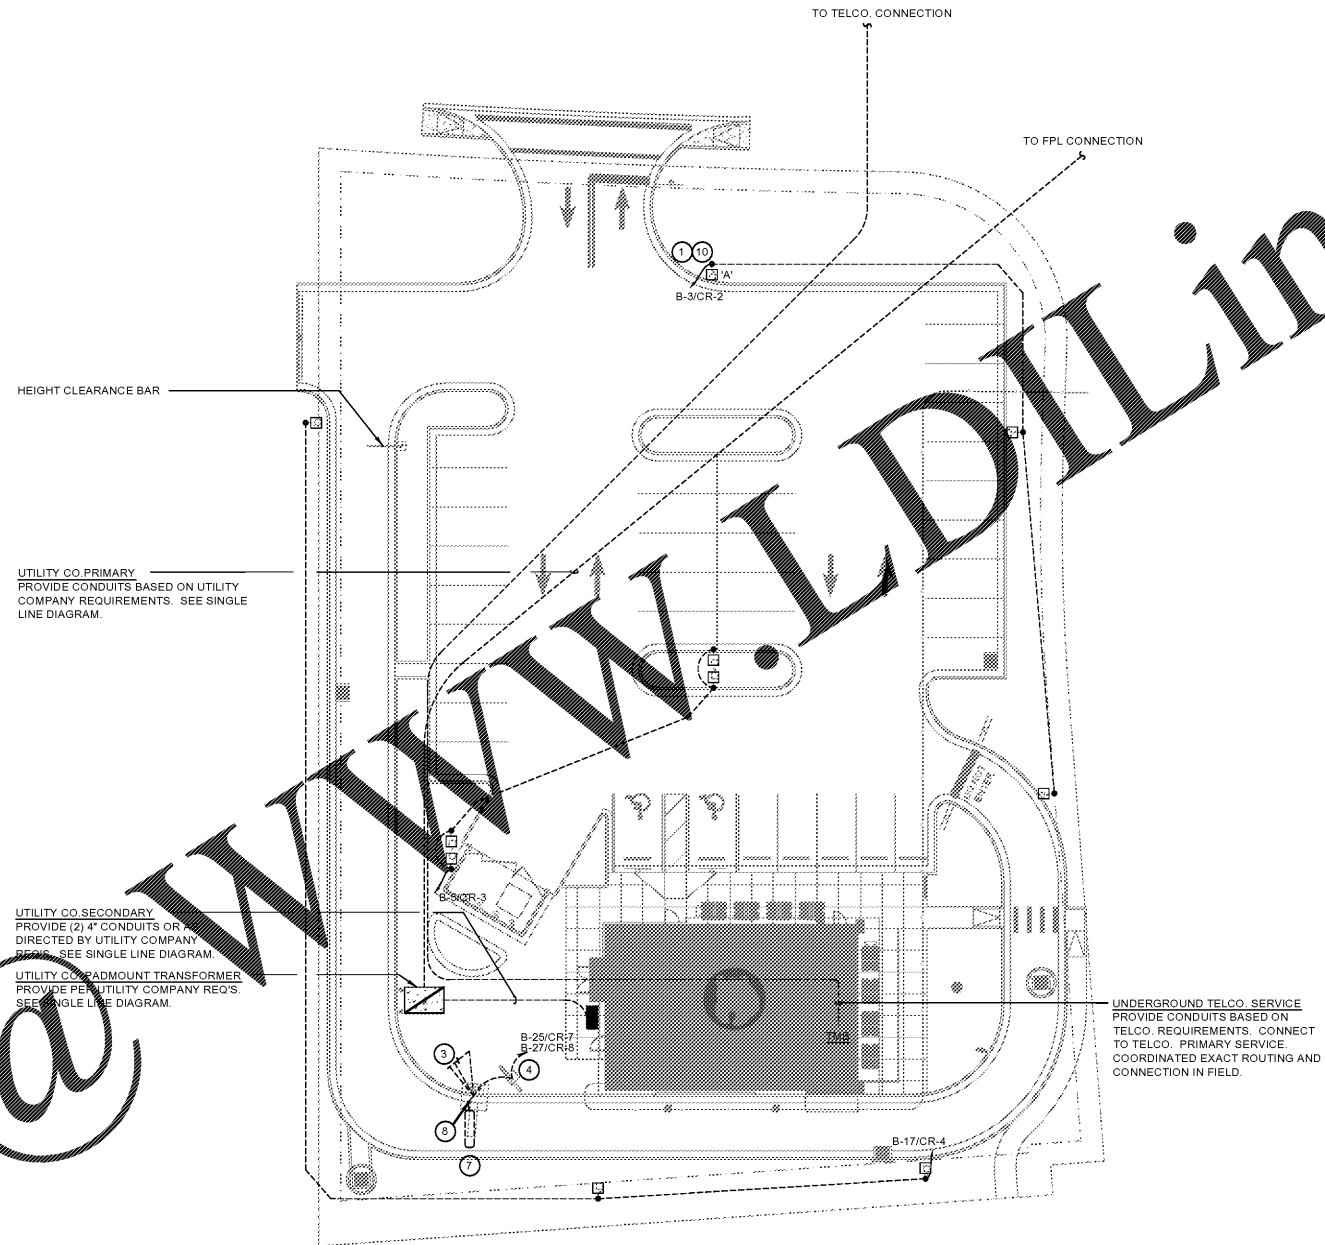

SITE & EXTERIOR LIGHTING PLAN 1

1" = 20'-0" E-105



PANDA RESTAURANT GROUP INC.
1683 Walnut Grove Ave.
Rosemead, California
91770
Telephone: 626.799.9898
Facsimile: 626.372.8288

All ideas, designs, arrangement and plans indicated or represented by this drawing are the property of Panda Express Inc. and were created for use on this specific project. None of these ideas, designs, arrangements or plans may be used by or disclosed to any person, firm, or corporation without the written permission of Panda Express Inc.

REVISIONS:

NO.	DESCRIPTION	DATE

ISSUE DATE:

1	ISSUED FOR BID & PERMIT	12-11-18
2	BID SET	01-30-19

DRAWN BY: E.J.P.

PANDA PROJECT # S8-19-D6573
ARCH PROJECT # P7336

cph Plans Prepared By
CPI, Inc.
500 West Fulton St.
Sanford, FL 32771
Ph: 407-322-8841
Licenses:
Eng. C.O.A. No. 2750-E
Survey L.B. No. CA-699-LS
Arch. Lic. No. 285-342

www.cphcorp.com
A Full Service A & E Firm



PANDA EXPRESS

WARM & WELCOME 2200
ATLANTIC BLVD & MARKETPLACE DR
JACKSONVILLE, FL 32225

E-105

SITE & EXTERIOR LIGHTING PLAN

TRUE WARM & WELCOME 2200