

LIGHTING FIXTURE SCHEDULE

PROVIDED FOR INFORMATION ONLY. VERIFY AND INSTALL PER ELECTRICAL DRAWING

ITEM	SYMBOL	DESCRIPTION	QTY.	MFR. & CAT. NO.	REMARK
L1	[Symbol]	T-BAR CEILING RECESSED MOUNTED LED LIGHTING FIXTURE, 2' X 4', 120V BAKED-ON WHITE ENAMEL FINISH.	7	LSI FIXTURE: SFP24LED-50-UE-DIM-35	KITCHEN CEILING LIGHTS. FURNISHED BY OWNER INSTALLED BY GC
L1B	[Symbol]	T-BAR CEILING RECESSED MOUNTED LED LIGHTING FIXTURE, 2' X 2', 120V BAKED-ON WHITE ENAMEL FINISH.	1	LSI FIXTURE: SFP22LED-30-UE-DIM-35-U	KITCHEN CEILING LIGHTS. FURNISHED BY OWNER INSTALLED BY GC
L1EM	[Symbol]	T-BAR CEILING RECESSED MOUNTED LED LIGHTING EMERGENCY FIXTURE, 2' X 4', 120V BAKED-ON WHITE ENAMEL FINISH.	3	LSI FIXTURE: SFP24LED-50-UE-DIM-EM	EMERGENCY KITCHEN CEILING LIGHTS FURNISHED BY OWNER INSTALLED BY GC
L4H	[Symbol]	UNIVERSAL MOUNT EXIT SIGN, LED LIGHTED, 120V/277V WITH BATTERY PACK, 2 FACE, GREEN LETTER	3	EXITRONIX GVEX-U-BP-WB-BL-R6	EXIT SIGN FURNISHED BY OWNER, INSTALLED BY GC
L6A	[Symbol]	HOOD LIGHT	12	FURNISHED & INSTALLED BY EQUIPMENT SUPPLIER	LIGHTS SUPPLIED & PRE-WIRED BY HOOD VENDOR. ELECTRIC CONTRACTOR TO CONNECT MAIN WIRES TO SHUNT TRIP BREAKER AND HOOD CONTROL PANEL
L6B	[Symbol]	WALK-IN COOLER FLUORESCENT LIGHT, 120 V 48"	2	KASON FIXTURE: # 1810LX4000	FURNISHED BY WIC VENDOR, G.R.E., INSTALLED BY GC
L19	[Symbol]	DOWN LIGHT, RECESSED IN CEILING	41	ELITE HOUSING: LD6IC-AT LED MODULE: RL607-750L-DIMTR-120-30K-FL-SN-SN	FURNISHED BY OWNER, INSTALLED BY GC
L19EM	[Symbol]	EMERGENCY DOWN LIGHT, RECESSED IN CEILING	6	ELITE HOUSING: LD6IC-AT LED MODULE: ELITE LED LIGHTING RL607-14W-120-FL-30K-SN-SN	EMERGENCY RECESSED DOWN LIGHT - NORMALLY ON INVERTER UNIT - ISOLITE, IM-12LC-V1 FURNISHED BY OWNER INSTALLED BY GC
L20	[Symbol]	3 3/4" ADJUSTABLE MR16 DOWN LIGHT, RECESSED IN CEILING	15	LIGHTOLIER: LYTECASTER-378WHX FRAME-IN KIT: 302MRSPX BULB: MR16 - GE - PRECISE IR 37 WATT 40" BEAM	FURNISHED BY OWNER, INSTALLED BY GC
L26	[Symbol]	DECORATIVE PENDANT LIGHT	8	BENTWOOD PENDANTS: A_CIRCLE B_ONION C_OBLONG D_BARREL BULB: LED EDISON LAMP: 1173467	FURNISHED BY OWNER, INSTALLED BY GC
L30	[Symbol]	WHITE LED AT SERVICE COUNTER SOFFIT & DINING ROOM PARTIAL HEIGHT WALL	47 L.F.	ZLED LIGHTING FIXTURE: MOD-R-5050-WW	FURNISHED BY OWNER, INSTALLED BY GC
L35	[Symbol]	9 8/8" DIA. DECORATIVE ISLA PENDANT LF INCANDESCENT	4	LBL LIGHTING, MODEL #LF512CRSC BULB: LED EDISON LAMP: 1173467	HUNG @ 6'-6" AFF OVER DINING TABLES IN BETWEEN BOOTH FURNISHED BY OWNER, INSTALLED BY GC (VERIFY W/ PANDA)
L38	[Symbol]	NOT USED	-	-	-
L100	[Symbol]	MICRO INVERTER	1	EELP FIXTURE: PS-110-HP-S	FURNISHED BY OWNER, INSTALLED BY GC
S	[Symbol]	SPEAKER	-	-	FURNISHED BY MUSIC VENDOR, INSTALLED BY MUSIC VENDOR

NIGHT LIGHTING REQUIREMENTS: "NL" DESIGNATION INDICATED NIGHT LIGHT ON UNSWITCED CIRCUIT.
 1. ONE NL BY SERVICE COUNTER, POS / CASHIER
 2. ONE NL BY POS / CASHIER AT DRIVE THRU STATION
 3. ONE NL BY EACH EXIT DOOR IN DINING ROOM & BACK OF HOUSE

EXTERIOR LIGHTING


L5A	[Symbol]	WALL MOUNTED OVER SERVICE DOOR FIXTURE	1	HOWARD LIGHTING FIXTURE: VL20	OVER EXTERIOR SERVICE DOOR. REFER ELEVATIONS FOR HEIGHT. FURNISHED BY OWNER, INSTALLED BY GC
L6B	[Symbol]	NAVILITE EMERGENCY LIGHT	2	EXITRONIX MLED1-G-WP	OVER EXTERIOR ENTRANCE & SERVICE DOORS. REFER ELEVATIONS FOR HEIGHT. FURNISHED BY OWNER, INSTALLED BY GC
L6A	[Symbol]	EXTERIOR RECESS EMERGENCY LIGHT	1	ELITE HOUSING: LD6IC-AT LED MODULE: ELITE LED LIGHTING WET LOCATION: RL607-14W-120-FL-30K-SN-SN - WET LOCATION	EMERGENCY RECESSED DOWN LIGHT - NORMALLY ON INVERTER UNIT - ISOLITE, IM-12LC-V1 FURNISHED BY OWNER INSTALLED BY GC
L90	[Symbol]	DECORATIVE LED WALL SCONCE	2	HINKLEY LIGHTING, ATLANTIS, BRONZE, 1649BZLED	AT PORTAL OF ENTRY DOOR. REFER ELEVATIONS FOR HEIGHT. FURNISHED BY OWNER, INSTALLED BY GC
L40	[Symbol]	LINEAR LIGHT AT EXTERIOR STORAGE ROOM	1	COOPER MX-4VT2-LD4-6-DR-UNV-L840-CD1-WL-U	FURNISHED BY OWNER, INSTALLED BY GC

CEILING SCHEDULE

INSTALLED AND FURNISHED BY: G.C. UNLESS NOTED OTHERWISE


NO	MANUFACTURER	DESCRIPTION	MATERIAL	FINISH
C1	ARMSTRONG	2' X 2' SUSPENDED T-BAR GRID CEILING SYSTEM	CUSTOM	T-BAR AND GRID COLOR: SEPIA CONTACT AT ARMSTRONG-SHERRY BRUNT 1-800-442-4212
C2	USG	2' X 4' SUSPENDED T-BAR GRID CEILING SYSTEM	"VINYL ROCK" VINYL CLAD GYP. BD PANELS	SMOOTH AND WASHABLE WHITE
C3	GOLD BOND	MONOLITHIC CEILING PANEL FRAMING	3/8" GYP. BL	SMOOTH PAINT - WHITE AND WASHABLE

SEE SHEET A-103 FOR PAINT SCHEDULE

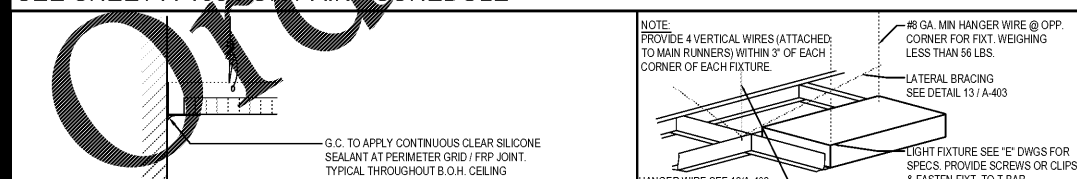

CEILING GRID DETAIL 3 Scale= NTS A-105

LIGHT FIXTURE DETAIL 2 Scale= NTS A-105

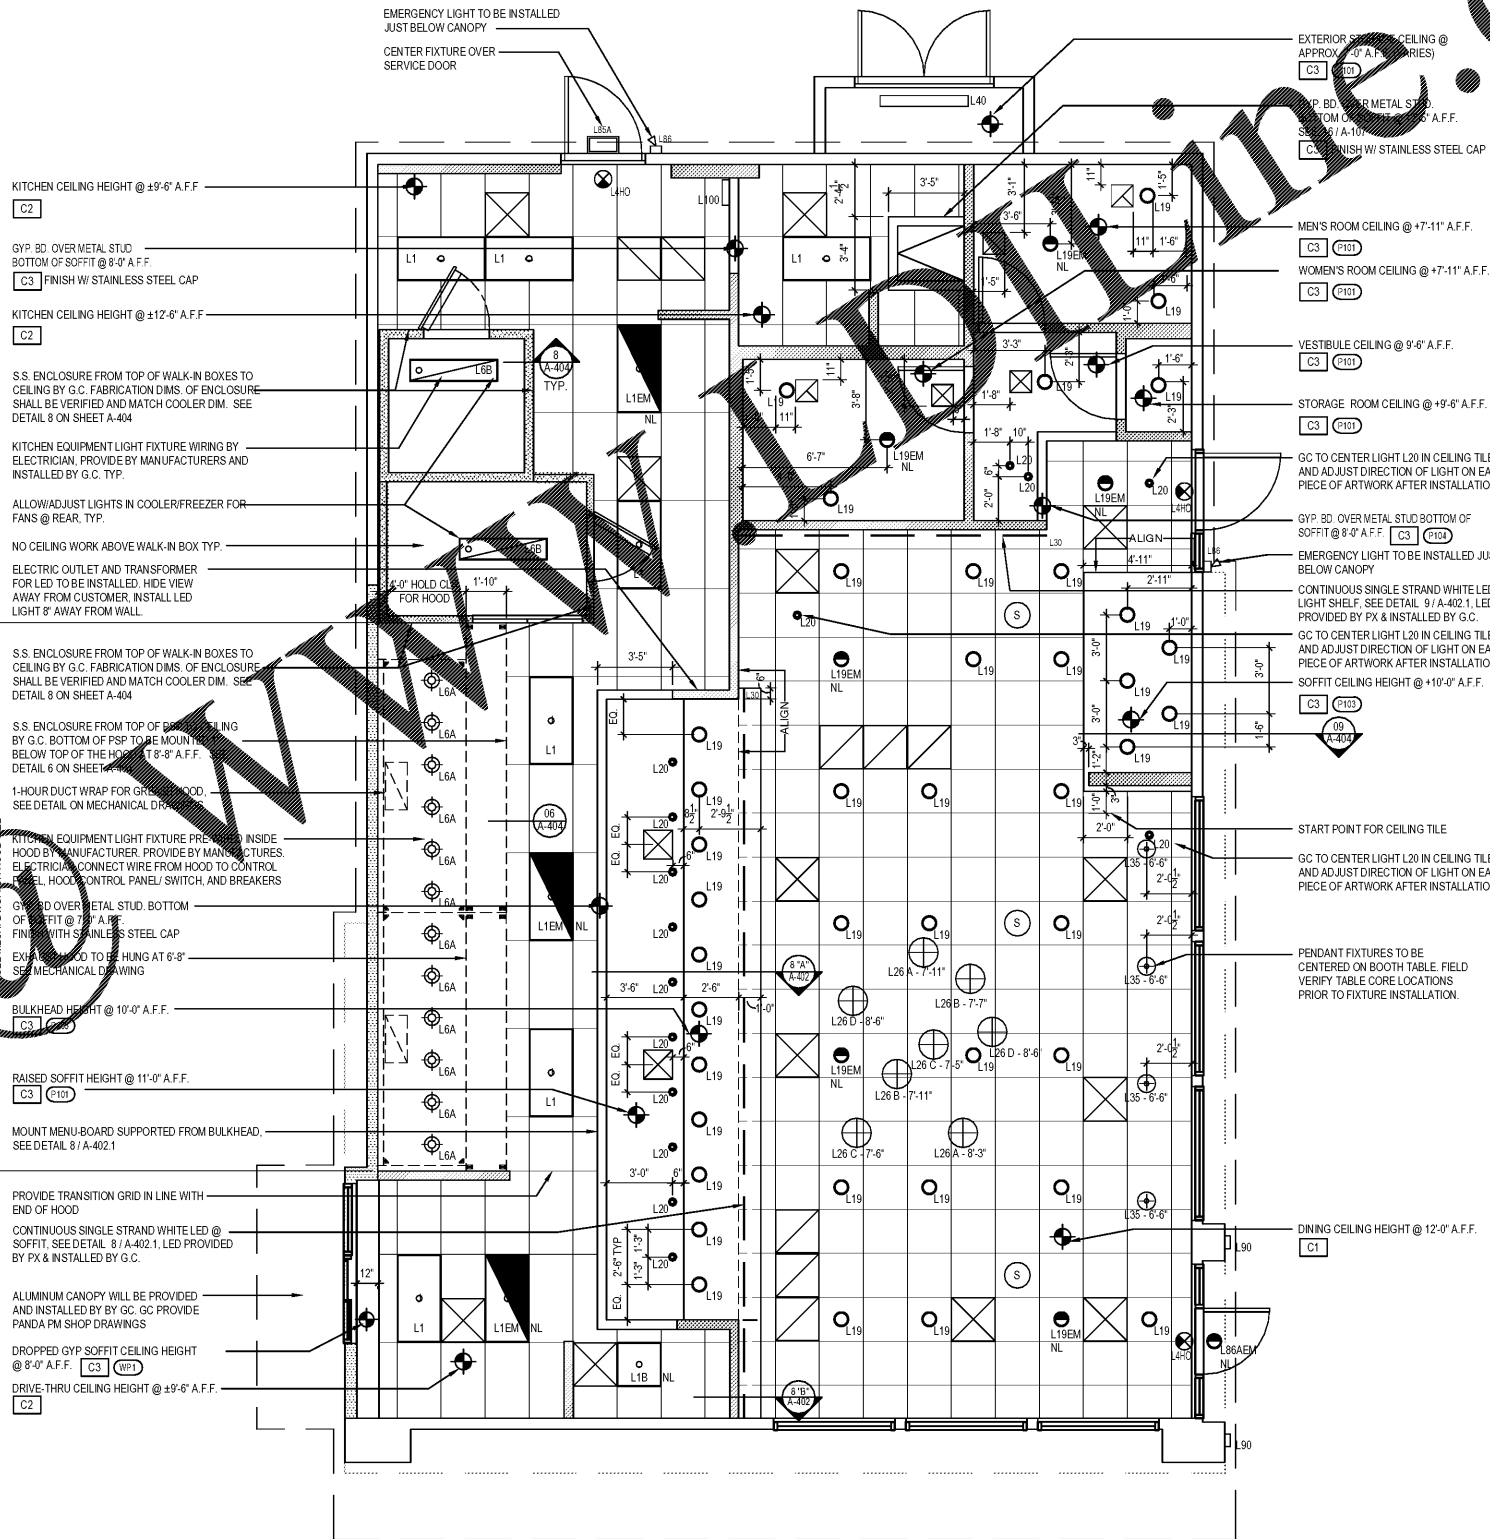

REFLECTED CEILING PLAN 1 Scale= 1/4" = 1'-0" A-105



PANDA EXPRESS, INC.
 1683 Walnut Grove Ave.
 Rosemead, California
 91770
 Telephone: 626.799.9898
 Facsimile: 626.372.8288

All ideas, designs, arrangement and plans indicated or represented by this drawing are the property of Panda Express Inc. and were created for use on this specific project. None of these ideas, designs, arrangements or plans may be used by or disposed to any person, firm, or corporation without the written permission of Panda Express Inc.

REVISIONS:

NO.	DESCRIPTION	DATE

ISSUE DATE:
 1st ISSUE FOR BUILDING PERMIT 08-16-18
 2nd ISSUE FOR BID 11-29-18

DRAWN BY: RR

PANDA PROJECT # S8-19-D6558
 ARCH PROJECT # 1804



315 WALTER ROBERTS ST • FRANKLIN, TN 37064
 PHONE (615) 496-8750 • FAX (666) 584-1265
 REGISTERED FLORIDA ARCHITECT # AR0015526

PANDA EXPRESS
 US 98 and PORTSIDE DRIVE
 3868 GULF BREEZE PARKWAY
 GULF BREEZE, FL
 2200 TRUE - R1 - DAB 12

A-105
 REFLECTED CEILING PLAN