


3 FRONT ELEVATION
A4 1/8" = 1'-0"

NOTE: SIGNAGE TO BE PERMITTED SEPERATELY.

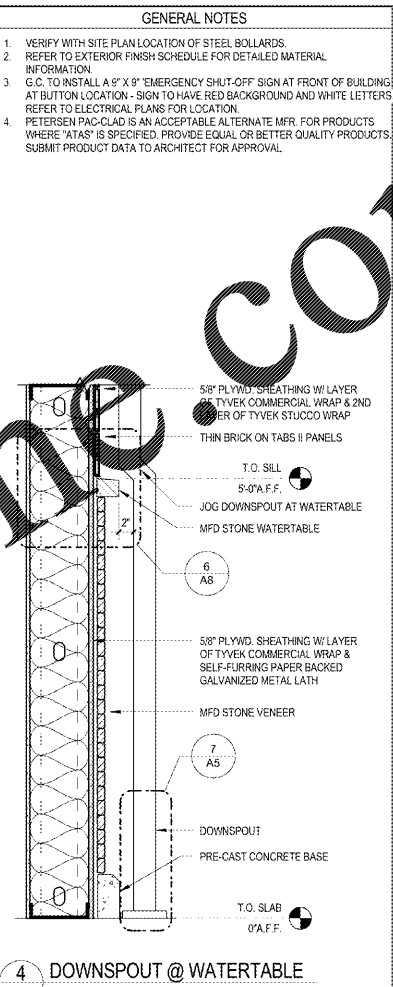


4 DOWNSPOUT @ WATERTABLE
A4 1" = 1'-0"

- GENERAL NOTES
1. VERIFY WITH SITE PLAN LOCATION OF STEEL BOLLARDS.
 2. REFER TO EXTERIOR FINISH SCHEDULE FOR DETAILED MATERIAL INFORMATION.
 3. G.C. TO INSTALL A 6" X 6" EMERGENCY SHUT-OFF SIGN AT FRONT OF BUILDING AT BUTTOW LOCATION - SIGN TO HAVE RED BACKGROUND AND WHITE LETTERS. REFER TO ELECTRICAL PLANS FOR LOCATION.
 4. PETERSEN PAC-CLAD IS AN ACCEPTABLE ALTERNATE MFR. FOR PRODUCTS WHERE "ATAS" IS SPECIFIED, PROVIDE EQUAL OR BETTER QUALITY PRODUCTS. SUBMIT PRODUCT DATA TO ARCHITECT FOR APPROVAL.

1925 Prospect Ave.
Oxandale, MD 21122
(407) 668-1100
(407) 668-9101
www.c-p.com

4
Chulaci & Peterson
Architects Engineers Planners

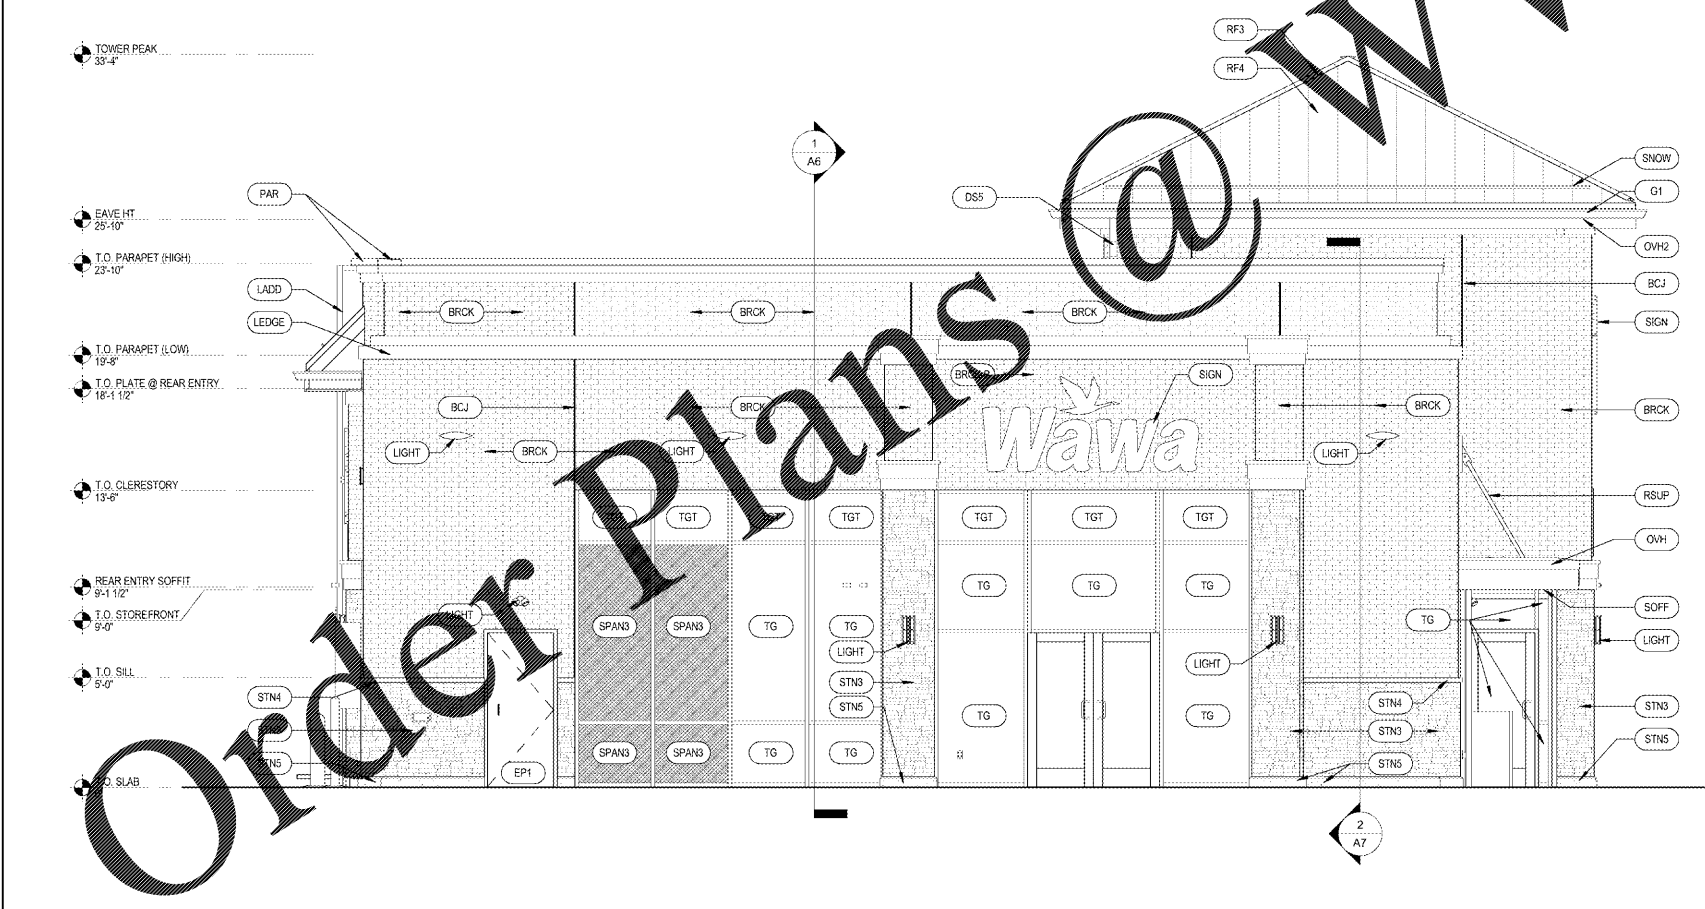

1 LEFT ELEVATION
A4 1/8" = 1'-0"

SYMB	MATERIAL	MFR	COLOR	NOTES
BCJ	BRICK CONTROL JOINT			
BRCK	THIN BRICK	MARION CERAMICS	#900 TAVERN FLASH RED	THIN BRICK ON TABS II PANELS
BRCK-B	THIN BRICK	METRO BRICK SUPPLIER	FIELDSTONE #105	THIN BRICK ON TABS II PANELS SEE A1 FOR LOCATION
CO2	CO2 FILL BOX WITH PVC SLEEVE THRU WALL			
DS	THRU WALL SCUPPER & COLLECTOR AND 3"x4" .032 ALUMINUM DOWNSPOUT	ATAS ALUMINUM CORP.	COMMERCIAL GRADE, SMOOTH, PRE-FINISHED ASCOT WHITE	COORDINATE WITH CIVIL FOR CONNECTION TO STORM SEWER. SEE DETAIL 6 & 7/AS
DS1	3"x4" .032 ALUMINUM DOWNSPOUT	ATAS INTERNATIONAL, INC.	COMMERCIAL GRADE, SMOOTH, ANODIZED ALUM. DARK BRONZE	COORDINATE WITH CIVIL FOR CONNECTION TO STORM SEWER. SEE DETAIL 4/IN AND 8/AS
DS5	3"x4" .032 ALUMINUM DOWNSPOUT	ATAS INTERNATIONAL, INC.	COMMERCIAL GRADE, SMOOTH, ANODIZED ALUM. ASCOT WHITE	PROVIDE WALK PADS ON ROOF
EP1	PAINT	BENJAMIN MOORE	COLOR: WHITE DIAMOND #2121-60 FINISH: EGG SHELL	FOR DOORS AND FRAMES
EP4	PAINT	BENJAMIN MOORE	COLOR: PLUMICE STONE #1197, FINISH: SEMI-GLOSS	
EP6	AZEK TRIM, PAINTED	SHERWIN WILLIAMS	COLOR: SW 7055 ENDURING BRONZE	
G1	ALUMINUM GUTTERS		.032 ALUMINUM COLOR: WHITE	K-STYLE GUTTER, CONTINUOUS - NO SEAMS ALLOWED. SEE DETAIL, SHEET 20/AS
GATE	TUBE STEEL FRAME WITH 1X6 AZEK SMOOTH FINISH SLATS	GENERAL CONTRACTOR	WHITE	
ICE	ICE MERCHANDISER	LEER	PAINT BENJAMIN MOORE, BM OC-1 NATURAL WICKER	
LADD	METAL EXTERIOR LADDER		POWDER COAT, COLOR: SLATE GREY	PROVIDED BY WAWA VENDOR. REFER TO LADDER DETAILS, SHEET A8.1
LEDGE	ALUMINUM FASCIA	ATAS INTERNATIONAL, INC.	ASCOT WHITE	SEE DETAILS A6.2 ALTERNATE: PETERSEN PAC-CLAD
LGD1	LADDER GUARD	VISIONMASTERS EQUIP. CO.	FACTORY FINISH	PROVIDED BY WAWA VENDOR. REFER TO LADDER DETAILS, SHEET A8.1
LIGHT	EXTERIOR LIGHT FIXTURE			SEE ELECTRICAL DRAWINGS
OFS	.032 ALUMINUM 5' X 10' OVERFLOW SCUPPER		PRE-FINISHED WHITE	
OVH	METAL OVERHANG FASCIA	ATAS INTERNATIONAL, INC.	RAPID-LOK FASCIA, CUSTOM EDGE-LOK FASCIA, COLOR: #17 BRUTE RED	SEE DETAILS SHEET A3.1 ALTERNATE: PETERSEN PAC-CLAD
OVH2	HIP ROOF FASCIA	ATAS INTERNATIONAL, INC.	BRAKE METAL, COLOR #10 ASCOT WHITE	SEE DETAILS SHEET A3.1 ALTERNATE: PETERSEN PAC-CLAD
OVH3	SHED ROOF FASCIA	AZEK	AZEK 1X TRIM	MITER CUT ALL CORNERS
PAR	ALUMINUM PARAPET COPING	ATAS INTERNATIONAL, INC.	COLOR TO MATCH ADJACENT TRIM	SEE DETAILS A6.2 ALTERNATE: PETERSEN PAC-CLAD
PVCT	ACCENT TRIM	AZEK	WHITE, FINISH: SMOOTH	PRE-FINISHED, MITER ALL CORNERS; ALTERNATE: PALIGHT
RF3	STANDING SEAM ROOF HIP CAP		TO MATCH METAL ROOFING	
RF4	METAL ROOFING	ATAS INTERNATIONAL, INC.	DUTCH SEAM 19 25" WIDE COLOR SLATE GREY	ALTERNATE: PETERSON PAC-CLAD
RSUP	ROD SUPPURT		POWDER COAT, MATCH SW#6076	SEE STRUCTURAL
SIGN	ILLUMINATED SIGNAGE			SIGN BY WAWA, SURFACE MOUNTED
SNOW	SNOW GUARD	METAL ROOF INNOVATIONS LTD	NATURAL MILL FINISH W/ COLOR STRIP	5-5 COLOR GUARD
SOFF	MPS 120, SOLID AND VENTED	ATAS INTERNATIONAL, INC.	#10 ASCOT WHITE	PORCH / ENTRY SOFFITS, ALTERNATE: PAC CLAD
SPAN3	SPANDREL GLASS, 1" INSULATED TEMPERED	VITRO ARCHITECTURAL GLASS	REFLECTIVE	1/4" CLEAR GLASS, 1/2" AIR GAP, 1/4" PACIFICA WITH SOLARCOOL2 ON SURFACE #3, BLACK FRIT SURFACE #4
STN3	MANUFACTURED STONE VENEER	QUALITY STONE	PROVENCE	STYLE: OHIO DRYSTACK, MORTAR GREY
STN4	PRE-CAST MANUFACTURED STONE	QUALITY STONE	HEWN STANDARD SILL BAND, COLOR: EGG SHELL	36" MIN. LENGTH SECTIONS, VERTICAL GROUT JOINTS: 3/16" MAX WIDTH GROUT WITH QUIKRETE SM100 GRAY
STN5	PRE-CAST STONE BASE	QUALITY STONE	COLOR: EGG SHELL	SEE DETAILS 1 & 2/AS, VERTICAL GROUT JOINTS: 3/16" MAX. WIDTH GROUT WITH QUIKRETE SM100 GRAY
STOR	STOREFRONT SYSTEM	YKK OR KAWNEER	DARK BRONZE	SEE SPECIFICATIONS
TG	1" INSULATED TEMPERED GLASS	OLD CASTLE	CLEAR	SEE SPECIFICATIONS
TGT	1" INSULATED TEMPERED GLASS	PPG	SOLARGRAY VLT. SEE SPECS	SEE SPECIFICATIONS
TH	22" X 30" ACCESS HATCH		COLOR TO MATCH ADJACENT FINISH	FURNISHED BY WAWA, INSTALLED BY G.C. COORD. LOCATION W/ FRAMING IN THE FIELD. SEE DETAIL 20/AS

PROJECT NAME
WAWA U45-FB1-VA-M v2017.01
STORE #6661-STO
Newtown Rd. & Stony Point St.
Norfolk, VA

Revision Schedule	No.	Description	Date
PERMIT SET	05-11-2018		
PRE-BID REVIEW SET	01/09/2019		
BID SET	01/29/2019		

PROJECT NO. 270577
DATE 05-11-18
DRAWN XX
CHECKED SS

EXTERIOR ELEVATIONS

A4