


GENERAL NOTES:

- ELECTRICAL CONTRACTOR TO PROVIDE CONDUIT, OUTLET/BACK BOX AND PULL STRING TO ABOVE ACCESSIBLE CEILING FOR ALL DEVICES, PANELS AND OTHER ELECTRICAL EQUIPMENT LOCATED IN WALL OR HARD CEILING SPACES.
- ALL SECURITY SYSTEM PANELS, DEVICES, CAMERAS, SPEAKERS, AND ASSOCIATED WIRING SUPPLIED AND INSTALLED BY WAWA SECURITY CONTRACTOR.
- CONNECTION BETWEEN SECURITY CAMERA SYSTEM AND FIRE ALARM SYSTEM PANEL SHALL BE A 2 GAUGE/2 PAIR.
- ELECTRICAL CONTRACTOR SHALL PROVIDE (1)18-2 AND (1)18-2 COAX CABLE TO EACH SECURITY CAMERA FROM CAMERA POWER SUPPLY. PROVIDE 2 WHITE 18-2 CONDUCTORS FOR POWER SUPPLY.
- PHONE LINES PROVIDED BY OTHERS, E.C. TO PROVIDE CONDUIT, BOX AND PULL STRING TO ACCESSIBLE ABOVE CEILING SPACE.
- EXTERIOR WALL MOUNTED CAMERAS (NOT UNDER CANOPIES) TO BE MOUNTED AT HEIGHT OF 14 FEET.

KEYNOTES: (X)

- SECURITY CONTRACTOR TO MOUNT OUTSIDE CAMERAS 9 & 10 VIEWING GAS PUMPS. SEE SHEET E4 FOR CONDUITS.
- FOR EXACT LOCATION OF ALL DEVICES IN MANAGER'S OFFICE SEE SHEET A10.
- SECURITY CONTRACTOR SHALL MOUNT SECURITY SPEAKER ABOVE OFFICE CEILING, SECURED TO WALL OR METAL STUD 18 GAUGE/1 PAIR.
- TRASH DOOR SECURITY TIMER RELEASE BUTTON MOUNTED IN OFFICE. SECOND SWITCH MOUNTED TO THE RIGHT OF CORE OPENING IN FIRST CABINET. (NO TIME DELAY NEEDED WITH BATTERIES).
- DELIVERY DOOR TIMER RELEASE BUTTON MOUNTED IN OFFICE BELOW SECURITY KEYPAD. SECOND SWITCH MOUNTED TO THE LEFT OF CORE OPENING IN FIRST CABINET. THIRD BUTT MOUNTED UNDER FRONT COUNTER OF FOOD SERVICE AREA.
- MOUNT SECURITY PANELS 9" FROM FLOOR. FIELD COORDINATE EXACT LOCATION WITH PROJECT MANAGER.
- FOR SELF SERV WALK-IN CAMEL PROVIDE O/S TYPE RATED FOR COOLER TEMPERATURE.

LEGEND	
(PB)	PUSH BUTTON BUZZER (EXTERIOR)
(PB)	PUSH BUTTON BELL (INTERIOR)
(B)	BUZZER (EXTERIOR) / BELL (INTERIOR)
(CH)	CHIME
(ASP)	SECURITY SYSTEM PANEL
(ASK)	SECURITY SYSTEM KEYPAD
(V-ROOT)	PETROLEUM ALARM
(DC)	DOOR CONTACT
(M)	MOTION DETECTOR
(PB)	PANIC BUTTON
(PB)	PANIC BUTTON WITH LEAD
(S)	SECURITY SPEAKER
(DPS)	DOOR STRIKE POWER SUPPLY
(DS)	DOOR STRIKE
(RTE)	REQUEST TO ENTER
(C)	CAMERA (SHOWING DIRECTION)
(O/S)	CAMERA (OUTSIDE RATED FOR TEMPERATURE AND WEATHER)
(TVM)	MONITOR FOR CAMERAS (CCTV)

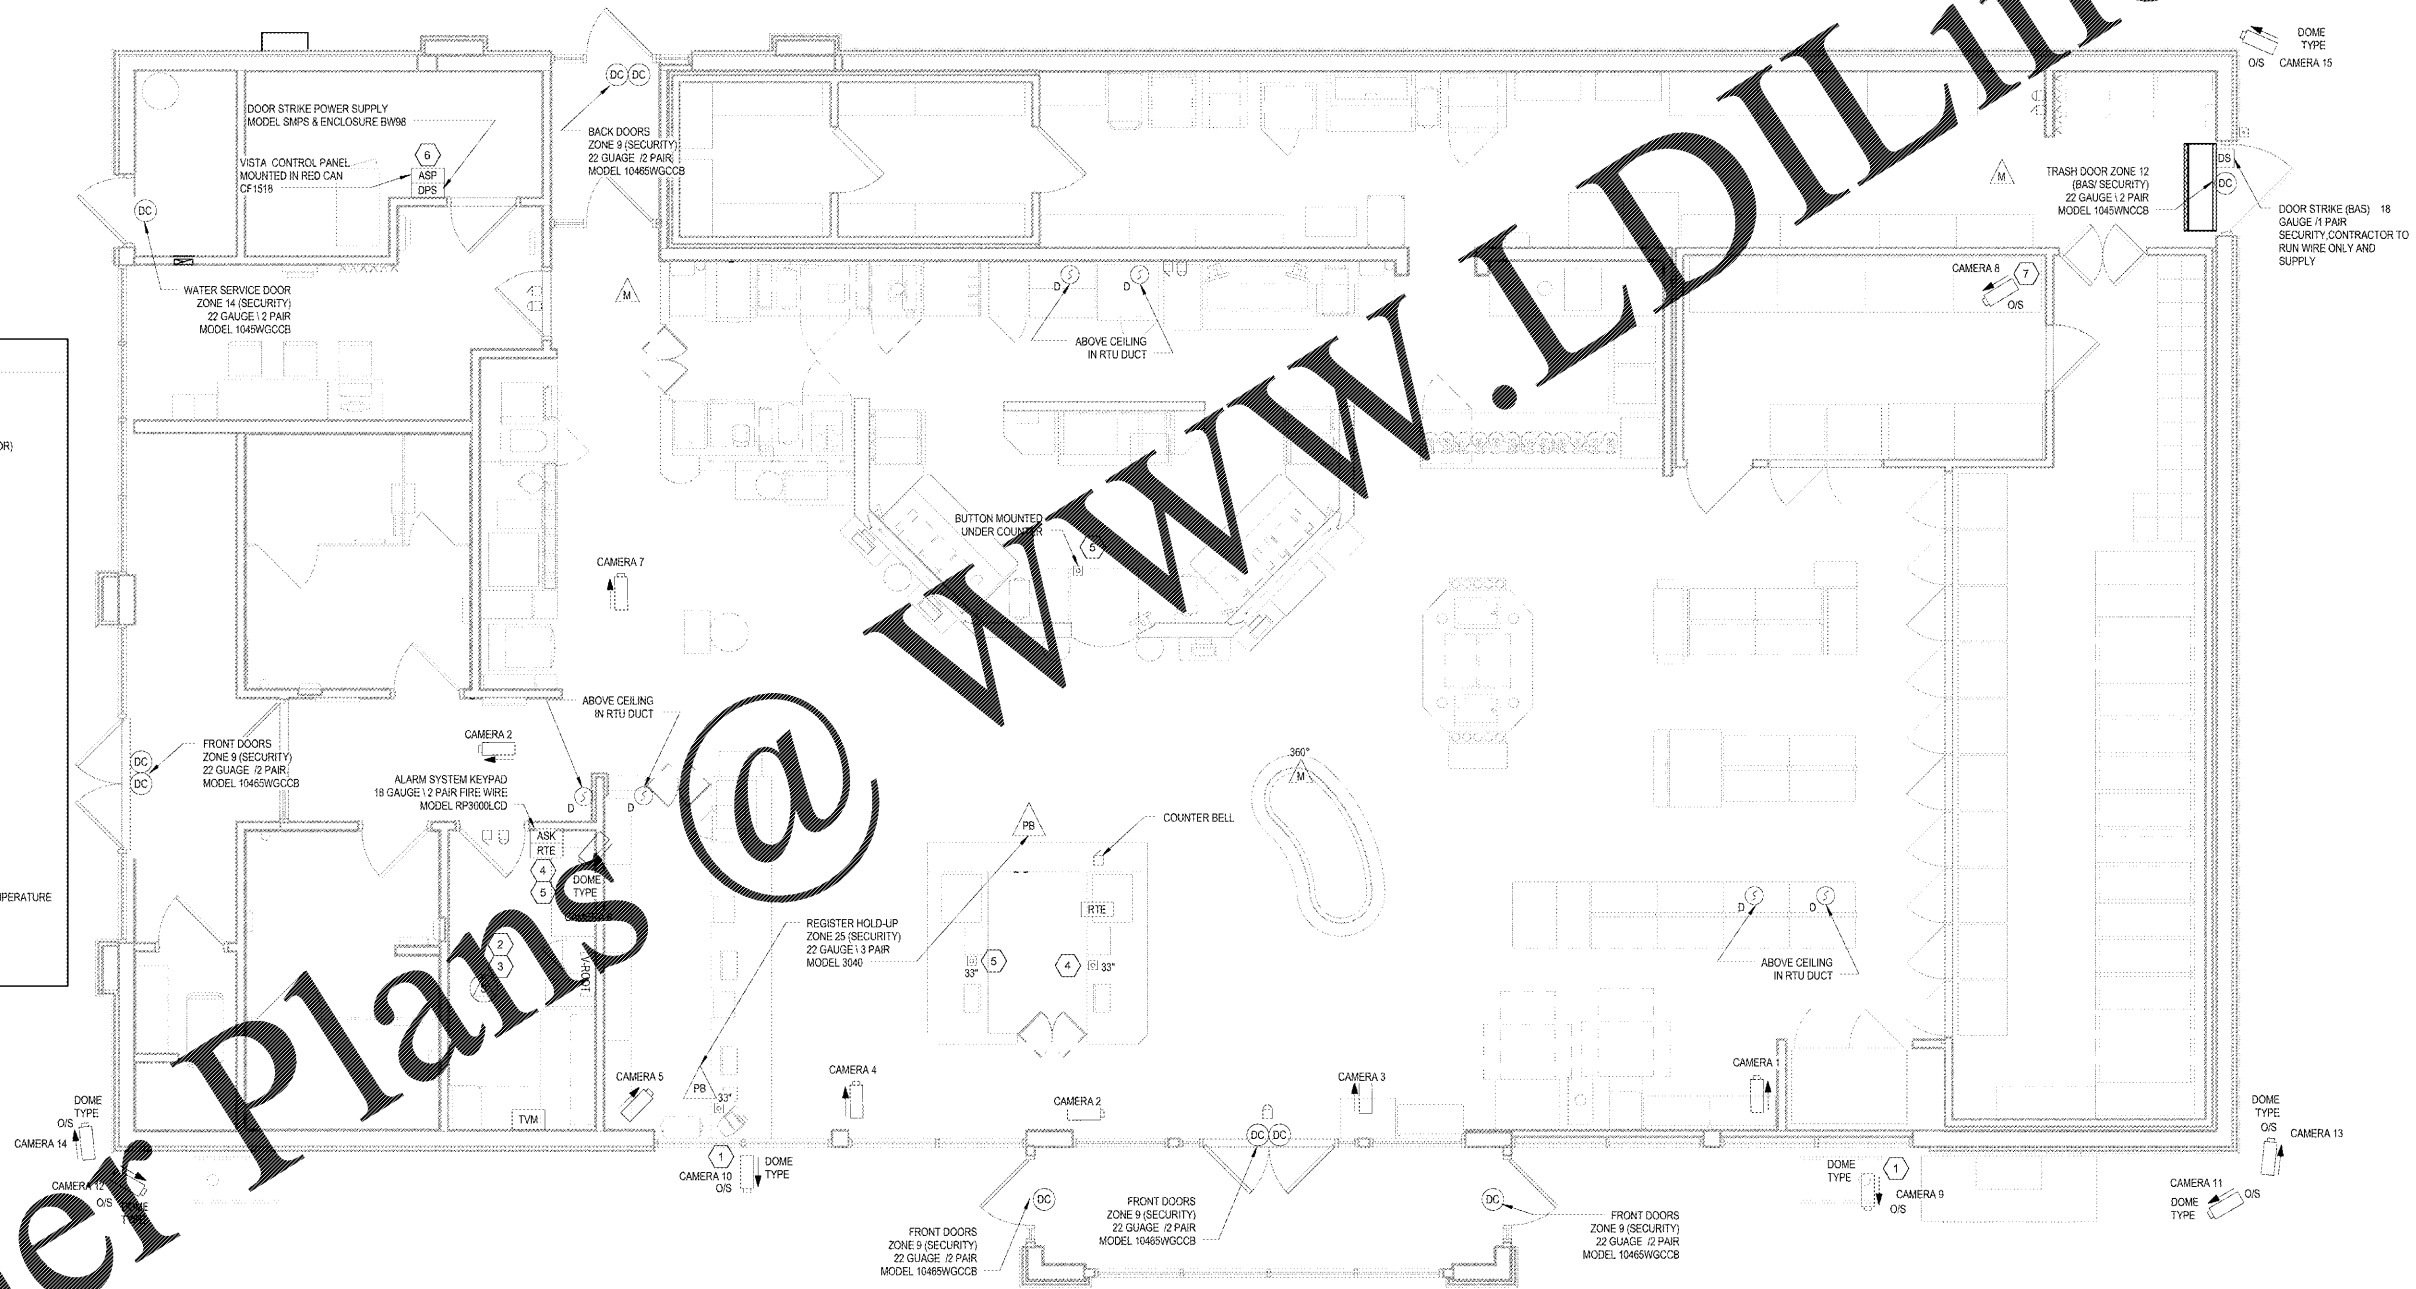

1 SECURITY SYSTEM PLAN
1/4" = 1'-0"

1925 Prospect Ave.
Oxford, MS 38814
(407) 668-1100
(407) 668-9101
www.c-p.com

Chahaci & Peterson
Architects Engineers Planners

PROJECT NAME
WAWA
260 W. BALTIMORE PIKE
WAWA, PA 19063

PROJECT NAME
WAWA U45-FB-LVA-M v2017.01
STORE #6681-STO
Newtown Rd. & Stony Point St.
Norfolk, VA

Revision Schedule	
No.	Date
PERMIT SET	05/11/2018
PRE-BID REVIEW SET	01/09/2019
BID SET	01/29/2019

PROJECT NO.	DATE	DRAWN	CHECKED
270577	05-11-18	MLB	JM

E10

ELECTRICAL SECURITY SYSTEM PLAN

Order Plans

WWW.LDILINE.COM

Copyright © 2018, Chahaci & Peterson, Architects, Engineers, Planners, Inc. All rights reserved. No part of this document may be reproduced or transmitted in any form or by any means, electronic or mechanical, including photocopying, recording, or by any information storage and retrieval system, without the prior written permission of Chahaci & Peterson, Architects, Engineers, Planners, Inc.