


4 DOWNSPOUT @ WATERTABLE  
1" = 1'-0"

3 FRONT ELEVATION  
1/4" = 1'-0"

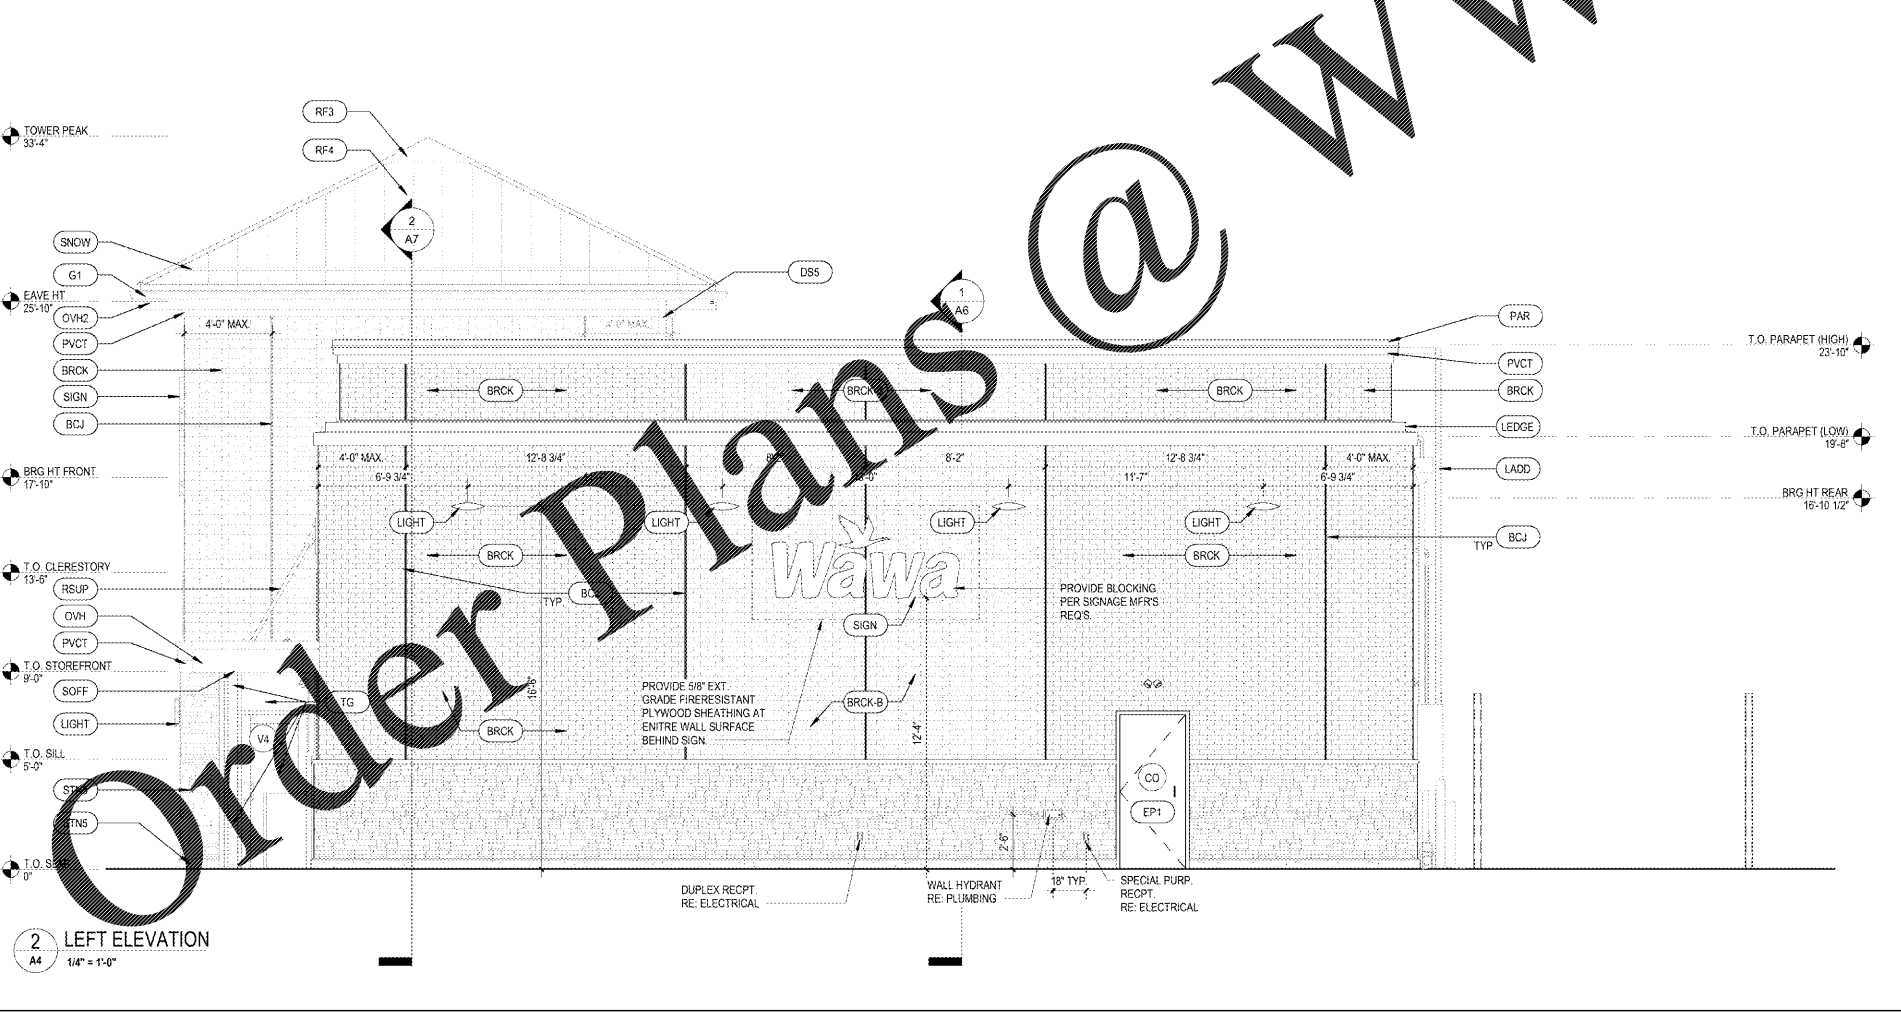

2 LEFT ELEVATION  
1/4" = 1'-0"

EXTERIOR FINISH SCHEDULE				
SYMB	MATERIAL	MFR	COLOR	NOTES
BCJ	BRICK CONTROL JOINT			
BRCK	THIN BRICK	MARION CERAMICS	#300 TAVERN FLASH RED	THIN BRICK ON TABS II PANELS
BRCK-B	THIN BRICK	METRO BRICK SUPPLIER	FIELDSTONE #105	THIN BRICK ON TABS II PANELS
C02	CO2 FILL BOX WITH PVC SLEEVE THRU WALL			SEE A1 FOR LOCATION
DS	THRU WALL SCUPPER & COLLECTOR AND 3"x4" 032 ALUMINUM DOWNSPOUT	ATAS ALUMINUM CORP.	COMMERCIAL GRADE, SMOOTH, PRE FINISHED ASCOT WHITE	COORDINATE WITH CIVIL FOR CONNECTION TO STORM SEWER. SEE DETAIL 6 & 7/AS
DS1	3"x4" 032 ALUMINUM DOWNSPOUT	ATAS INTERNATIONAL, INC.	COMMERCIAL GRADE, SMOOTH, ANODIZED ALUM. DARK BRONZE	COORDINATE WITH CIVIL FOR CONNECTION TO STORM SEWER. SEE DETAIL 4/A4 AND 8/AS
DS5	3"x4" 032 ALUMINUM DOWNSPOUT	ATAS INTERNATIONAL, INC.	COMMERCIAL GRADE, SMOOTH, ANODIZED ALUM. ASCOT WHITE	PROVIDE WALK PADS ON ROOF
EP1	PAINT	BENJAMIN MOORE	COLOR: WHITE DIAMOND #2121-60	FOR DOORS AND FRAMES
EP4	PAINT	BENJAMIN MOORE	COLOR: PLUMICE STONE #1197, FINISH: SEMI-GLOSS	
G1	ALUMINUM GUTTERS		032 ALUMINUM COLOR, WHITE	K-STYLE GUTTER, CONTINUOUS - NO SEAMS ALLOWED. SEE DETAIL, SHEET 20A3
GATE	TUBE STEEL FRAME WITH 1X6 AZEK SMOOTH FINISH SLATS	GENERAL CONTRACTOR LEER	WHITE	SEE A12 FOR DETAILS
ICE	ICE MERCHANTISER		PAINT BENJAMIN MOORE, BM OC-1 NATURAL WICKER	
LADD	METAL EXTERIOR LADDER		POWDER COAT, COLOR: SLATE GREY	PROVIDED BY WAWA VENDOR. REFER TO LADDER DETAILS, SHEET A8.1
LEDGE	ALUMINUM FASCIA	ATAS INTERNATIONAL, INC.	ASCOT WHITE	SEE DETAILS A6.2 ALTERNATE - PETERSEN PAC-CLAD
LGD1	6' LADDER GUARD		FACTORY FINISH	PROVIDED BY WAWA VENDOR. REFER TO LADDER DETAILS, SHEET A8.1
LIGHT	EXTERIOR LIGHT FIXTURE			SEE ELECTRICAL DRAWINGS
OF5	032 ALUMINUM 5" X 10" OVERFLOW SCUPPER		PRE-FINISHED WHITE	
OVH	METAL OVERHANG FASCIA	ATAS INTERNATIONAL, INC.	RAPID-LOK FASCIA AND RAPID-LOK COPING - COLOR: #117-BRICE-RED	SEE DETAILS SHEET A3.1 ALTERNATE - PETERSEN PAC-CLAD
OVH2	HIP ROOF FASCIA	ATAS INTERNATIONAL, INC.	WHITE	SEE DETAILS SHEET A3.1 ALTERNATE - PETERSEN PAC-CLAD
PAR	ALUMINUM PARAPET COPING	ATAS INTERNATIONAL, INC.	COLOR TO MATCH ADJACENT TRIM	SEE DETAILS A6.2 ALTERNATE - PETERSEN PAC-CLAD
PVCT	ACCENT TRIM	AZEK	WHITE, FINISH: SMOOTH	PRE-FINISHED. MATCH ALL CORNERS; ALTERNATE: PAUNIGHT
RF3	STANDING SEAM ROOF HIP CAP		TO MATCH METAL ROOFING	
RF4	METAL ROOFING	ATAS INTERNATIONAL, INC.	DUTCH SEAM 19.25" WIDE COLOR SLATE GREY	ALTERNATE - PETERSON PAC-CLAD
RSUP	ROD SUPPORT		POWDER COAT, MATCH SW#6076	SEE STRUCTURAL
SIGN	ILLUMINATED SIGNAGE			SIGN BY WAWA, SURFACE MOUNTED
SNOW	SNOW GUARD	METAL ROOF INNOVATIONS, LTD.	NATURAL MILL FINISH W/ COLOR STRIP	S-5 COLOR GUARD
SOFF	MPS 120, SOLID AND VENTED	ATAS INTERNATIONAL, INC.	#10 ASCOT WHITE	PORCH / ENTRY SOFFITS, ALTERNATE: PAC CLAD
SPAN3	SPANDREL GLASS, 1" INSULATED TEMPERED	VITRO ARCHITECTURAL GLASS	REFLECTIVE	1/4" CLEAR GLASS, 1/2" AIR GAP, 1/4" PACIFICA WITH SOLARCOOL2 ON SURFACE #3, BLACK FRIT SURFACE #4
STL	COATING	CARBODINE	CARBOTHANE 133LV COLOR: WHITE #1803	GALV PRE-FINISHED & PRIMED, PTD BY CC
STN3	MANUFACTURED STONE VENEER	QUALITY STONE	PROVENCE	STYLE: O-HIDRYS/STACK, MORTAR GREY
STN4	PRE-CAST MANUFACTURED STONE WATERTABLE/SILL	QUALITY STONE	HEWEN STANDARD SILL BAND, COLOR: EGGSHELL	36" MIN. LENGTH SECTIONS, VERTICAL GROUT JOINTS 3/16" MAX. W/TH GROUT WITH QUIKRETE SM100 GRAY
STN5	PRE-CAST STONE BASE	QUALITY STONE	COLOR: EGGSHELL	SEE DETAILS 1 & 2A8, VERTICAL GROUT JOINTS 3/16" MAX. WIDTH GROUT WITH QUIKRETE SM100 GRAY
STOR	STOREFRONT SYSTEM	YKK OR KAWNEER	DARK BRONZE	SEE SPECIFICATIONS
TG	1" INSULATED TEMPERED GLASS	OLD CASTLE	CLEAR	SEE SPECIFICATIONS
TGT	1" INSULATED TEMPERED GLASS	PPG	SOLARGRAY VLT. SEE SPECS	SEE SPECIFICATIONS
TH	22" X 30" ACCESS HATCH		COLOR TO MATCH ADJACENT FINISH	FURNISHED BY WAWA, INSTALLED BY G.C. COORD. LOCATION W/ FRAMING IN THE FIELD. SEE DETAIL 20A8

GENERAL NOTES

- VERIFY WITH SITE PLAN LOCATION OF STEEL BOLLARDS.
- REFER TO EXTERIOR FINISH SCHEDULE FOR DETAILED MATERIAL INFORMATION.
- G.C. TO INSTALL A 9" X 9" EMERGENCY SHUT-OFF SIGN AT FRONT OF BUILDING AT BUTTON LOCATION. SIGN TO HAVE RED BACKGROUND AND WHITE LETTERS. REFER TO ELECTRICAL PLANS FOR LOCATION.
- PETERSEN PAC-CLAD IS AN ACCEPTABLE ALTERNATE MFR. FOR PRODUCTS WHERE "ATAS" IS SPECIFIED. PROVIDE EQUAL OR BETTER QUALITY PRODUCTS. SUBMIT PRODUCT DATA TO ARCHITECT FOR APPROVAL.

Revision Schedule		Date	
No.	Description	Date	
A	PERMIT SET	09/21/2018	
	REV V2018 01	01/29/2019	
	BID SET	01/28/2019	

1925 Prospect Ave.  
Owensboro, KY 40301  
(407) 668-1100  
(407) 668-9101  
www.c-p.com

**WAWA**  
280 W. BALTIMORE PIKE  
WAWA, PA 19083

PROJECT NAME  
U45-VA V2018 01-MA  
STORE #6647-PHM  
PARRHAM RD. & THREE CHOPT RD.  
HENRICO, VA

CLIENT NAME  
WAWA

ARCHITECTS  
**Chuhaci & Peterson**  
Architects Engineers Planners

EXTERIOR ELEVATIONS

2/18/20  
DATE  
09-21-2018  
DRAWN  
OR  
CHECKED  
RS

A4