


# Order Plans

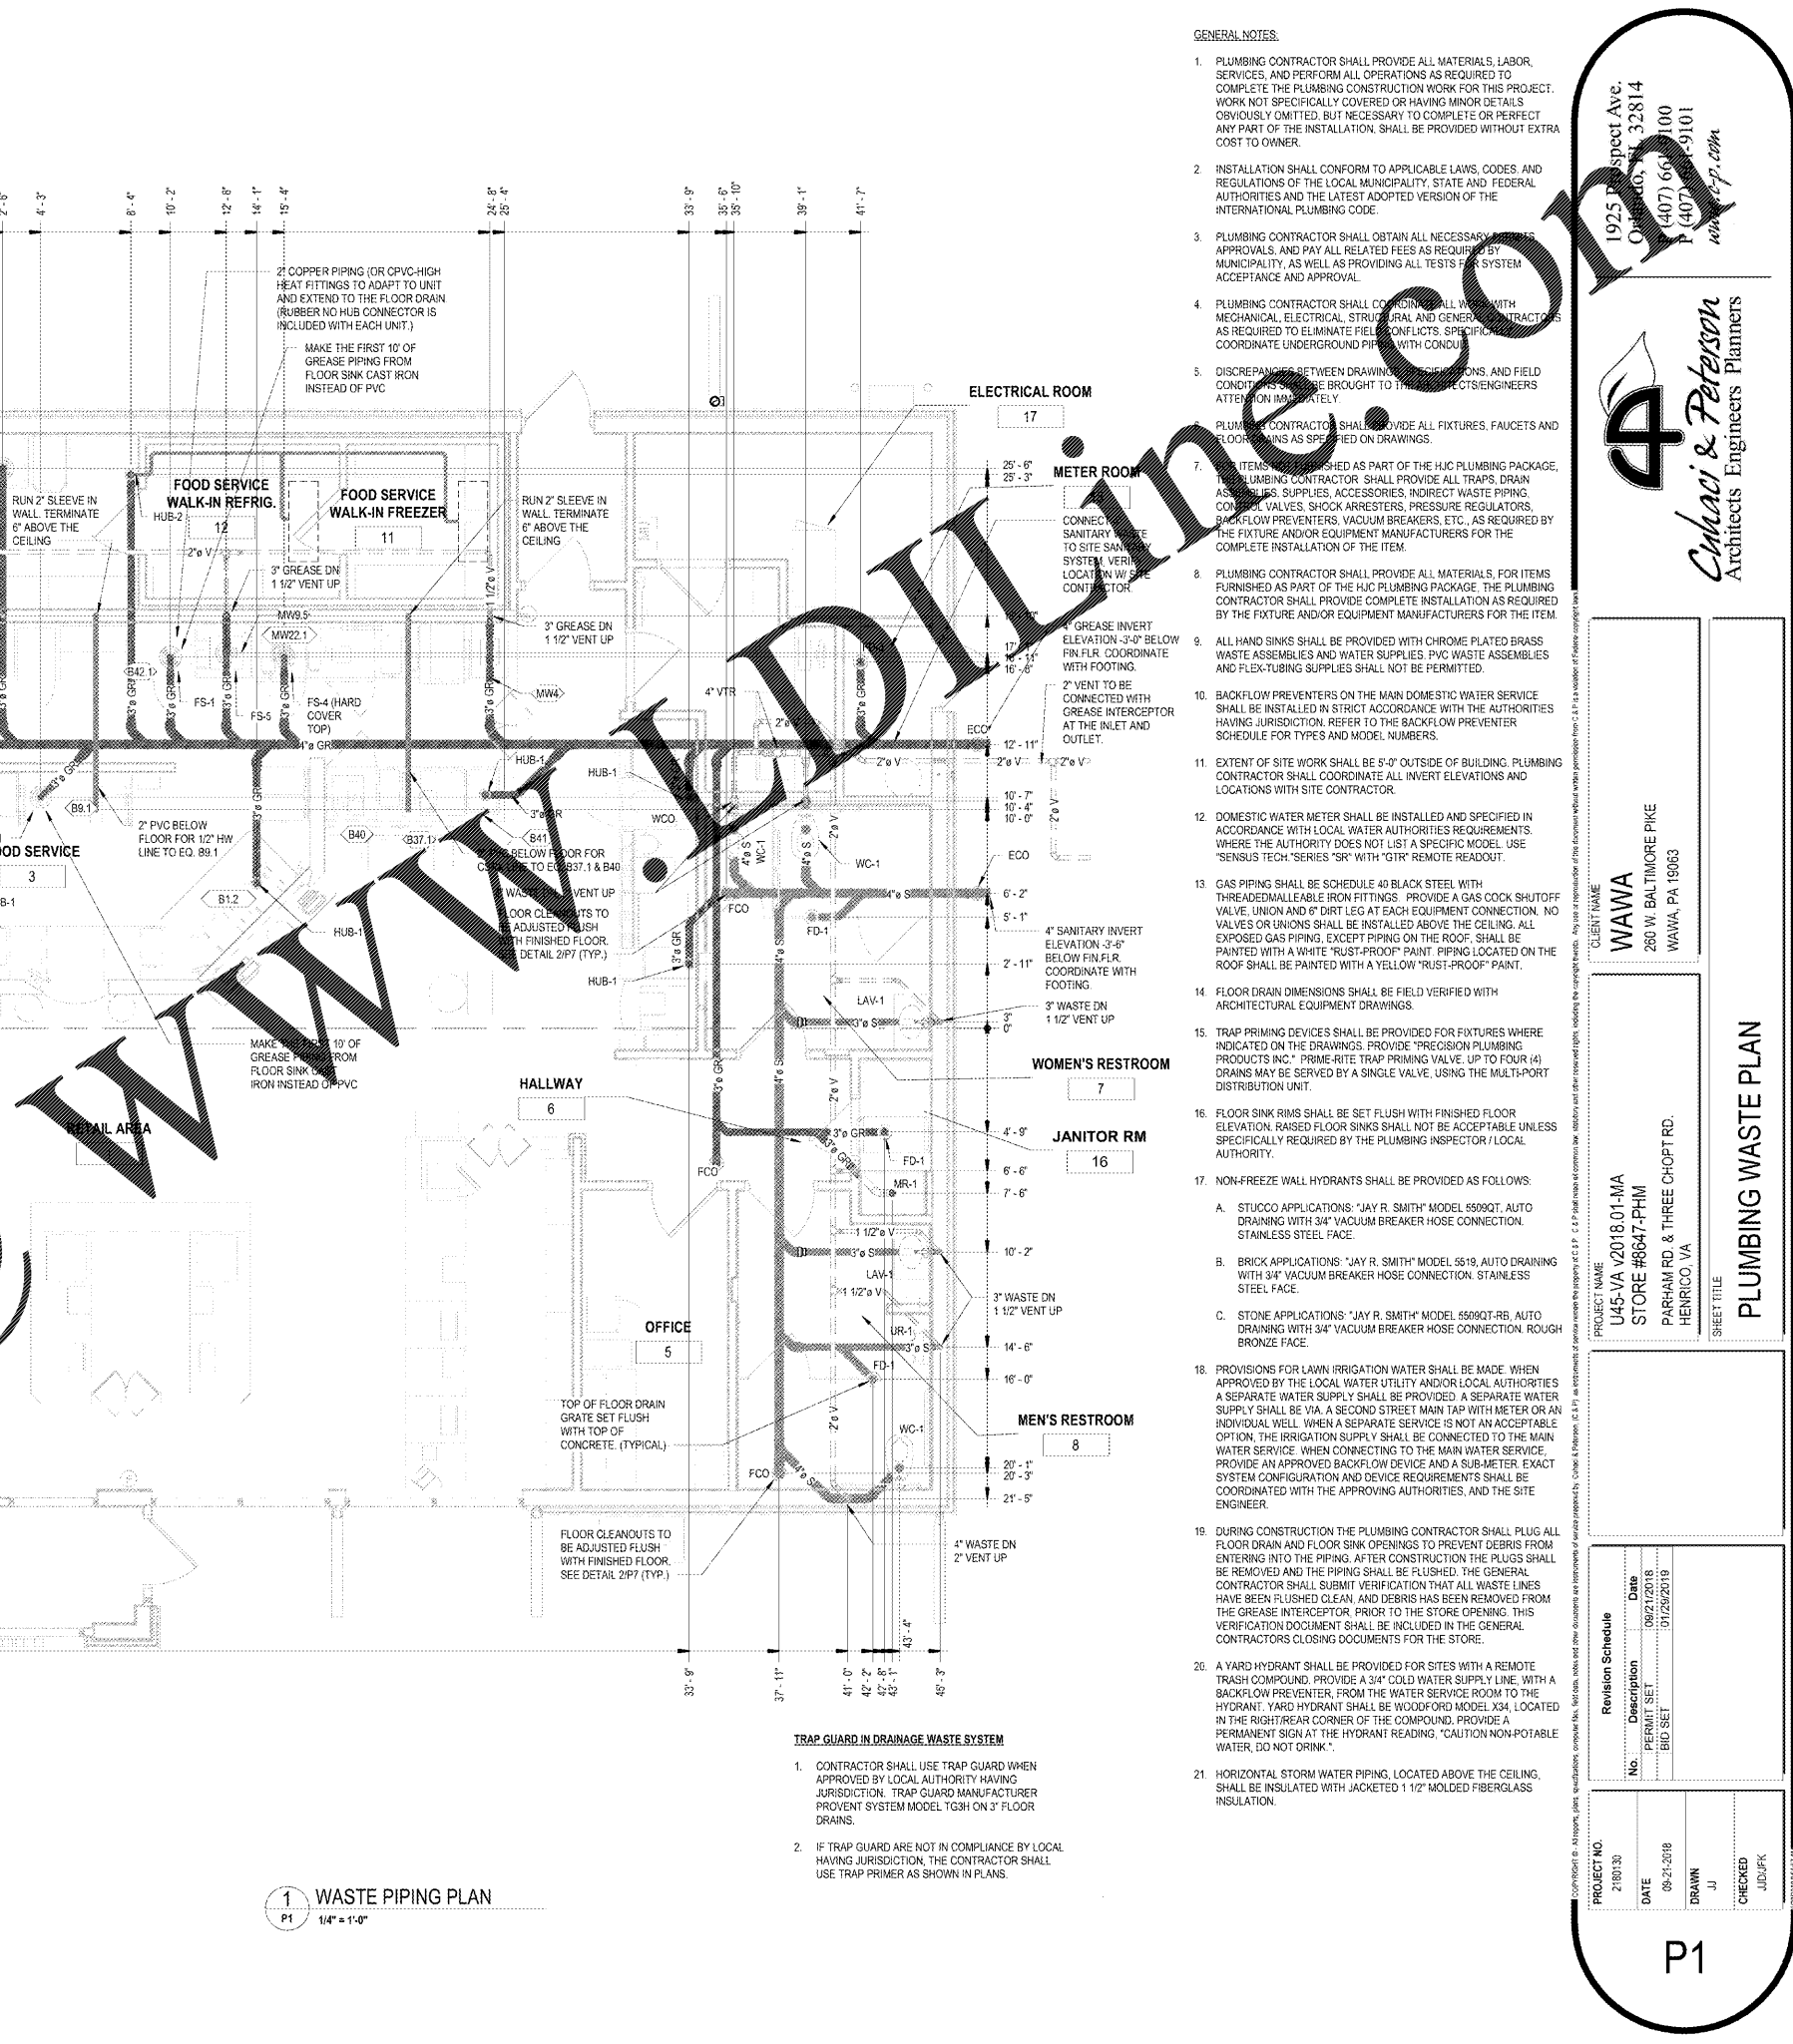

**1 WASTE PIPING PLAN**  
P1 1/4" = 1'-0"

**TRAP GUARD IN DRAINAGE WASTE SYSTEM**

- CONTRACTOR SHALL USE TRAP GUARD WHEN APPROVED BY LOCAL AUTHORITY HAVING JURISDICTION. TRAP GUARD MANUFACTURER: PREVENT SYSTEM MODEL T15H ON 3" FLOOR DRAINS.
- IF TRAP GUARD ARE NOT IN COMPLIANCE BY LOCAL HAVING JURISDICTION, THE CONTRACTOR SHALL USE TRAP PRIMER AS SHOWN IN PLANS.

1925 Prospect Ave.  
Owensboro, KY 40301  
(407) 668-1100  
(407) 668-9101  
www.c-p.com

**Chahaci & Peterson**  
Architects & Planners

**CLIENT NAME**  
WAWA  
280 W. BALTIMORE PIKE  
WAWA, PA 19083

**PROJECT NAME**  
U45-VA V2018 01-MA  
STORE #8647-PHM  
PARRHAM RD. & THREE CHOFT RD.  
HENRICO, VA

**SHEET TITLE**  
PLUMBING WASTE PLAN

Revision Schedule	No.	Description	Date
PERMIT SET			09/21/2018
BID SET			01/25/2019

**PROJECT NO.**  
2180133  
**DATE**  
05-21-2018  
**DRAWN**  
JJ  
**CHECKED**  
JUD/JFK

P1