
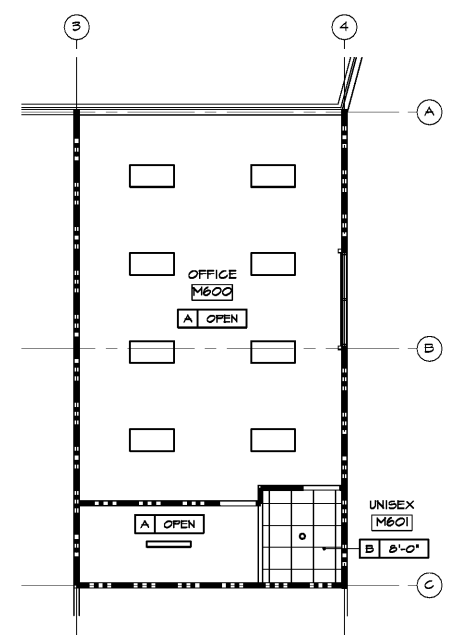


CEILING NOTES	
1.	CENTER CEILING GRIDS IN BOTH DIRECTIONS IN ALL CORRIDORS AND IN EACH ROOM WITH LAY-IN CEILINGS, UNLESS INDICATED OTHERWISE.
2.	CENTER ALL INTERIOR DOWNLIGHTS IN CEILING TILES. IN ROOMS WITHOUT CEILING TILES, CENTER DOWNLIGHTS IN BOTH DIRECTIONS TO RELATIVE WALLS.
3.	CENTER 2x4, 1x4, 2x2 SURFACE MOUNTED FIXTURES, OR DOWNLIGHTS IN BOTH DIRECTIONS OF SPACES.
4.	REFER TO ELECTRICAL DRAWINGS FOR LIGHTING FIXTURE LAYOUT AND SPECIFICATIONS.
5.	REFER TO MECHANICAL DRAWINGS FOR DIFFUSER LOCATIONS.
6.	PROVIDE ADEQUATE ACCESS TO EQUIPMENT, FITTINGS, VALVES, ETC. THAT ARE NOT EXPOSED ABOVE CEILINGS AND BEHIND WALL FINISHES. OPENINGS SHALL BE PROVIDED AS APPROPRIATE FOR THE FIRE RESISTANCE RATINGS OF THE WALLS PER NFPA 101 LIFE SAFETY CODE.
7.	ALL NOTED CEILING HEIGHTS ARE MEASURED FROM TOP OF SLAB.

CEILING TYPE	
A	OPEN TO STRUCTURE ABOVE
B	2'X2' SUSPENDED CEILING GRID WITH ACOUSTICAL CEILING TILES
C	EXTERIOR GRADE SUSPENDED CEILING TILE W/ HOLD DOWN CLIPS

CEILING LEGEND	
A 8'-0"	CEILING HEIGHT
[Symbol]	CEILING TYPE
[Symbol]	PENDANT MOUNTED FLUORESCENT LIGHT FIXTURE - LED HIGH BAY
[Symbol]	RECESS MOUNTED 24"X48" LED LIGHT FIXTURE
[Symbol]	SURFACE MOUNTED 4' STRIP LIGHT FIXTURE
[Symbol]	SURFACE MOUNTED 8' STRIP LIGHT FIXTURE
[Symbol]	THO HEAD BATTERY POWERED EMERGENCY LIGHT - EMERGENCY LIGHT WITH BATTERY BACK UP
[Symbol]	RECESSED DOWNLIGHT FIXTURE - 6" APERTURE LED DOWN LIGHT
[Symbol]	EXIT LIGHT, WALL MOUNTED - EXIT SIGN
[Symbol]	SURFACE MOUNTED WALL SCONCE - MOUNTED FULL CUTOFF FIXTURE

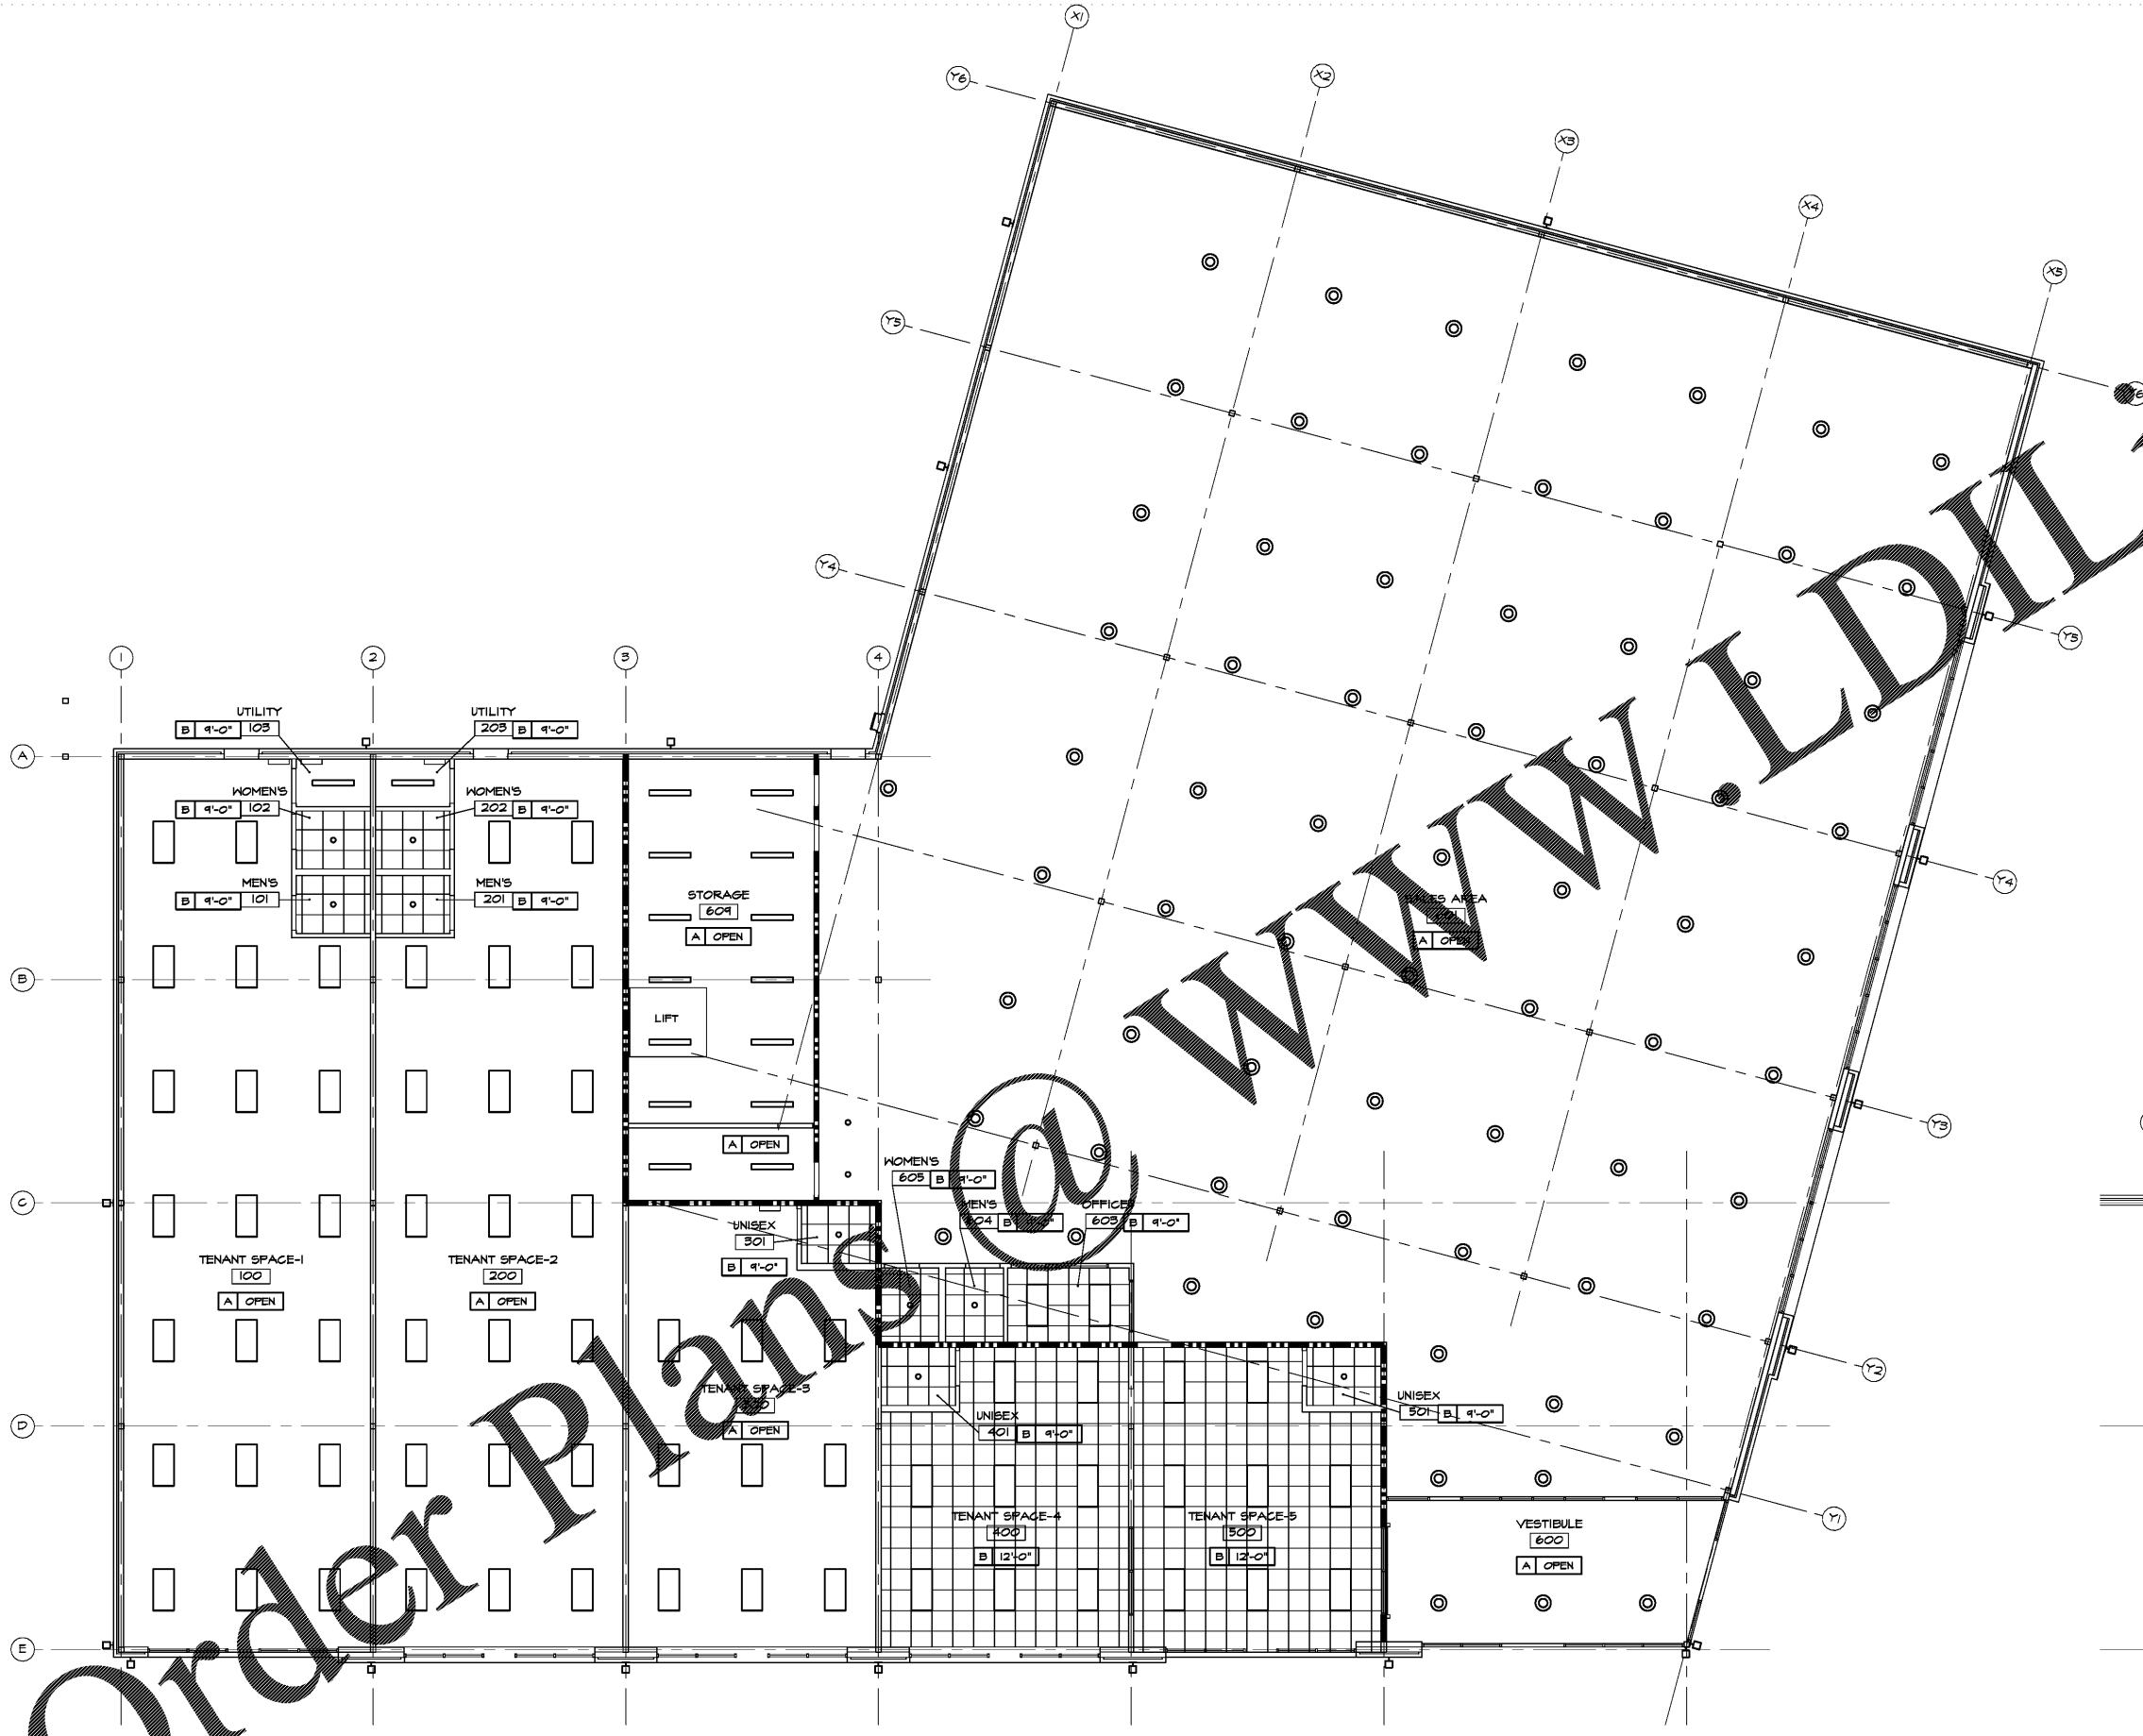

1 GROUND FLOOR REFLECTED CEILING PLAN
 SCALE 1/8" = 1'-0"

2 MEZZANINE FLOOR REFLECTED CEILING PLAN
 SCALE 1/8" = 1'-0"

REVISIONS	NO.	DATE	DESCRIPTION

RETAIL DEVELOPMENT
POP'S WINE & SPIRITS
 2-1764 TR A-B MCFARLAND 400 IND PARK
 ALPHARETTA GA 30004

GROUND FLOOR PLAN AND MEZZANINE REFLECTED CEILING PLAN
 PROJ. NO: 201834
 DATE: 01/20/2019

A1.4