


WWW.ONLINE.COM

HVAC SYMBOLS

	SUPPLY GRILL
	RETURN GRILL
	EXHAUST FAN
	NEW DUCTWORK
	SPIN-IN
	PROGRAMMABLE THERMOSTAT
	FIRE DAMPER
	VOLUME DAMPER

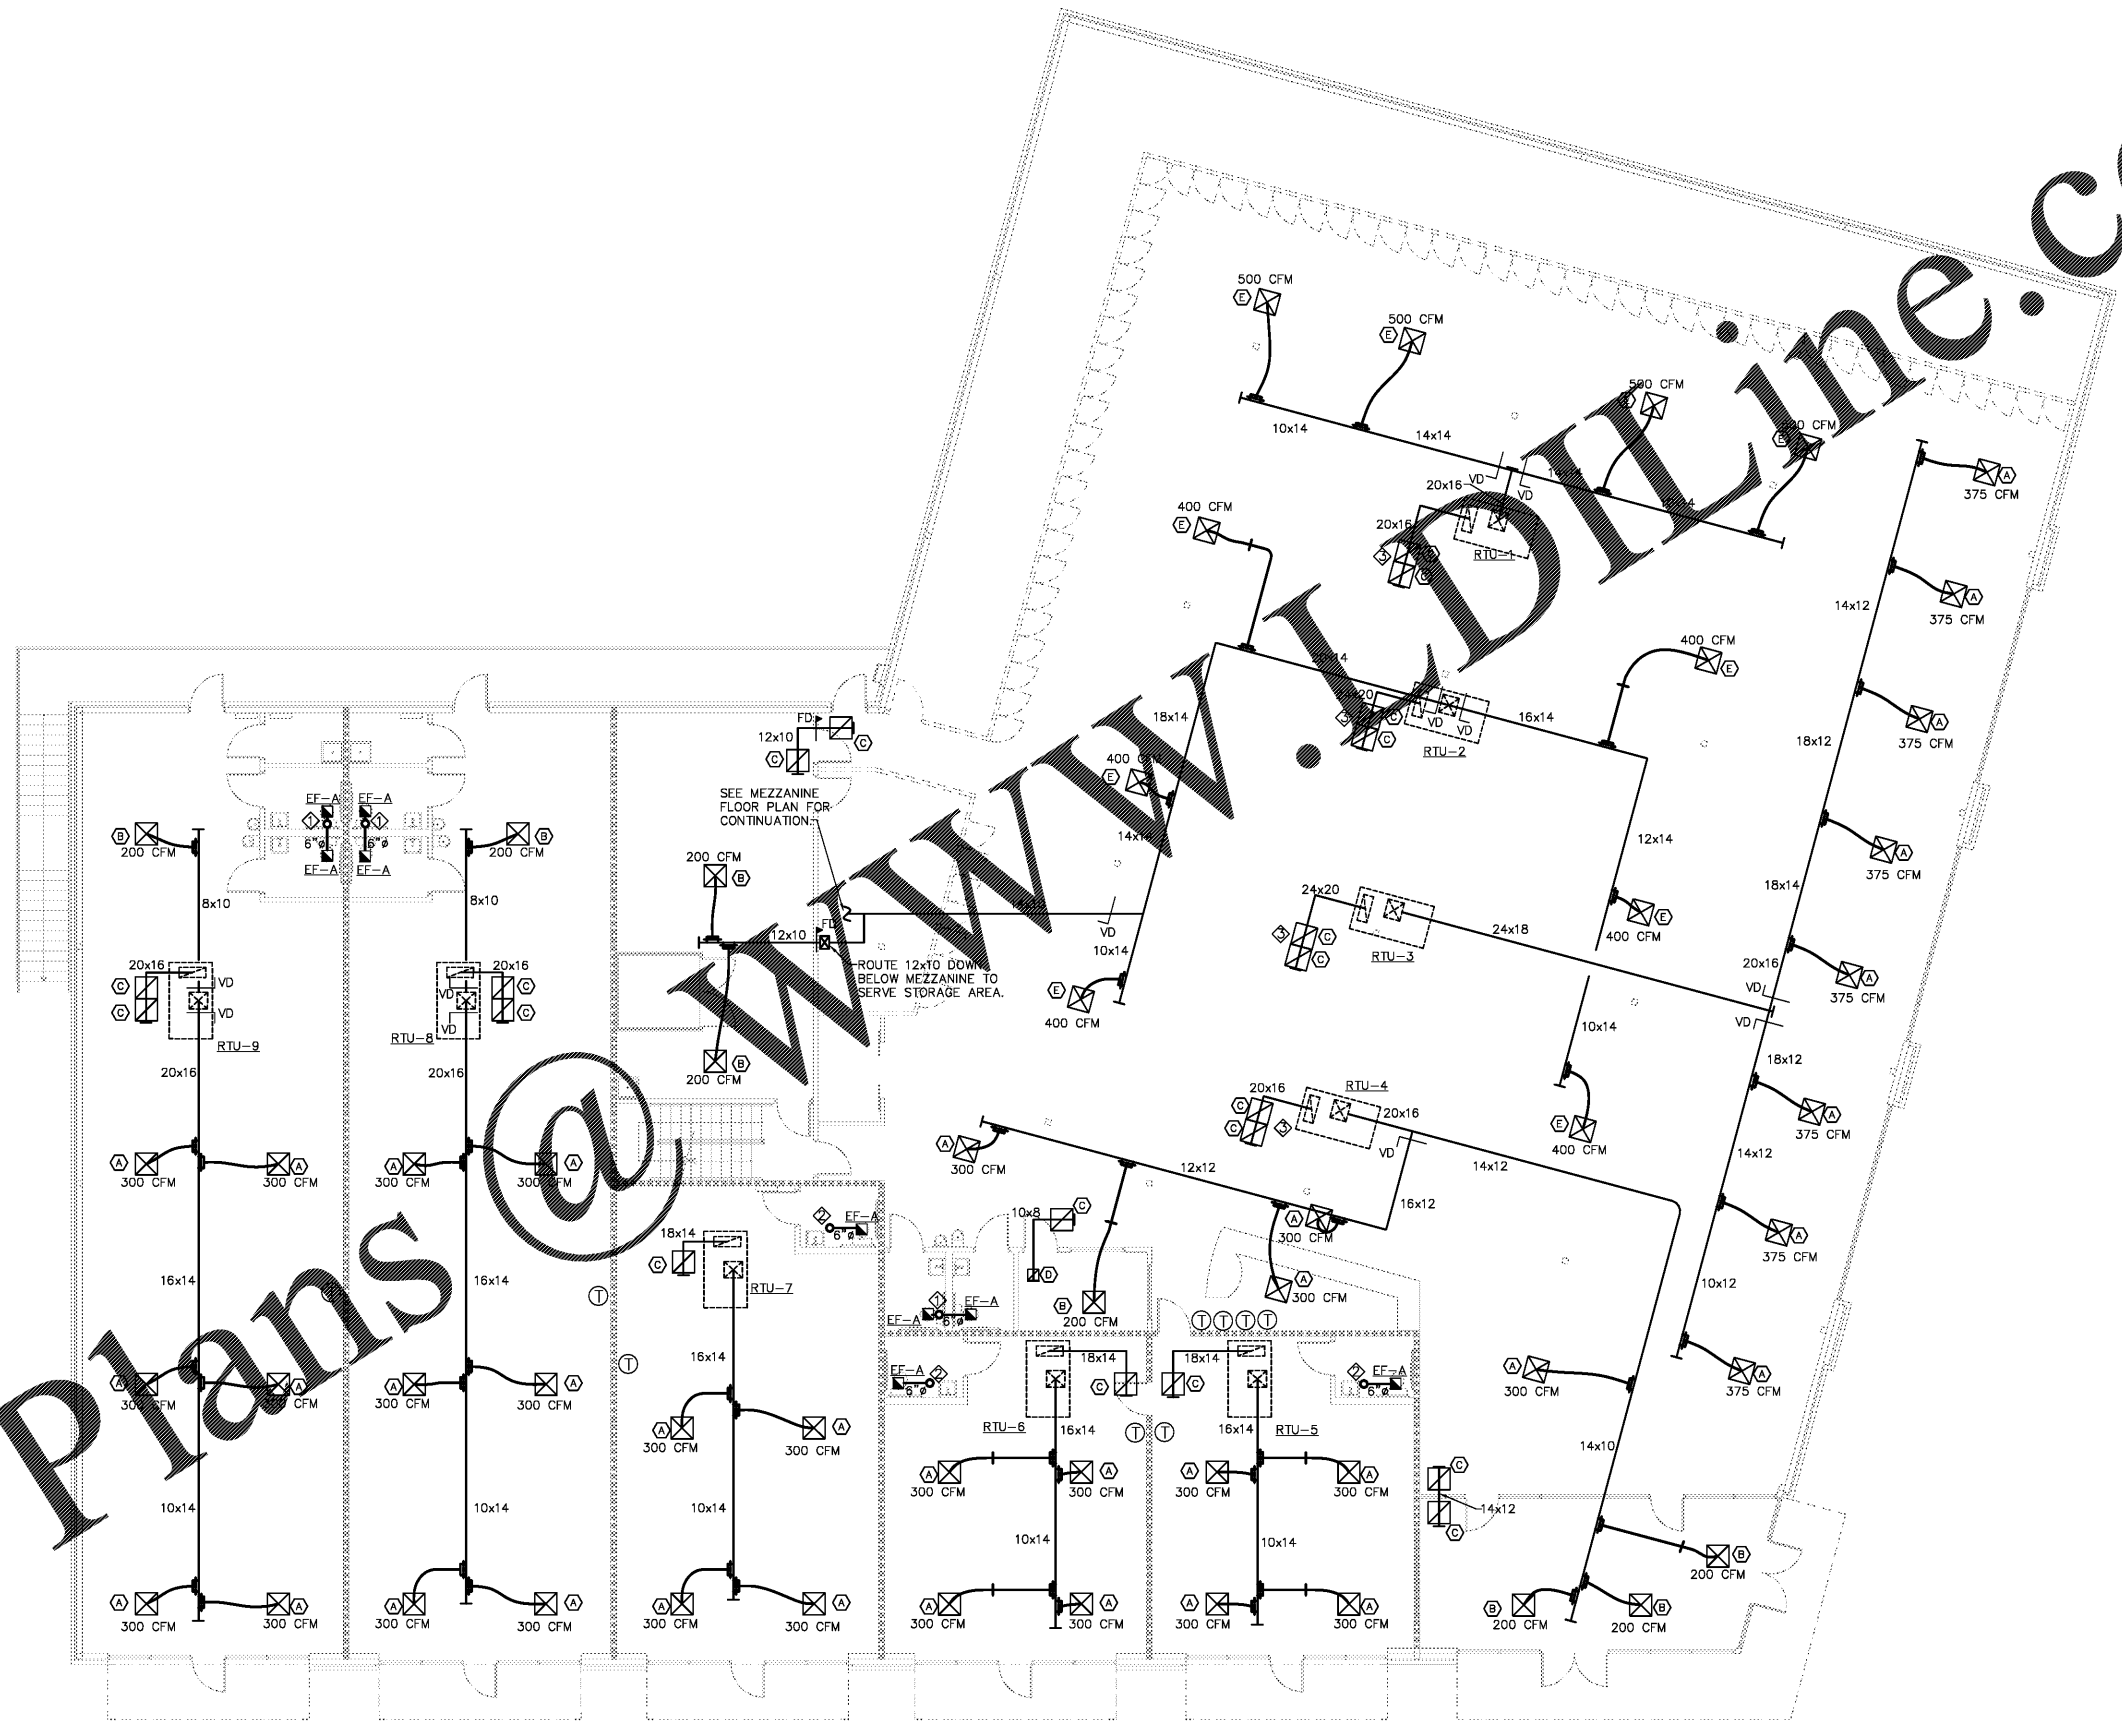

MECHANICAL KEYED NOTES.

- ◇ EXTEND 8" EXHAUST DUCTWORK UP THRU ROOF AND TERMINATE WITH ROOF CAP.
- ◇ EXTEND 6" EXHAUST DUCTWORK UP THRU ROOF AND TERMINATE WITH ROOF CAP.
- ◇ INSTALL TEMPERATURE SENSOR IN RETURN AIR DUCT WITH THERMOSTAT INSTALLED ON WALL BEHIND CASH REGISTER. EACH THERMOSTAT SHALL BE SEPARATE.

1 HVAC Ground Floor Plan
SCALE: 1/8" = 1'-0"

REVISIONS	NO.	DATE	DESCRIPTION

RETAIL DEVELOPMENT
POP'S WINE & SPIRITS
2-1764 TR A-B MCFARLAND 400 IND PARK
MCFARLAND PKWY ALPHARETTA GA 30004

HVAC GROUND FLOOR PLAN

PROJ. NO: 201834
DATE: 01/18/2019

M1.2