

SPECIFICATIONS
DIVISION 9: FINISHES

- SECTION 9A: GYPSUM WALLBOARD
GENERAL PROVISIONS
- SCOPE: FURNISH AND INSTALL GYPSUM WALLBOARD AS A SUBSTRATE FOR OTHER FINISH MATERIALS ON ALL INTERIOR WALLS AND THE INTERIOR PORTIONS OF EXTERIOR WALLS. FURNISH AND INSTALL GYPSUM BOARD SUSPENDED CEILING WITH HANGERS AND SUPPORTS.
 - MATERIALS
 - MATERIAL NAMES ARE BASED ON A NATIONAL GYPSUM GOLD BOND STA-SMOOTH BEVEL EDGE SYSTEM. USE GOLD BOND OR EQUAL SYSTEM BY U.S. GYPSUM.
 - WALLS (EXCEPT WHERE NOTED): 1/2" STA-SMOOTH GYPSUM WALLBOARD
 - WALLS WHERE NOTED: 1/2" THICK TAPERED GYPSUM (MOISTURE RESISTANT) GYPSUM WALLBOARD
 - DROPPED CEILING WHERE NOTED: 1/2" STA-SMOOTH GYPSUM WALLBOARD
 - FIRE RATED WHERE NOTED: FIRE SHIELD (GYPSUM WALLBOARD) REQUIRED BY CODE
 - FASTENERS
 - GWB SHALL BE LONG ANCHOR RING SHANK NAILS MEETING THE REQUIREMENTS OF ASTM C-35.
 - 1" LONG LAG SCREWS TO WOOD STUDS.
 - 1" LONG THIN DRYWALL SCREWS TO INTERIOR METAL STUDS.
 - 1" LONG THIN CORROSION RESISTANT SCREWS FOR EXTERIOR GYPSUM SHEATHING TO METAL STUDS.
 - JOINT TREATMENT COMPOUND SHALL BE READY MIXED. JOINT TAPE SHALL BE CROSS PERFORATED, FEATHER EDGED. CORNER BEADS SHALL BE GALVANIZED STEEL ROLL-FORMED U-SHAPED CHANNELS.
 - HANGERS AND SUPPORTS: 2x4 WOOD FRAMING. SUBSTITUTION: FOR STEEL TRUSS BUILDINGS 1-1/2" CARRYING CHANNELS, 3/4" FURRING CHANNELS, 6 GAGE HANGER WIRES, 16 GAGE THE WIRES, AND 1" TYPE S SCREWS.
- PERFORMANCE
- INSTALLATION
 - CUTTING WALLBOARD: GYPSUM WALLBOARD SHALL BE CUT BY SCORING AND BREAKING, OR BY SAWING, WORKING FROM THE FACE SIDE. WHERE BOARD MEETS PROJECTING SURFACES, IT SHALL BE SCRIBED NEATLY.
 - INSTALLING WALLBOARD: GYPSUM WALLBOARD SHALL BE APPLIED AT RIGHT ANGLES TO FRAMING MEMBERS. BOARDS OF MAXIMUM PRACTICAL LENGTH SHALL BE USED SO THAT AN ABSOLUTE MINIMUM NUMBER OF END JOINTS OCCUR. WALLBOARD JOINTS AT OPENINGS SHALL BE LOCATED SO THAT NO END JOINT SHALL ALIGN WITH EDGES OF OPENINGS. END JOINTS SHALL BE STAGGERED.
 - FASTENING WALLBOARD: ATTACH WITH SCREWS OR NAILS SPACED APPROXIMATELY 8" o.c. THE NAILS SHALL BE DRIVEN HOME WITH THE HEAD SLIGHTLY BELOW THE SURFACE OF THE BOARD IN A DIMPLE FORMED BY THE DRIVING TOOL.
 - FASTENING EXTERIOR GYPSUM SHEATHING: ATTACH TO METAL STUDS WITH SCREWS @ 12" o.c. WITH HEAD FLUSH WITH SURFACE.
 - JOINTS FINISHING: JOINT COMPOUND, QUICK-TREAT, AND TOPPING COMPOUND SHALL BE APPLIED IN ACCORDANCE WITH PRINTED INSTRUCTIONS CONTAINED IN THE PACKAGE. A UNIFORM THIN LAYER OF JOINT COMPOUND SHALL BE APPLIED OVER THE JOINT UNDER THE TAPE TO PROVIDE PROPER BOND. CEILING AND WALL ANGLES AND INSIDE CORNER ANGLES SHALL BE REINFORCED WITH THE TAPE FOLDED TO CONFORM TO THE ANGLE AND EMBEDDED IN THE COMPOUND. AFTER THE COMPOUND IS THOROUGHLY DRY, APPROXIMATELY TWENTY FOUR (24) HOURS FOR REGULAR COMPOUND, 2-12 HOURS FOR QUICK TREAT, THE TAPE SHALL BE COVERED WITH A COAT OF JOINT COMPOUND OR TOPPING COMPOUND SPREAD OVER THE TAPE APPROXIMATELY 3" ON EACH SIDE OF TAPE, AND FEATHERED OUT AT THE EDGE. AFTER THOROUGHLY DRY, APPLY ANOTHER COAT OVER JOINTS. THIS COAT SHALL BE SMOOTH AND THE EDGES FEATHERED APPROXIMATELY 3" BEYOND THE PRECEDING COAT. ALLOW EACH APPLICATION OF COMPOUND TO JOINTS AND NAIL HEADS TO DRY, THEN SAND IF NECESSARY. ALL WALLBOARD AND TREATED AREAS SHALL BE SMOOTH AND READY FOR PAINTING OR WALLCOVERING.




POPEYES
1009 BARATARIA BLVD.
MARRERO, LOUISIANA
LOUISIANA KITCHEN LK-PLUS DESIGN STANDARDS
60 SEATS / DUAL-LINE PRODUCTION



POPEYES

REVISIONS:

FLOOR PLAN
DATE: 12/19/18
A1
CHECKED: JS

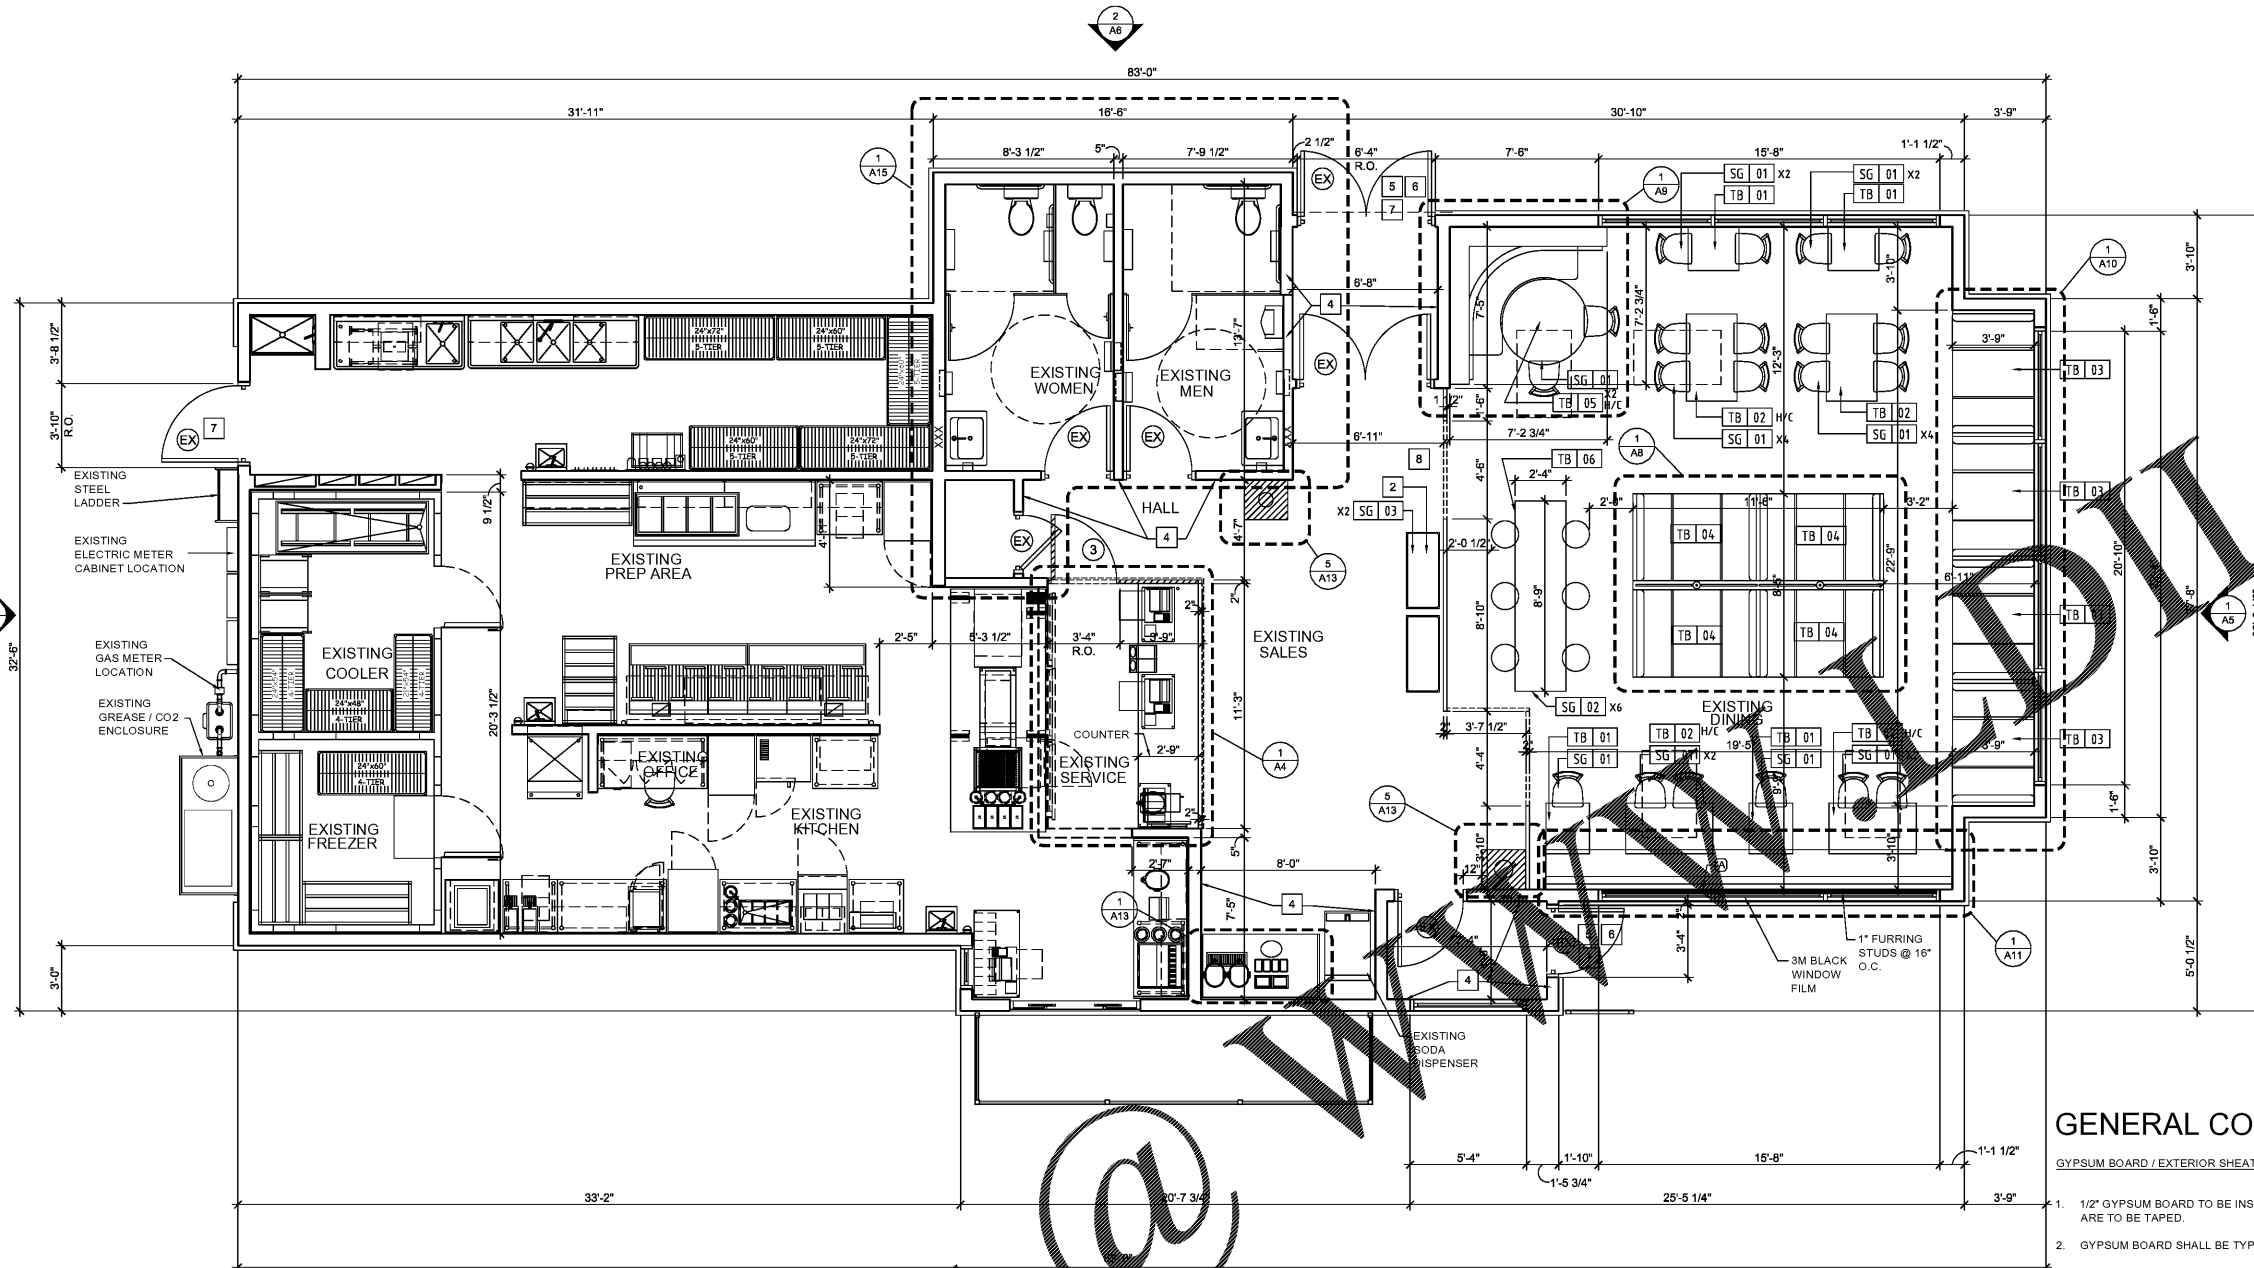

FLOOR PLAN
1
A1
1/4"=1'-0"

FRAMING SYMBOLS

- 1" FURRING FRAMING @ 16" O.C.
- DOOR NUMBER
EX DENOTES EXISTING TO REMAIN
- DETAIL NUMBER
SHEET NUMBER
PLAN DETAIL
- DETAIL NUMBER
SHEET NUMBER
SECTION DETAIL -
ARROW INDICATES DIRECTION OF VIEW
- XXX DENOTES BLOCKING AS REQUIRED

CONSTRUCTION KEY NOTES

- DIMENSIONS ARE SHOWN:
1) INTERIOR WALLS: FROM THE FACE OF FINISH WALL TO THE FACE OF FINISH WALL, U.N.O..
- LOCATION OF POSSIBLE KIOSK
- ALL GYPSUM BOARD BELOW FINISHED CEILING HEIGHT IS TO BE PREPARED FOR PAINTING OR WALLCOVERING AS INDICATED ON INTERIOR ELEVATIONS AND FINISH SCHEDULE. SEE GEN. CONSTR. NOTES FOR DINING AREA
- EXTEND EXISTING WOOD STUDS AND GYP. BD. 6" ABOVE NEW CEILING HEIGHT.
- HANDICAP ACCESS TO BUILDING IS DESIGNED ACCORDING TO APPLICABLE CODE. S.C. TO ENSURE THAT ALL DIRECTIONS AND DIMENSIONS GIVEN ARE STRICTLY ADHERED TO. IF CHANGES ARE MADE THAT CONTRADICT WITH THE DRAWING, OR IF EXISTING FILED CONDITIONS MAKE THE DRAWINGS NOT APPLICABLE, THE ARCHITECT MUST BE CONTACTED IMMEDIATELY.
- ALL DOORS SHALL BE ABLE TO BE OPENED FROM THE EGRESS SIDE WITHOUT THE USE OF A KEY, SPECIAL KNOWLEDGE OR EFFORT. MANUALLY OPERATED FLUSH BOLTS OR SURFACE BOLTS SHALL NOT BE USED.
- PROVISIONS FOR EXISTING EXIT DISCHARGE LIGHTING ARE SHOWN ON THE LIGHTING PLAN SHALL BE EXISTING TO REMAIN.
- ALL GLAZING WITHIN A 24" ARC OF DOORS WHOSE BOTTOM IS LESS THAN 60" ABOVE THE FLOOR AND ALL GLAZING IN DOORS SHALL BE SAFETY, TEMPERED, OR ACRYLIC PLASTIC SHEET.

GENERAL CONSTRUCTION NOTES

- GYPSUM BOARD / EXTERIOR SHEATHING NOTES:**
- 1/2" GYPSUM BOARD TO BE INSTALLED ON ALL INTERIOR WALLS WHERE PLYWOOD IS NOT REQUIRED. ALL JOINTS ARE TO BE TAPED.
 - GYPSUM BOARD SHALL BE TYPE "WMR" IN ALL AREAS TO RECEIVE WALL TILE OR FRP PANELS.
- BLOCKING NOTES:**
- "xxxxxxx" INDICATES BLOCKING REQUIRED IN WALL FOR PLUMBING LINES AND RESTROOM ACCESSORIES. BLOCKING SHALL BE FIRE RETARDANT WHERE REQUIRED BY CODE.
 - CONTRACTOR TO VERIFY REQUIREMENTS WITH LOCAL BUILDING OFFICIALS PRIOR TO BIDDING. CONTRACTOR IS RESPONSIBLE FOR OBTAINING MANUFACTURERS' CUT SHEETS AND LOCATING BLOCKING AS REQUIRED. THIS INCLUDES KITCHEN EQUIPMENT AND ITEMS FURNISHED AND INSTALLED BY OTHERS.
- FRAMING NOTES:**
- CONTRACTOR MAY SUBSTITUTE METAL STUDS FOR INTERIOR WALL, AND SOFFIT FRAMING. WHERE USED, METAL FRAMING TO BE 25 GA. UNLESS NOTED OTHERWISE (U.N.O.).
 - ALL INTERIOR WOOD FRAMING TO BE #2 SPRUCE, FIR OR WHITE PINE. WHERE REQUIRED BY CODE, FRAMING SHALL BE #2 FIRE RETARDANT YELLOW PINE. CONTRACTOR TO VERIFY REQUIREMENTS WITH LOCAL BUILDING OFFICIALS PRIOR TO BIDDING.
 - ALL WOOD IN CONTACT WITH THE SLAB MUST BE PRESSURE TREATED.
 - ALL INTERIOR WALLS TO BE FRAMED TO UNDERSIDE OF TRUSS U.N.O..

Order Plans @