




PLUMBING LEGEND	
	DOMESTIC COLD WATER PIPING
	EXIST. DOMESTIC COLD WATER
	DOMESTIC HOT WATER PIPING
	EXIST. DOMESTIC HOT WATER
	FILTERED WATER
	HOT WATER RECIRC
	VENT PIPING
	WASTE (SANITARY SEWER)
	EXIST. WASTE (SANITARY SEWER)
	GREASE WASTE
	EXIST. GREASE WASTE
	GAS PIPING
	GAS VALVE
	GAS SOLENOID VALVE
	GATE VALVE
	BALANCING VALVE
	CHECK VALVE
	UNION
	PIPE UP
	PIPE DOWN
	FLOOR DRAIN
	HUB DRAIN
	FLOOR SINK
	FLOOR CLEAN OUT
	GRADE CLEAN OUT
	WALL CLEAN OUT
	KITCHEN EQUIPMENT ITEM NUMBER
	FIXTURE DESIGNATION
	ABOVE FINISHED FLOOR
	PLUMBING SUB-CONTRACTOR
	GENERAL CONTRACTOR
	MECHANICAL SUB-CONTRACTOR
	ELECTRICAL SUB-CONTRACTOR
	FLOOR CLEAN OUT
	WALL CLEAN OUT
	GRADE CLEAN OUT
	HOSE BIBB
	FLOOR DRAIN
	FLOOR SINK
	HUB DRAIN
	COLD WATER
	HOT WATER
	TEMPERED WATER
	FILTERED WATER
	AIR ADMITTANCE VALVE (STUDOR VENT)
	TI INTO EXISTING

NOT ALL SYMBOLS AND ABBREVIATIONS IN THIS LEGEND WILL APPEAR IN DRAWING.

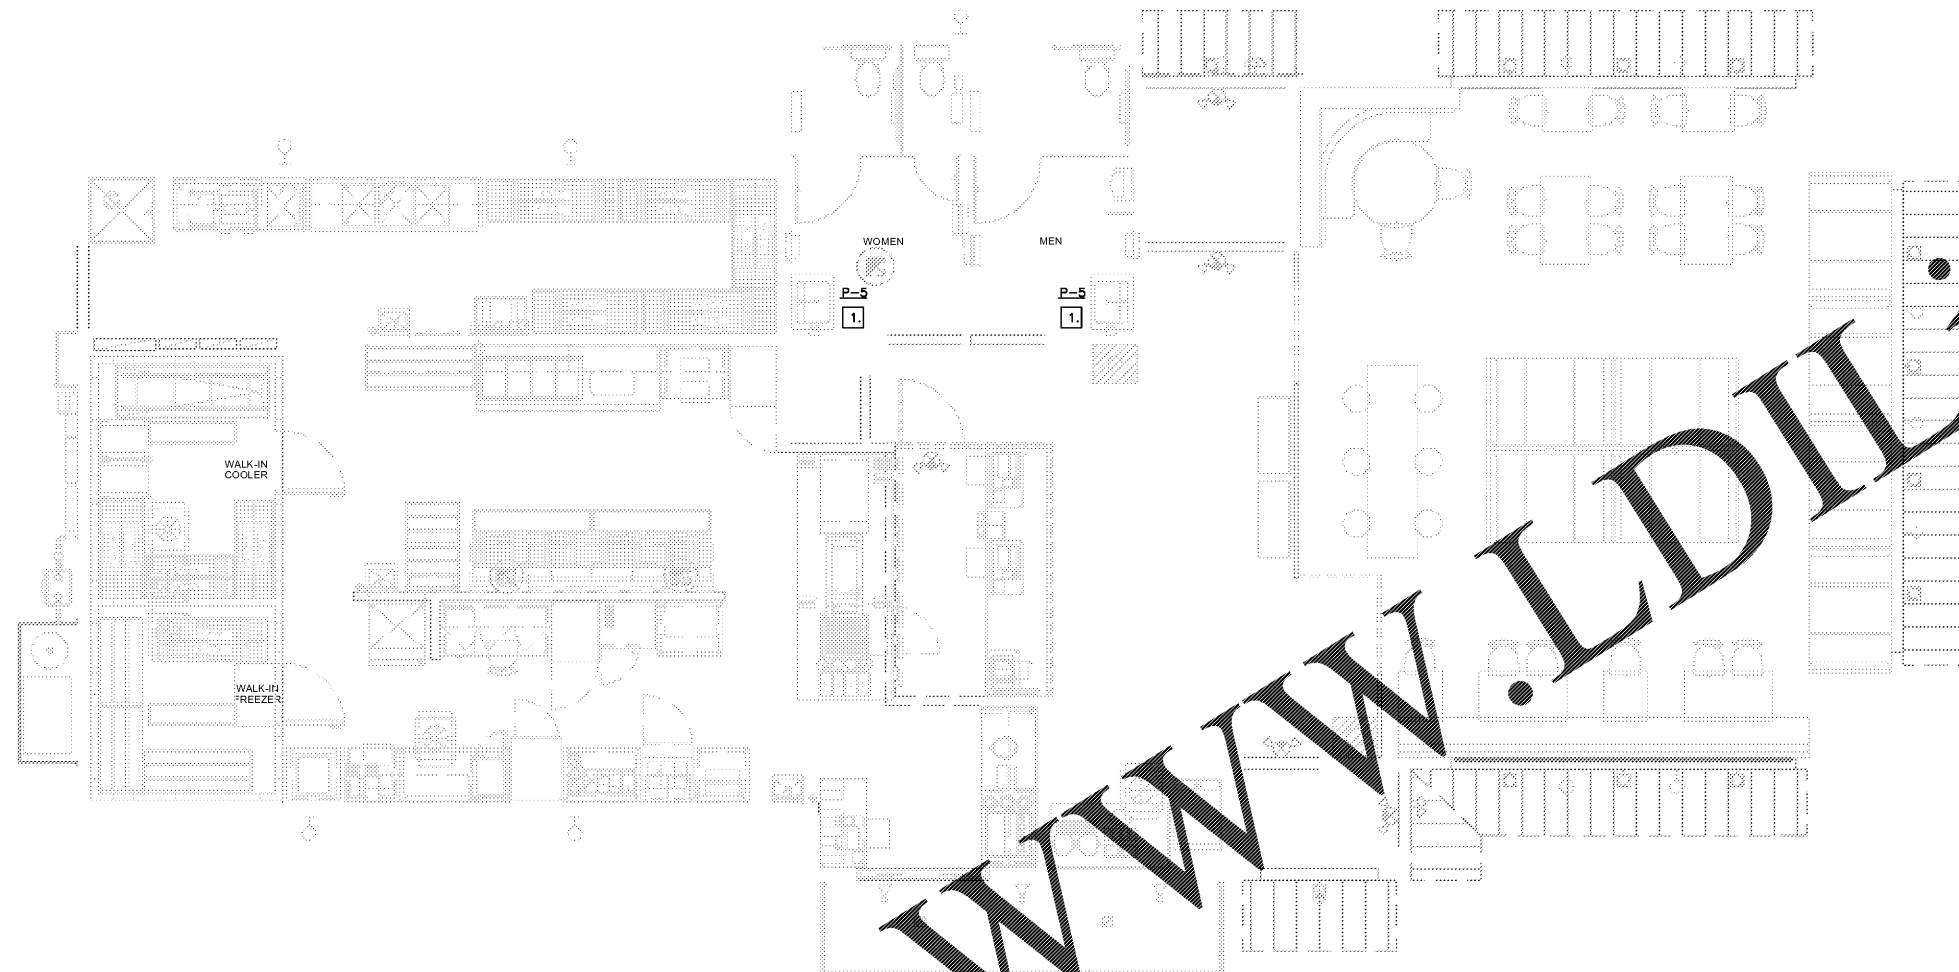

PLUMBING FIXTURE SCHEDULE						
MARK	FIXTURE	CONN.			MANUFAC. & MODEL	DESCRIPTION
		W	CW	HW		
P-5	LAVATORY (HANDICAP)	2"	1/2"	1/2"	KOHLER K-2650-1	VDX RECTANGLE BATHROOM SINK WITH SINGLE FAUCET HOLE AND KOHLER K-7518 GOOSENECK INSIGHT TOUCHLESS 0.5GPM PROXIMITY FAUCET, AND 50% CW MIXING VALVE, POLISH CHROME FINISH. PROVIDE LACINA TRAP COVER.


NOTES:
1. ALL VITREOUS CHINA FIXTURES SHALL BE WHITE.
2. INSULATE ALL WATER AND WASTE PIPING UNDER LAVATORIES WITH HANDY-SHIELD JACKET BY PLUMBERS (619) 633-1772.

1 PLUMBING PLAN
SCALE: 1/4" = 1'-0"

PLAN NOTES

- 1. EXISTING LAVATORY AT THIS LOCATION IS BEING REPLACED WITH NEW P-5. MODIFY EXISTING WASTE, VENT, CW, AND HW ROUGH-INS AS NECESSARY FOR PROPER INSTALLATION.

Order Plans @

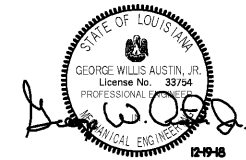

GEORGE W. AUSTIN, JR., PE
212 N. McDowell St., Suite 204
Charlotte, NC 28204
(P) 704.254.7363 (F) 704.347.0093
www.shaltreg.com
SEG - 18-321

THESE PLANS AND SPECIFICATIONS HAVE BEEN PREPARED BY ME OR UNDER MY SUPERVISION AND TO THE BEST OF MY KNOWLEDGE COMPLY WITH ALL LOCAL, STATE AND FEDERAL REQUIREMENTS.