


- PLUMBING GENERAL NOTES**
- EXACT LOCATION OF PLUMBING FIXTURES SHALL BE DETERMINED FROM ARCHITECTURAL DRAWINGS.
 - BEFORE SUBMITTING BID, THE PLUMBING CONTRACTOR SHALL REVIEW THE ARCHITECTURAL DRAWINGS AND INCLUDE IN HIS BID AN AMOUNT TO FURNISH AND INSTALL ANY FIXTURES WHICH ARE SHOWN IN ADDITION TO FIXTURES SHOWN ON THE PLUMBING DRAWINGS.
 - CONTRACTOR SHALL VERIFY INVERT ELEVATIONS OF SEWERS TO WHICH NEW WASTE LINES ARE TO BE CONNECTED BEFORE MAKING UP OR INSTALLATION OF NEW WASTE SYSTEM.
 - CONTRACTOR SHALL VERIFY AND COORDINATE LOCATION OF ALL PLUMBING LINES WITH DUCTWORK AND ELECTRICAL SERVICES.
 - THE INSTALLATION OF ALL VALVES, UNIONS, THERMOMETERS, GAUGES, OR OTHER INDICATING OR RECORDING EQUIPMENT, OR SPECIALTIES REQUIRING FREQUENT READING, REPAIRS, ADJUSTMENT, INSPECTION, REMOVAL OR REPLACEMENT SHALL BE CONVENIENTLY AND ACCESSIBLY LOCATED WITH REFERENCE TO THE FINISHED BUILDING.
 - ALL VENTS THROUGH ROOF SHALL BE 10'-0" REMOVED FROM ALL AIR INTAKES, EVAPORATIVE COOLERS, ETC. WHERE POSSIBLE, TIE VENTS TOGETHER SO THAT A MINIMUM NUMBER TERMINATE THROUGH THE ROOF.
 - CONTRACTOR SHALL NOT CUT HOLES IN STRUCTURAL MEMBERS WITHOUT FIRST SECURING WRITTEN APPROVAL FROM THE ARCHITECT.
 - CONTRACTOR SHALL INSTALL DIELECTRIC UNIONS AT CONNECTIONS OF DISSIMILAR METALS.
 - CONTRACTOR SHALL ROUGH-IN ALL WASTES AND SUPPLIES TO SPECIAL EQUIPMENT ACCORDING TO MANUFACTURERS SHOP DRAWINGS AND MAKE FINAL CONNECTIONS. ALL SUPPLIES SHALL BE VALVED.
 - ALL PIPING TO BE NEW UNLESS NOTED OTHERWISE.

- KEYED NOTES**
- P01 TANKLESS WATER HEATERS FURNISHED AND INSTALLED BY GENERAL CONTRACTOR. WATER HEATERS TO HAVE VANDAL CAGE PLACED AROUND THEM. INSTALL PER MANUFACTURERS RECOMMENDATIONS.
- P02 CONNECT NEW COLD WATER PIPING TO EXISTING 2" OR GREATER LANDLORD BACKFLOW PREVENTER. PROVIDE NEW 2" WATER METER. VERIFY LOCATION, SIZE, AND PRESSURE PRIOR TO BID. ASSUMED WATER PRESSURE IS 80 PSI AS STATED IN LEASE. CONTRACTOR TO PROVIDE PRESSURE READING PRIOR TO BID.

MY SALON Suite

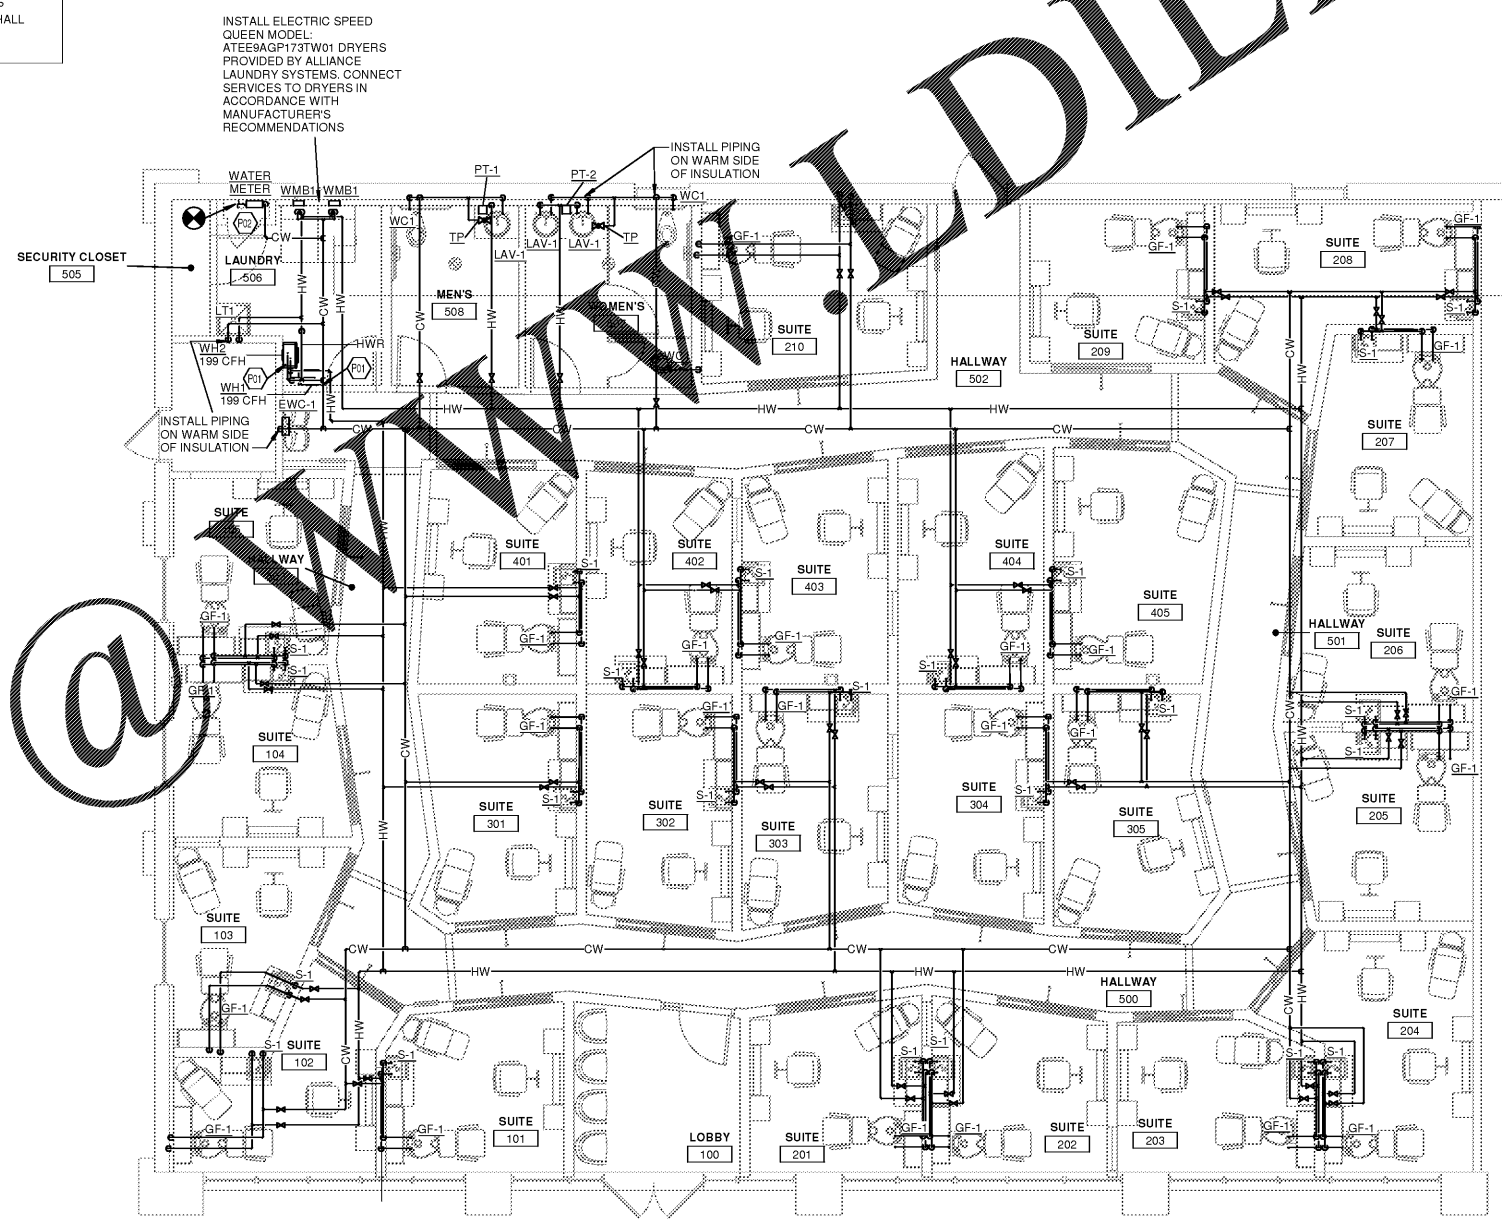

1 PLUMBING - WATER PLAN
 3/16" = 1'-0"

Order Plans @

ISSUE INFORMATION

1.10.2019
REVISIONS

FRCH / ARCHITECTURE, INC., P.C.

PROJECT INFORMATION

Marketplace Center
 MSS #5158
 1948 Old Fort Pkwy
 Murfreesboro, TN 37129

PROJECT #: 20894

SHEET INFORMATION

PLUMBING WATER PLAN

DRAWN BY: DMT
 REVIEWED BY: MCD
 SCALE: As Noted
 AUTHORIZED FOR: Bid/Permit/LL

© 2017 The drawing, printed or otherwise, is the copyrighted property of FRCH Design, Architecture, Inc., P.C. The drawing may not be used, reproduced or copied without the permission of FRCH Design, Architecture, Inc., P.C.